


M. En. P. Engineers  
 Reg.#12249  
 124 N. Spring Dr.,  
 Richardson, TX 75081  
 972-697-3057  
 KChishti@aol.com

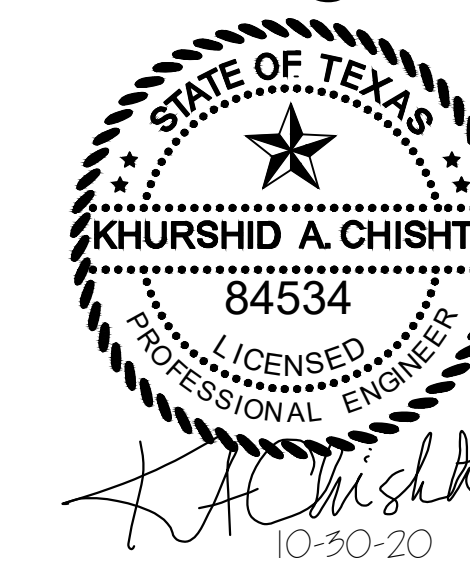

Project

**RADHA KRISHNA TEMPLE**  
 1450 N. WATERS ROAD  
 ALLEN, TX 75013

ISSUE	DATE	DESCRIPTION

PROJECT NUMBER CM170123

SCALE

DRAWN TCG


DATE 06/05/2020

SHEET DESCRIPTION

**KITCHEN HVAC  
 PLAN**

SHEET NUMBER

**M1.0**

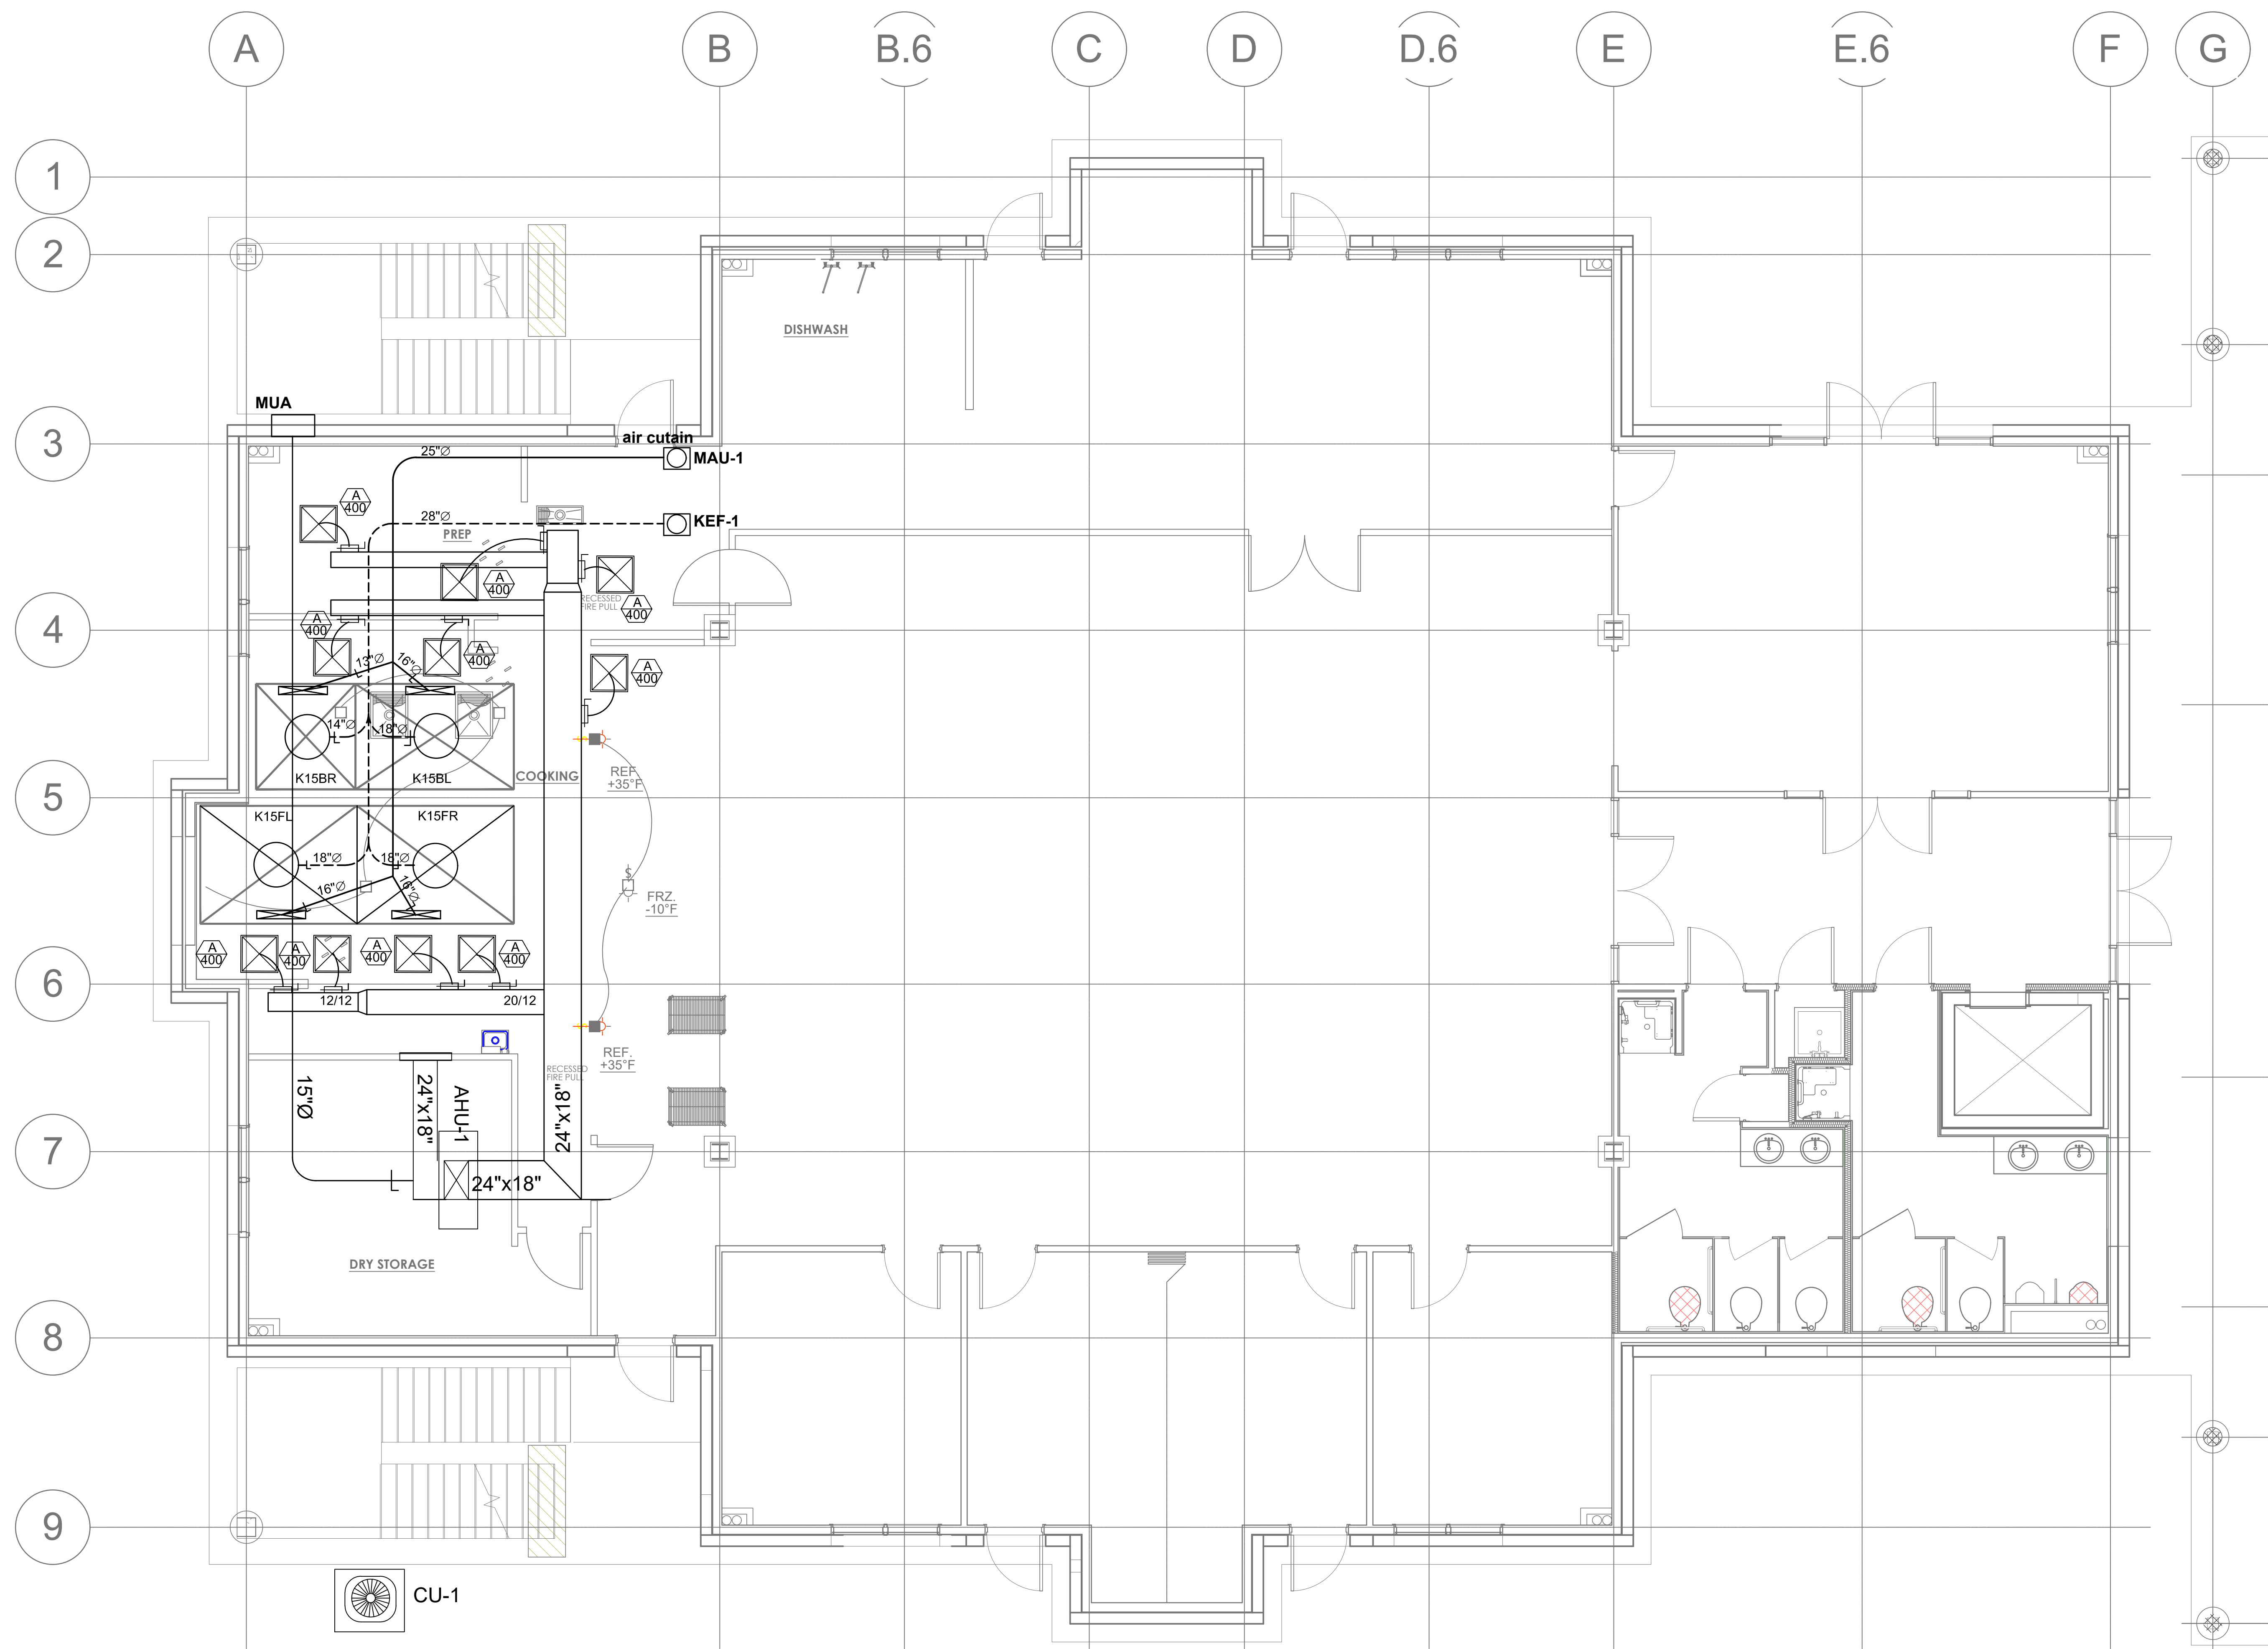

**01 KITCHEN HVAC PLAN**

SACLE: 1/4" = 1'-0"