
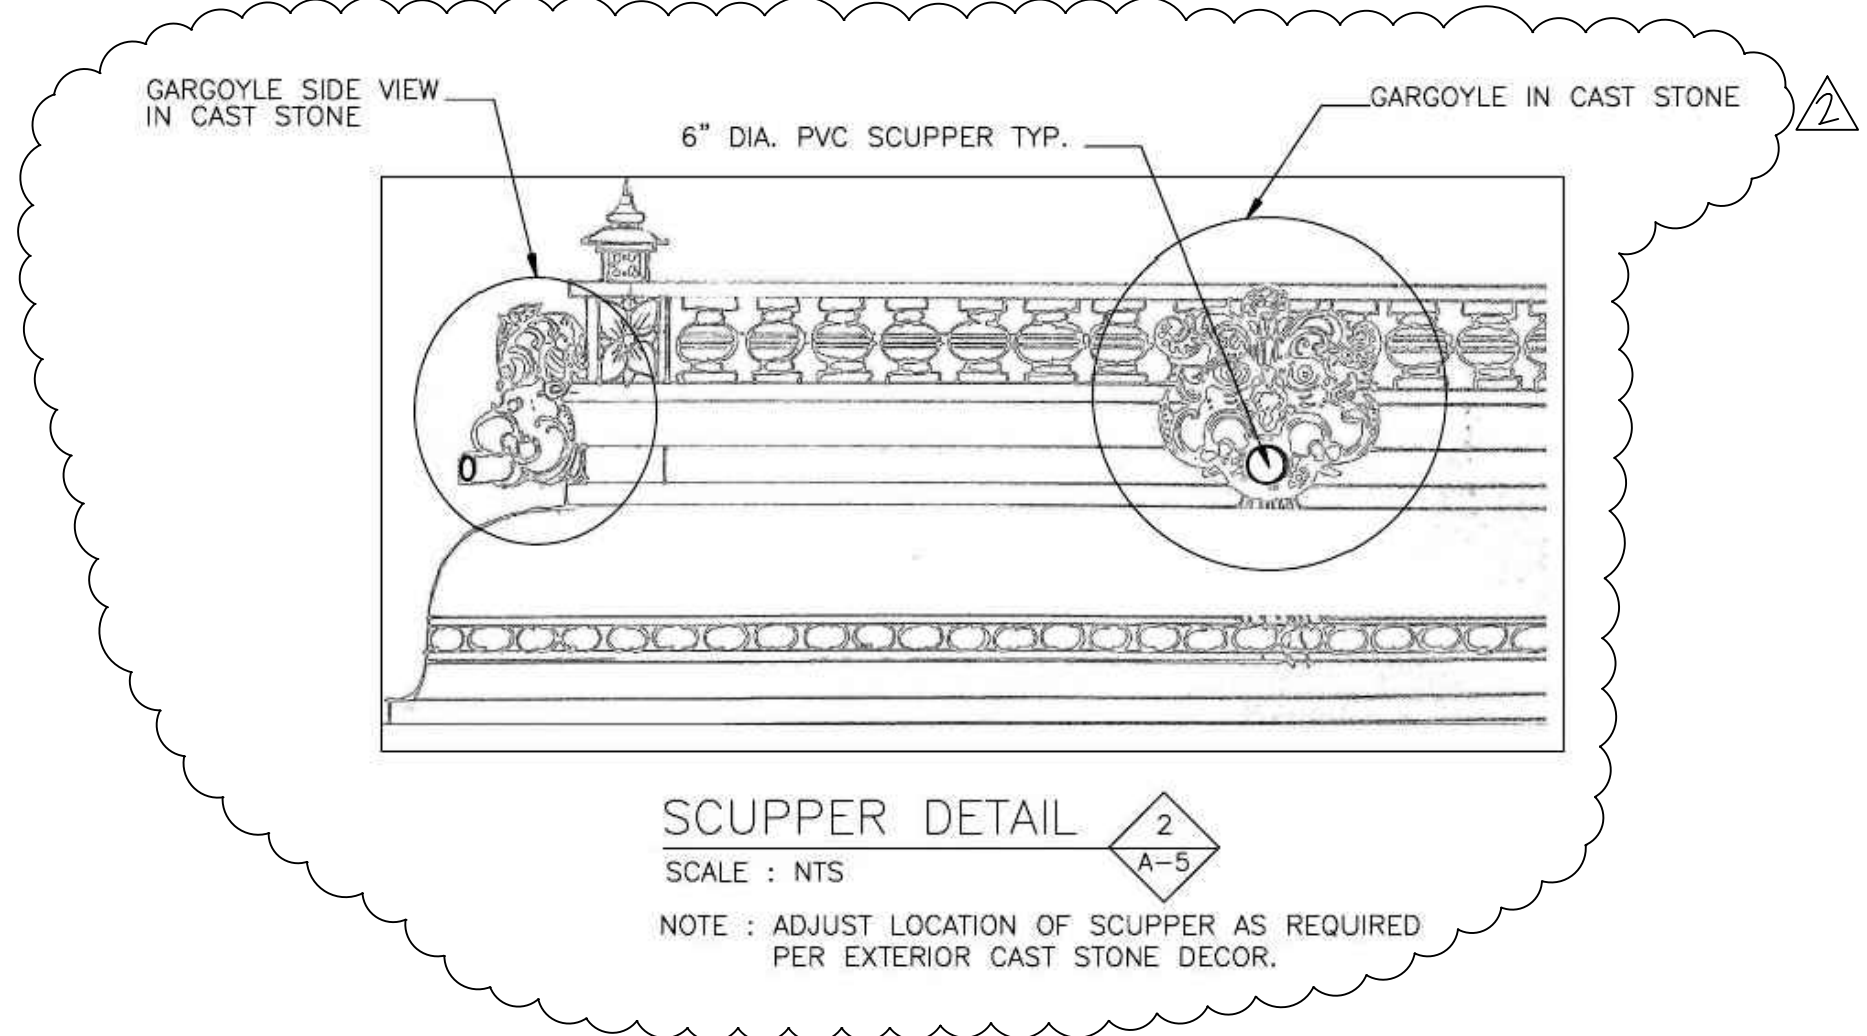
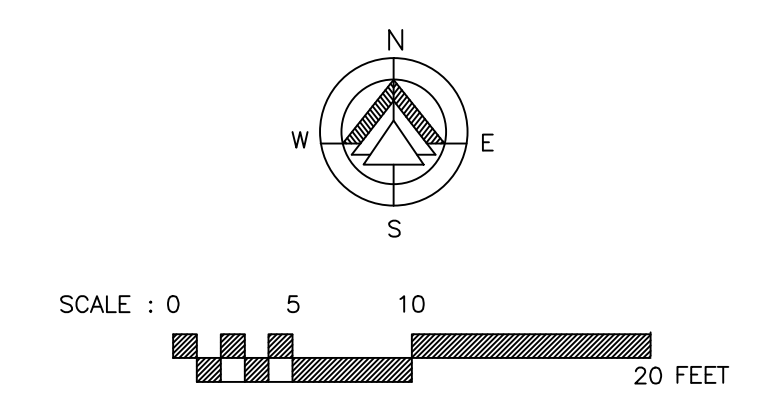
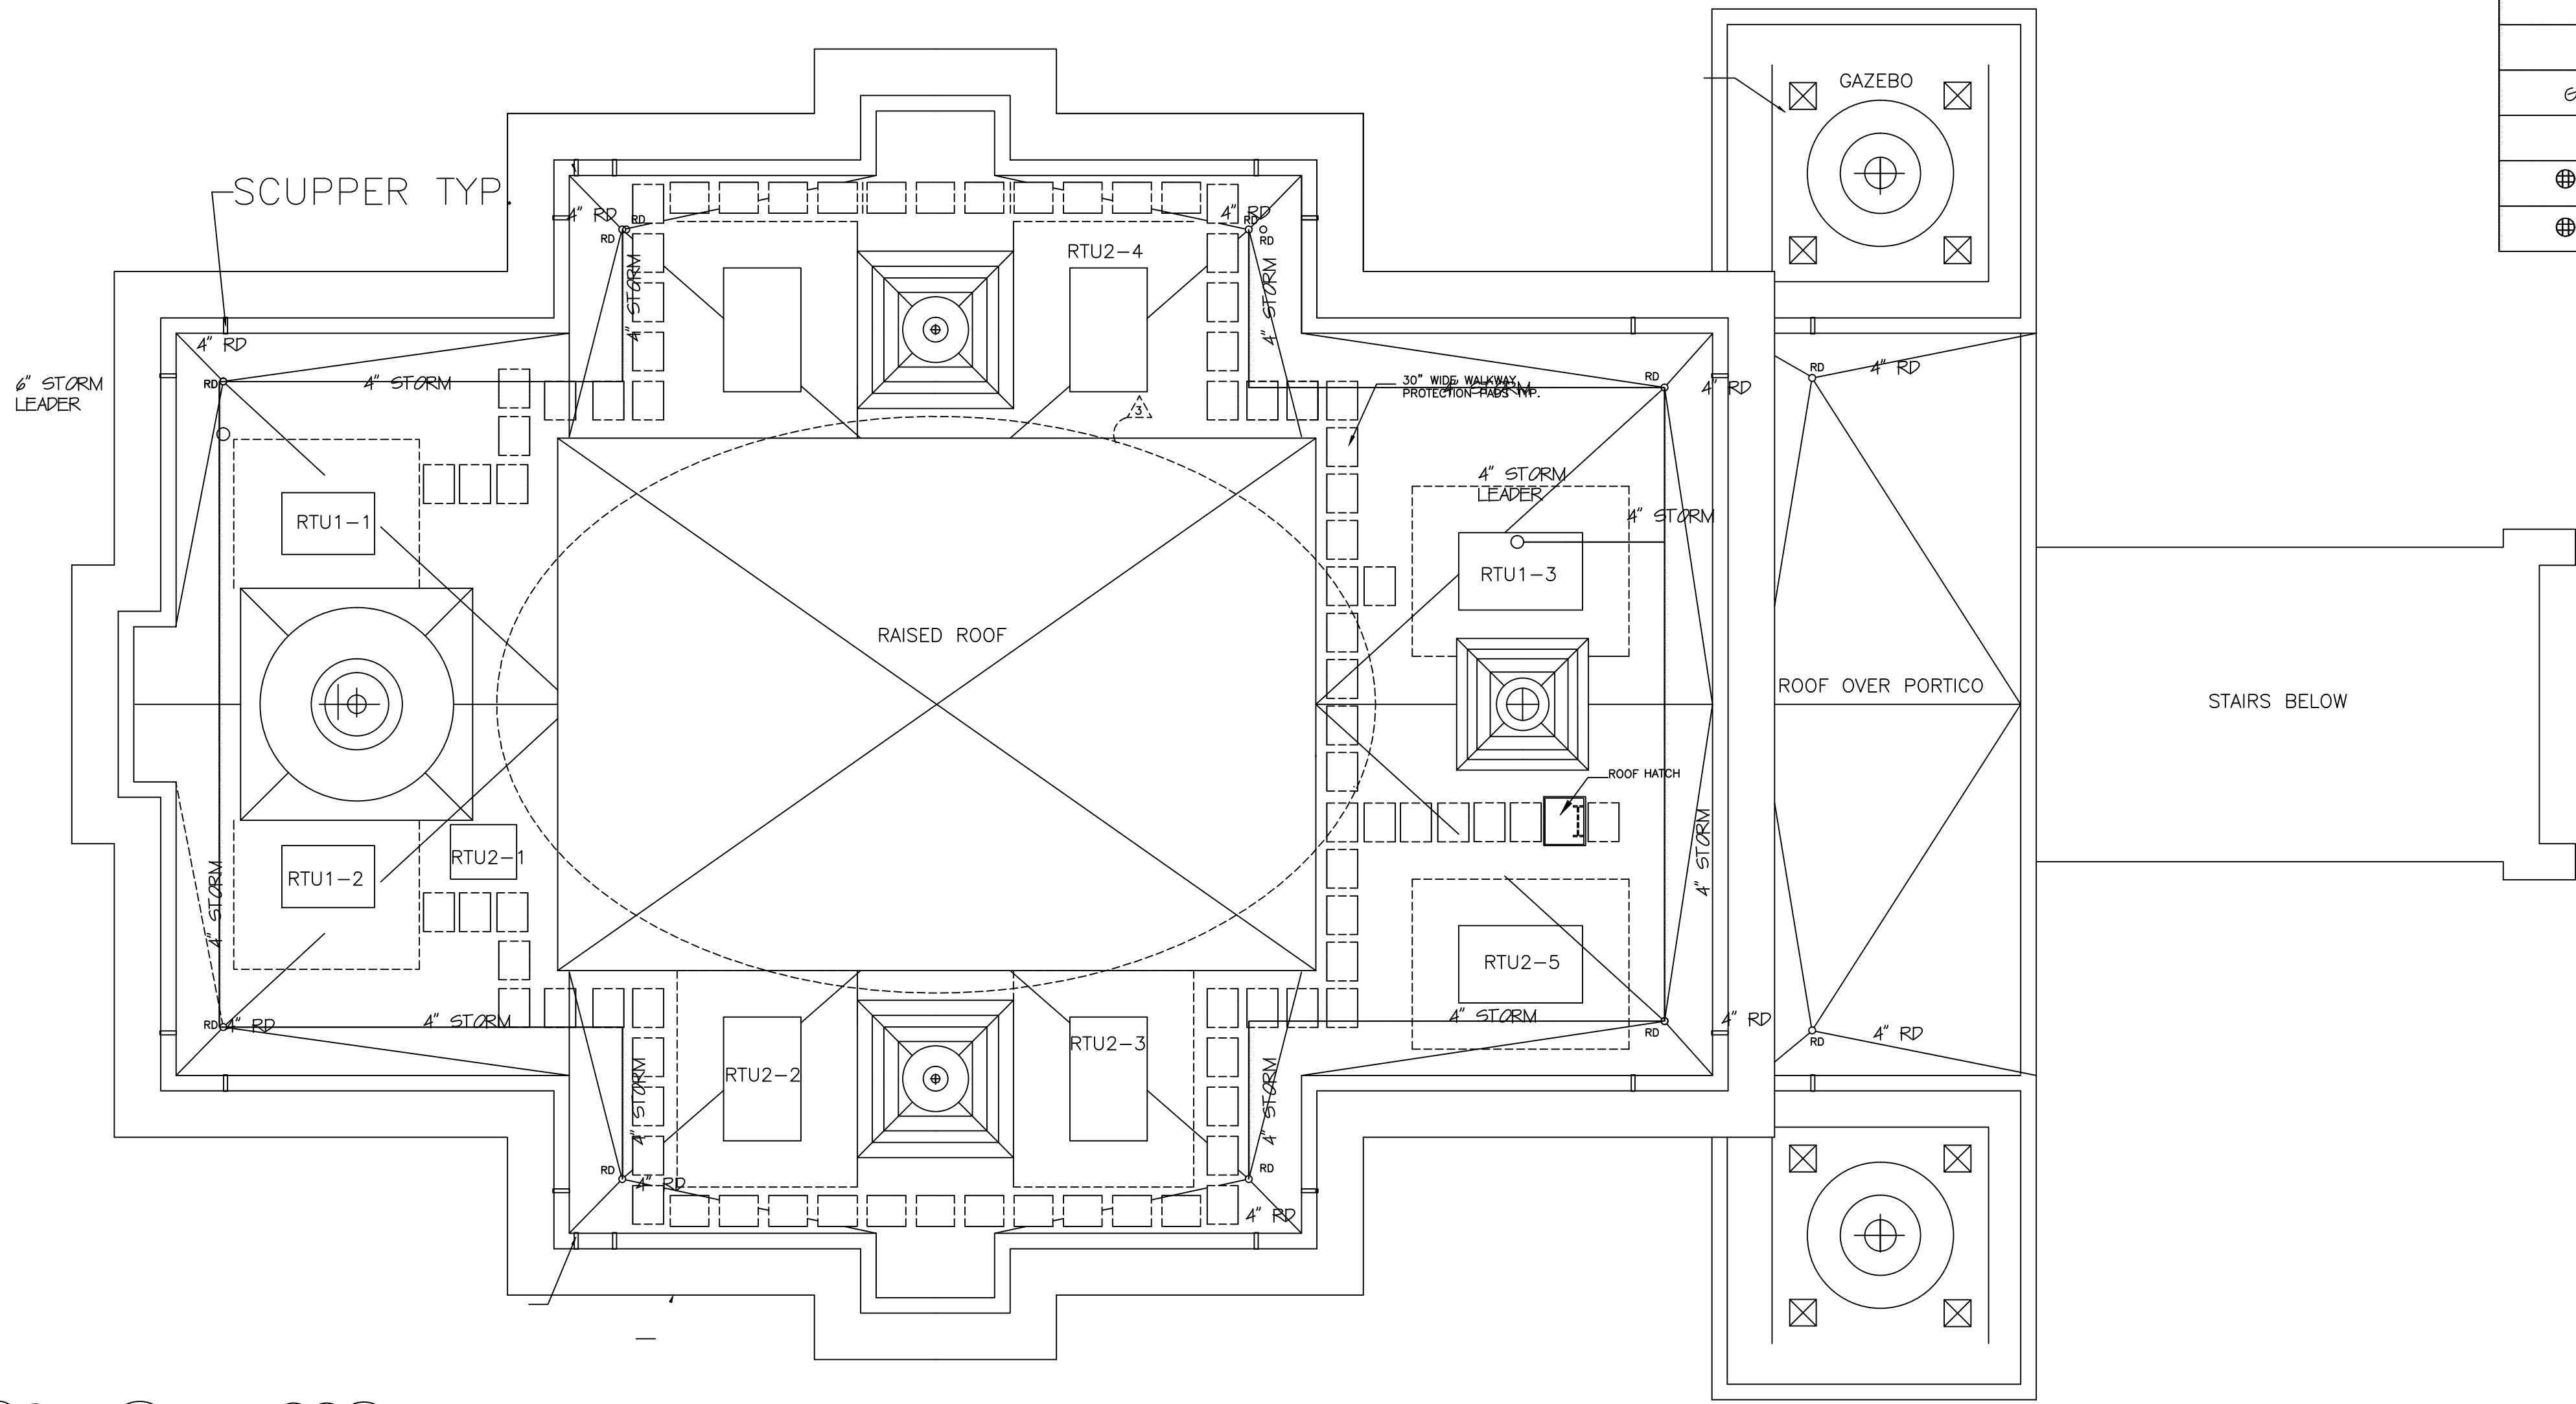
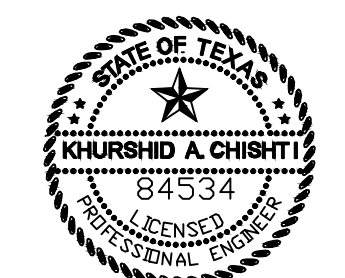


PLUMBING SYMBOLS			
—	SANITARY SEWER NEW	⊗	SHUT OFF VALVE
—	NEW SPRINKLER LINE	∅	GAS COCK
SPK	EXISTING SPRINKLER	∇	STOP & WASTE
⊙	EXISTING SPRINKLER HD.		UNION
⊗	NEW OR RELOC. SPR. HD.	⊗-HD	WATER HOSE DIP
	DIRECTION OF FLOW	⊗-FFD	FROST PROOF HOSE DIP
CW	COLD WATER LINE	⊗	CURB BOX
HW	HOT WATER LINE		SCHEMATIC VENT
G	GAS LINE		SCHEMATIC SANITARY
	CLEAN OUT		SCHEMATIC TRAP
⊕ ^{FD}	FLOOR DRAIN	M W G	METER /WATER/GAS
⊕ ^{SW}	SAFE WASTE W/ FUNNEL	⬇	CONNECTION TO EXISTING

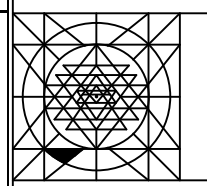

ROOF PLUMBING PLAN
SCALE: 1/8"=1'-0"


 CONSULTANT:
WAHEED CONSULTING
 MECHANICAL-ELECTRICAL-PLUMBING SYSTEM DESIGNERS
 Registration No. F-6336
 TEL: (817) 793 2010, FAX: (972) 442 4063
 420 PARKSIDE ST. MURPHY, TX, 75094
 E-mail: waheedmep@yahoo.com

rev	△ 08-26-2016	Revised as noted
rev	△ 11-05-15	City Comments
scale	AS NOTED	
drawn by	CADD-SPA	
 SHASHI D. PATEL AIA NCARB ARCHITECTS AND PLANNERS 442 EAST END AVE. STE-B. PITTSBURGH PA 15221		
ROOF PLUMBING PLAN AND DETAILS		
CONSTRUCTION DOCUMENT PHASE		
RADHA KRISHNA TEMPLE		
ALLEN TEXAS		