



ADDITIONS AND RENOVATIONS CHURCH OF THE HOLY SPIRIT

2871 BARNDT ROAD, HARLEYSVILLE, PA, 19438

BID SET - APRIL 12, 2021



OWNER

CHURCH OF THE HOLY SPIRIT
2871 BARNDT ROAD
HARLEYSVILLE, PA 19438
TEL. 215-519-6939

CONTACT: BEN GORTON
(BGORTONCOHS@GMAIL.COM)

ARCHITECTURAL

GODSHALL KANE O'ROURKE ARCHITECTS, LLC
300 BROOKSIDE AVE, AMBLER YARDS
BUILDING 18, SUITE 150, AMBLER, PA 19002
TEL. 215-646-2003 / WWW.GKOARCHITECTS.COM

CONTACT: MATTHEW JONES (MATTHEW@GKOARCHITECTS.COM)
P. MICHAEL O'ROURKE, AIA (MIKE@GKOARCHITECTS.COM)
AMY WALTER (AMY@GKOARCHITECTS.COM)

MEP

CONSOLIDATED ENGINEERS
1022 JAMES DRIVE
LEESPORT, PA 19533
TEL. 610-916-1600 / WWW.CONSOLIDATEDENGINEERS.COM

CONTACT: ADAM MOSER, PE (ADAMM@CEMEC.COM)
CHRISTOPHER VAN CAMPEN, PE
(CHRISV@CEMEC.COM)

CIVIL

HORIZON ENGINEERING
428 MAIN STREET
PENNSBURG, PA 18073
TEL. 267-923-8673

CONTACT: MARK SMITH
(MSMITH@HORIZONENGINEERS.COM)
ROBERT MILLER
(RMILLER@HORIZONENGINEERS.COM)

STRUCTURAL

GTA, INC. - STRUCTURAL ENGINEERS
5910 EASTON RD.
PIPERSVILLE, PA 18947
TEL. 215-766-3982

CONTACT: GARY TALBOT, PE
(GARY@GTA-ENGINEERS.COM)

COMMON SYMBOLS & ABBREVIATIONS LIST

& L @ ° Ø # ±	AND ANGLE AT CENTERLINE DEGREES DIAMETER NUMBER PLUS OR MINUS	EL ELECT ELEV. ENCL EQ. EQUIP EXG. EXIST. EXP. EXST. EXT. EXTR. E.W.C.	ELEVATION ELECTRICAL ELEVATION ENCLOSURE EQUAL EQUIPMENT EXISTING EXISTING EXPANSION EXISTING EXTERIOR ELECTRIC WATER COOLER	MANUF. MAS MATL. MAX MB MDF MECH. MEMB MET MFGR MFR MIN MIR. M.O. M.R. MTD. MTG MTL	MANUFACTURER MASONRY MATERIAL MAXIMUM MARKERBOARD MEDIUM DENSITY FIBERBOARD MECHANICAL MEMBRANE METAL MANUFACTURER MANUFACTURER MINIMUM MIRROR OR MIRRORED MASONRY OPENING MOISTURE RESISTANT MOUNTED MEETING METAL	QTY. QUAL. R (R) RAD RB RCP R.D. REC. REQD. RECTS RET RFG RLG RM RND R.O. R.S. RWL RWO	QUANTITY QUALITY RISER RELOCATED RADIUS RUBBER BASE REFLECTED CEILING PLAN ROOF DRAIN RECESSED REQUIRED REQUIREMENTS RETURN ROOFING RAILING ROOM ROUND ROUGH OPENING ROLLER SHADE RAIN WATER LEADER ROUGH WALL OPENING
(A) ABV ACM A.C.T. ADA ADJ A.F.F. AL ALT. ALUM. APP APPROX. ARCH ASB	ACTIVE LEAF IN PAIR OF DOORS ABOVE ASBESTOS CONTAINING MATERIAL ACOUSTIC CEILING TILE AMERICAN W/ DISABILITIES ACT ADJUSTABLE ABOVE FINISH FLOOR ALUMINUM ALTERNATE ALUMINUM APPROVED APPROXIMATELY ARCHITECT ASBESTOS CONTRACTOR	FAST FD FE# F.E. FEC# FIN FL FLR F.O. FT. F.T.	FASTENED FLOOR DRAIN FIRE EXTINGUISHER FINISHED END OF CASEWORK FIRE EXTINGUISHER CABINET FINISH FLASHING FLOOR FACE OF FEET FULL TILE	N NA N/A N.I.C. NO N.T.S.	NORTH NOT APPLICABLE NOT APPLICABLE NOT IN CONTRACT NUMBER NOT TO SCALE	S SB S.C. SDL SECT. SIM. SLP SLV SPEC. SPKLR SQ. S.S. ST. STD. STL STOR. STRUCT SW	SOUTH SPLASH BLOCK SOLID CORE SADDLE SECTION SIMILAR SLOPE SLEEVE SPECIFICATION SPRINKLER SQUARE STAINLESS STEEL STORAGE STANDARD STEEL STORAGE STRUCTURAL SLAT WALL
BK BLDG BLK BM BN B.O. BOT. BR B.U.	BLOCK CONTROL JOINT BUILDING BLOCK BEAM BULLNOSE BLOCK BOTTOM OF BOTTOM BRICK CONTROL JOINT BUILT-UP	GA. GALV. GC G.C. GEN. GL GR GWB GYP G.S.	GAUGE GALVANIZED GENERAL CONTRACTOR GENERAL CONTRACTOR GENERAL GLASS OR GLAZING GRADE GYPSUM WALL BOARD GRAVEL STOP	OA O.C. OD O.D. O.F. O.H. OPNG. OPP. ORIG. OSHA OZ	OVERALL ON CENTER OUTSIDE DIAMETER OUTSIDE DIMENSION OVERFLOW ROOF DRAIN OPENING OPPOSITE HAND OPENING OPPOSITE ORIGINAL OCCUPATIONAL SAFETY & HEALTH ADMINISTRATION OUNCE	PARTN. PC P.C. PERF. PERIM. PERM. PERP. PL P.LAM PLBG PLUMB PNL PNT POS PR PROJ. PT PTD PTN PNL PNT POS PR PROJ. PT PTD PTN	PARTITION PLUMBING CONTRACTOR PLUMBING CONTRACTOR PERFORATED PERIMETER PERMANENT PERPENDICULAR PLATE PLASTIC LAMINATE PLUMBING PLUMBING PANEL PAINT POINT OF SALE TERMINAL PAIR PROJECT PAINT PARTITION PARTITION
CB CFMC CFMF CH CHK CJ CLG CLOS CLR CMU COL CONC. CONF. CONST CONT. COORD. CORR. CT	CHALKBOARD COLD FORMED METAL CHANNEL COLD FORMED METAL FRAMING CHANNEL CHECK OR CHECKED CONTROL JOINT CEILING CLOSURE CLEAR CONCRETE MASONRY UNIT COLUMN CONCRETE CONFERENCE CONSTRUCTION CONTINUOUS COORDINATE CORRIDOR COUNTERTOP	H HC H.C. H.M. HORIZ. H.P. HR HT. INSUL. INT. INTR. INTERM. JAN. JB J.C. JT K KPL L LAM LAV. LB. LDG LNTL LOC L.P. LT LVR	HEIGHT HVAC CONTRACTOR HVAC CONTRACTOR HOLLOW METAL HORIZONTAL HIGH POINT HOUR HEIGHT INSULATION INTERIOR INTERIOR INTERMEDIATE JANITOR JUNCTION BOX JANITOR'S CLOSET JOINT KIP: 1000 LB KICK PLATE LENGTH LAMINATED LAVATORY POUND LANDING LINTEL LOCATION LOW POINT LIGHT LOUVER	PARTN. PC P.C. PERF. PERIM. PERM. PERP. PL P.LAM PLBG PLUMB PNL PNT POS PR PROJ. PT PTD PTN	PARTITION PLUMBING CONTRACTOR PLUMBING CONTRACTOR PERFORATED PERIMETER PERMANENT PERPENDICULAR PLATE PLASTIC LAMINATE PLUMBING PLUMBING PANEL PAINT POINT OF SALE TERMINAL PAIR PROJECT PAINT PARTITION PARTITION	UL U.N.O. VERT V.I.F. W W W WCJ WD. W.P. W.R. W.T.	UNDERWRITERS LABORATORY UNLESS NOTED OTHERWISE VERTICAL VERIFY IN FIELD WEST WIDTH WITH WALL CONTROL JOINT WOOD WORKING POINT WATER RESISTANT WINDOW TREATMENT
(E) EA EC E.C. EIFS EJ / E.J.	EAST EXISTING EACH ELECTRICAL CONTRACTOR ELECTRICAL CONTRACTOR EXTERIOR INSULATION & FINISH SYSTEM EXPANSION JOINT						

DRAWING INDEX:

CS COVER SHEET

CIVIL

0	COVER SHEET
1	LAND DEVELOPMENT PLAN
2	EXISTING FEATURES - DEMOLITION PLAN
3	STORM AND GRADING PLAN
4	CONSTRUCTION DETAILS - PCSWM
5	LANDSCAPE PLAN - PCSWM
6	LANDSCAPE DETAILS - PCSWM
7	LIGHTING PLAN
8	EROSION + SEDIMENT CONTROL PLAN
9	EROSION + SEDIMENT CONTROL DETAILS
10	POST CONSTRUCTION STORMWATER MANAGEMENT PLAN (A)
11	POST CONSTRUCTION STORMWATER MANAGEMENT PLAN (B)
12	POST CONSTRUCTION STORMWATER MANAGEMENT PLAN (C)

ARCHITECTURAL

A0.1	CODE PLAN
A0.2	ACCESSIBILITY PLAN
A2.1	FLOOR PLAN / MISC. DEMO. & RENOV.
A2.2	ROOF PLAN & REFLECTED CEILING PLAN
A2.3	DETAIL PLANS / DOOR & TOILET RM. SCHEDULES
A3.1	EXTERIOR ELEVATIONS & WINDOW SCHEDULE
A4.1	BUILDING SECTIONS
A4.2	WALL SECTIONS & DETAILS
A4.3	WALL SECTIONS & DETAILS
A4.4	WALL SECTIONS & DETAILS
A5.1	INTERIOR ELEVATIONS
A5.2	INTERIOR ELEVATIONS
A5.3	INTERIOR DETAILS
A7.1	INTERIOR FINISH PLAN & SCHEDULE
A8.1	DETAILS
A8.2	DETAILS
A9.1	SCHEMATIC RENDERINGS

STRUCTURAL

S-1.0	FOUNDATION PLAN
S-2.0	ROOF FRAMING PLAN
S-3.0	FOUNDATION SECTIONS AND DETAILS
S-3.1	FRAMING SECTIONS AND DETAILS

HVAC


H1.0	FLOOR PLAN HVAC
H2.0	LEGEND, DETAILS + SCHEDULES HVAC

PLUMBING

P1.0	FLOOR PLAN PLUMBING
P2.0	LEGENDS AND DETAILS - PLUMBING

ELECTRIC

E-0.1	SITE PLAN - ELECTRICAL
E-1.1	FLOOR PLANS - LIGHTING AND POWER
E-2.1	LIGHTING FIXTURE SCHEDULE AND DETAILS
E-2.2	SYMBOL LEGEND AND NOTES

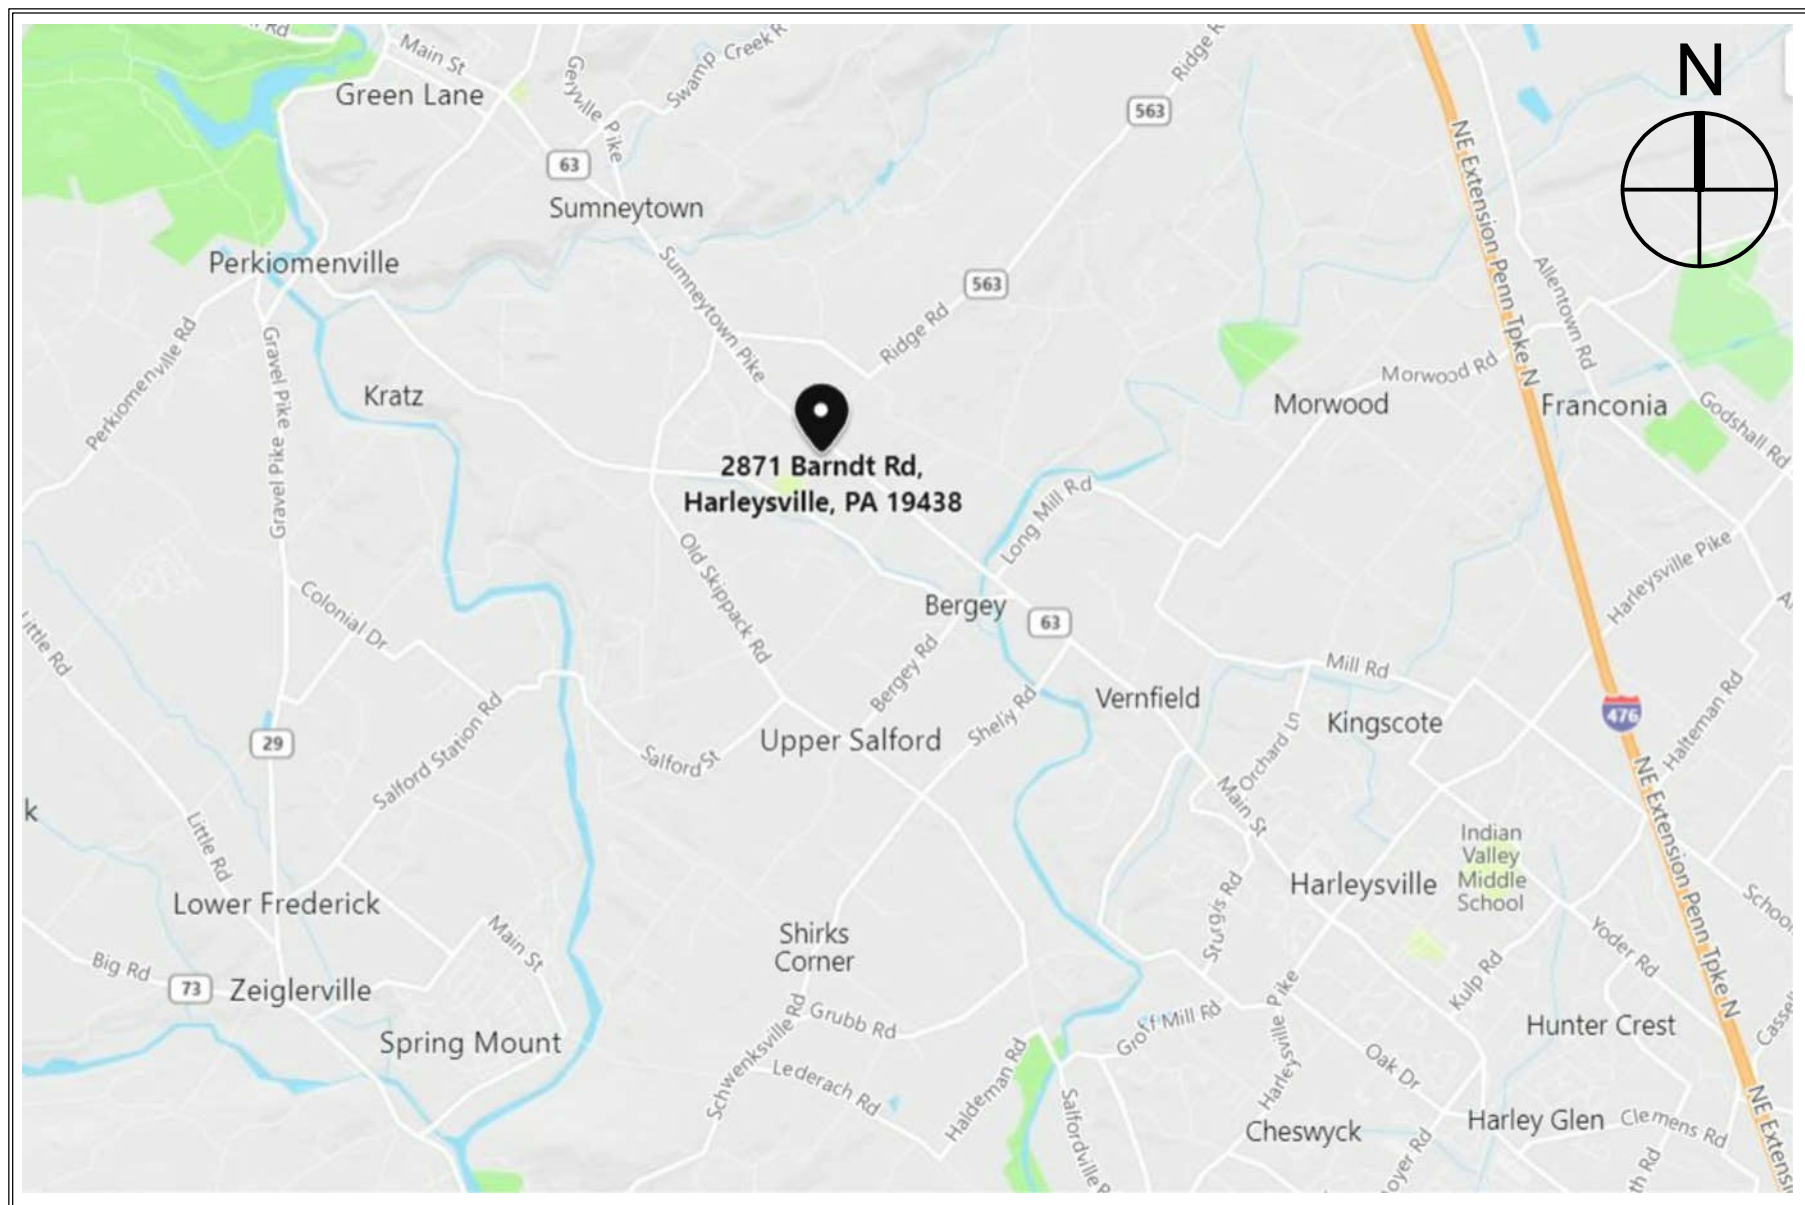

SITE LOCATION MAP

NO SCALE

BID SET - APRIL 12, 2021

ADDITIONS AND RENOVATIONS FOR

CHURCH OF THE
HOLY SPIRIT

2871 BARNDT ROAD, HARLEYSVILLE, PA, 19438

COVER
SHEET

CS

SCALE	AS NOTED
DATE	4-12-2021

STAMP

CONSULTANTS

GODSHALL KANE O'ROURKE ARCHITECTS, LLC
300 Brookside Avenue
Building 18 - Suite 150
Ambler, PA 19002
T: 215-646-2003 F: 215-646-5707 W: gkoarchitects.com



NOTE: ALL THIS OPENING MUST REMAIN IN USE FOR THE DURATION OF CONSTRUCTION. ACCESS MUST BE MAINTAINED TO THE TOILET ROOMS AND BY BLOCKING THIS OPENING A DEAD END CORRIDOR IS CREATED. IN ADDITION TO KEEPING THIS AN ACTIVE OPENING THE CONTRACTOR MUST ALSO ALWAYS MAINTAIN A CLEAR PATH THROUGH THE WORK AREA AND DISCHARGE SAFELY ONTO GRADE. EXTERIOR GRADING MUST ALSO BE MAINTAINED AS A SAFE WALKING SURFACE. CONTRACTOR SHALL INCLUDE WOODEN STRUCTURES AS REQUIRED TO CROSS TRENCHES AND OTHER OPENINGS.

34' / .2 = 170
ALLOWED

REPLACE EXISTING WINDOW WITH NEW HM FRAME AND 1 HOUR RATED LAMINATED INSULATED GLASS. WINDOW TO BE NON OPERATIONAL. PATCH EXTERIOR SIDING AND TRIMS AND INTERIOR MILLWORK TRIMS RESULTING FROM DEMOLITION

34' / .2 = 170
ALLOWED

UL 300 HAS AN ADDITIONAL LAYER OF GWS. EXTEND TO FIRST CORNER THEN TRANSITION TO TYPICAL WALL. SAME OTHER SIDE

CODE STUDY:

CODE: 2015 IBC, NO AMENDMENTS (NEED TO CONFIRM*)
2015 INTERNATIONAL EXISTING BUILDING CODE

USE GROUP - MIXED NON SEPARATED
EXISTING BUILDING:
A-3 ASSEMBLY
B-1 BUSINESS
S-1 STORAGE

NEW BUILDING:
A-3 ASSEMBLY

CONSTRUCTION TYPE:
EXISTING BUILDING: 3B
NEW BUILDING: 5B
WOOD TRUSS ROOF FRAMING WILL HAVE DRAFT STOPPING TO LIMIT CEILING AREA TO NOT MORE THAN 3,000 SF.

EXISTING BUILDING IS NOT EQUIPPED WITH A FIRE SUPPRESSION SYSTEM.
NEW BUILDING WILL NOT BE EQUIPPED WITH A FIRE SUPPRESSION SYSTEM.

PROJECT IS AN ADDITION WITH MINOR RENOVATIONS TO THE EXISTING BUILDING AND AS SUCH, ONLY NEW CONSTRUCTION IS REQUIRED TO CONFORM TO IBC 2015. EXISTING CONDITIONS IN AREAS OF THE BUILDING WHICH ARE NOT SCHEDULED TO RECEIVE IMPROVEMENTS ARE NOT REQUIRED TO COMPLY WITH IBC UNLESS CONDITIONS ARE DEEMED UNSAFE BY THE AUTHORITY HAVING JURISDICTION.

ALLOWABLE HEIGHT:
EXISTING BUILDING 3B - 55' ALLOWED / 38'-0" EXISTING
NEW BUILDING 5B - 40' ALLOWED / 28'-0" PROPOSED

ALLOWABLE AREA - 23,000 + 17,250 = 40,250 > 25,672 EXISTING
EXISTING BUILDING 3B - 9,500 SF ALLOWED / 8,585 SF EXISTING
NEW BUILDING 5B - 6,000 SF ALLOWED / 5,187 SF PROPOSED

508.2.4 SEPARATION OF OCCUPANCIES
NO SEPARATION IS REQUIRED BETWEEN ACCESSORY AND THE MAIN OCCUPANCY

SECTION 706 - FIRE WALLS
THE PROJECT IS DESIGNED TO INCLUDE A NEWLY CONSTRUCTED FIRE WALL THAT WILL SEPARATE THE EXISTING BUILDING FROM THE NEW BUILDING AS TWO SEPARATE BUILDINGS.

706.4 - ASSEMBLY GROUP A - MINIMUM FIRE RESISTANCE RATING - 3 HOURS

EXCEPTION a - IN TYPE 2 OR 5 CONSTRUCTION, WALLS SHALL BE PERMITTED TO HAVE A 2 HOUR FIRE RESISTANCE RATING.

2 HOUR RATED FIRE WALL - 8" SOLID FILLED CMU

706.5 - HORIZONTAL CONTINUITY

EXCEPTION 1 - FIRE WALL MAY TERMINATE AT THE INTERIOR FACE OF COMBUSTIBLE SHEATHING PROVIDED THE EXTERIOR WALL HAS A 1 HR FIRE RATING FOR A MIN. OF 4'-0"

706.5.1 - EXTERIOR WALLS

CONDITION 1 - EXTERIOR WALLS SHALL HAVE A 1 HR RATING WITH 1/2 HR OPENING PROTECTION WHERE REQUIRED BY 705.8

1 HOUR RATED EXTERIOR WALL - UL U305

706.6 - VERTICAL CONTINUITY

EXCEPTION a - TYPE 5 CONSTRUCTION MAY TERMINATE AT THE UNDERSIDE OF COMBUSTIBLE SHEATHING PROVIDED:

4.1 - NO ROOF OPENING WITHIN 5'-0" OF THE FIRE WALL
4.2 - A CLASS B ROOF COVERING IS PROVIDED
4.3 - ROOF SHEATHING IS FIRE RETARDANT TREATED PLYWOOD FOR A DISTANCE OF 4'-0" FROM THE FIRE WALL.

1004.1.2 OCCUPANT LOADS

EXISTING BUILDING - 638 OCCUPANTS
NEW BUILDING - 318 OCCUPANTS
TOTAL FACILITY - 957 OCCUPANTS

1005.3.2 SIZING OTHER EGRESS COMPONENTS - DISCHARGE EXIT WIDTHS
EXISTING BUILDING - 662 OCCUPANTS X .2 = 132.4" REQUIRED
EXISTING BUILDING - 208" EXISTING

NEW BUILDING - 214 OCCUPANTS X .2 = 42.8" REQUIRED
NEW BUILDING - 138" PROPOSED

1017.2 EXIT ACCESS TRAVEL DISTANCE WITHOUT SPRINKLER SYSTEM SHALL NOT EXCEED 200'
EXISTING BUILDING - 114' EXISTING
NEW BUILDING - 99" PROPOSED

PLUMBING FIXTURE CALCULATION
TOILETS + URINALS
MEN - 479 OCC. / 150 = 4 REQUIRED / 5 EXISTING + NEW
WOMEN - 479 OCC. / 75 = 7 REQUIRED / 7 EXISTING + NEW

LAVATORIES
MEN - 479 OCC. / 200 = 3 REQUIRED / 3 EXISTING + NEW
WOMEN - 479 OCC. / 200 = 3 REQUIRED / 5 EXISTING + NEW

DRINKING FOUNTAINS
957 OCC. / 1000 = 1 REQUIRED / 1 EXISTING

SERVICE SINKS
1 REQUIRED / 1 EXISTING

1 CODE PLAN
A0.1 SCALE: 1/8" = 1'-0"

BID SET - APRIL 12, 2021

ADDITIONS AND RENOVATIONS FOR CHURCH OF THE HOLY SPIRIT

2871 BARNDT ROAD, HARLEYSVILLE, PA, 19438

REVISIONS	

4-12-2021	BID SET
-----------	---------

DRAWN BY	PMO
REVIEWED BY	2416
JOB #	

SHEET TITLE	
-------------	--

SCALE	AS NOTED
DATE	4-12-2021

A0.1


GODSHALL KANE O'ROURKE ARCHITECTS, LLC
300 Brookside Avenue
Harleysville, PA 19438
Amherst, PA 18802
T: 215.646.2003 F: 215.646.5707 W: gkarchitects.com




STAMP

CONSULTANTS


* THE ADA ANSI ICC A117.1-2009 ACCEPTED MOUNTING RANGE IS BEING GIVEN IN THE TABLE FOR REFERENCE ONLY. CONTRACTORS SHALL INSTALL ADA FIXTURES AND/OR ELEMENTS IN ACCORDANCE WITH THE SINGLE DIMENSION GIVEN IN THE PRIORITY ADA MOUNTING HEIGHT COLUMN.

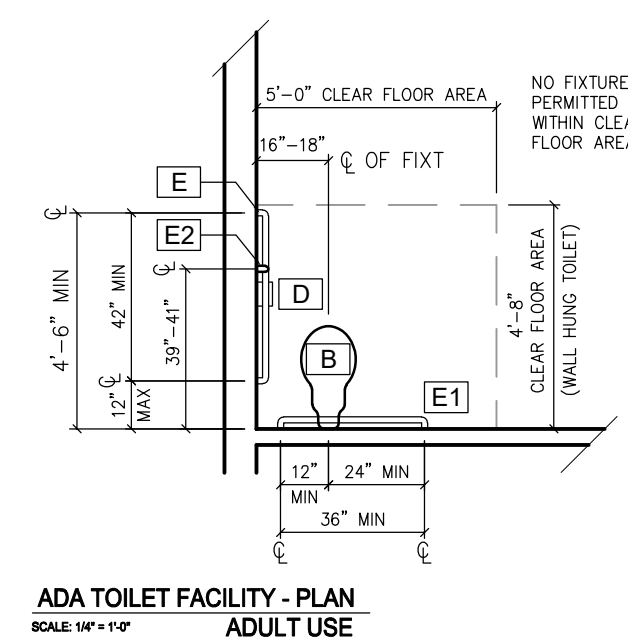

- TYPICAL ACCESSIBLE TOILET ROOM PLUMBING FIXTURES & ELEMENTS
A SCALE: 1/4" = 1'-0" / ADULT HEIGHT

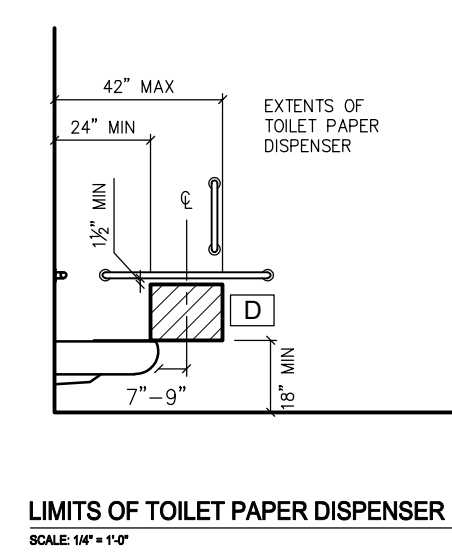


LIMITS OF TOILET PAPER DISPENSER

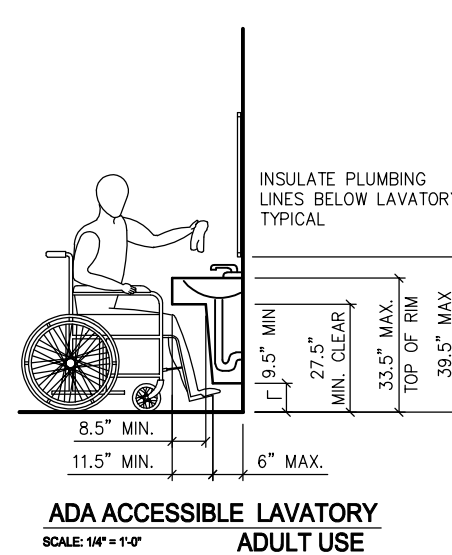

ADA ACCESSIBLE LAVATORY
SCALE: 1/4" = 1'-0"
ADULT USE



TYPICAL ROOM SIGN MOUNTING
SCALE: 1/4" = 1'-0"

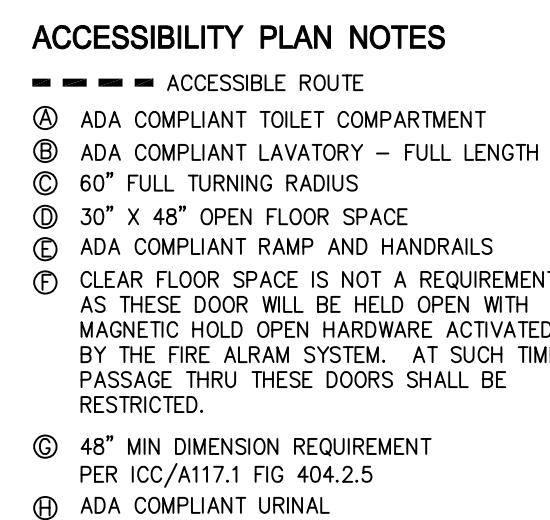

MANEUVERING CLEARANCE AT MANUAL SWINGING DOORS

DOOR SCHEDULE


DR. NO.	ROOM NAME	DOOR				FRAME				GLASS TYPE	RATING MIN.	PANC.	CLOSER	SIGN TYPE	JAMB TYPE	REMARKS
		W	H	THK.	TYPE	MAT'L	FINISH	TYPE	MAT'L	FINISH						
200	TRANSITION FOYER	(2) 3'-2 5/8"	7'-0"	1 3/4"	I	HM	PT	2	H.M.	PT		90	X	X	4	2/A&1
200A	TRANSITION FOYER	3'-0"	7'-0"	1 3/4"	I	HM	PT	2	H.M.	PT		60	X	X	1	1/A&1
201	MEN	3'-0"	7'-0"	1 3/4"	I	WD	STAIN	2	H.M.	PT				X	2	II
202	WOMEN	3'-0"	7'-0"	1 3/4"	I	WD	STAIN	2	H.M.	PT				X	3	II
203	STORAGE	(2) 3'-0"	7'-0"	1 3/4"	I	WD	STAIN	2	H.M.	PT						
204	KITCHEN	3'-0"	7'-0"	1 3/4"	III	WD	STAIN	2	H.M.	PT			X			
205A	FELLOWSHIP	3'-0"	7'-0"	1 3/4"	II	ALUM	ANOD	3	ALUM	ANOD	G-2		X	X		
205B	FELLOWSHIP	3'-0"	7'-10"	1 3/4"	II	WD	STAIN	5	H.M.	PT	G-1					4"H.M. JAMB HINGE SIDE
205C	FELLOWSHIP	3'-0"	7'-10"	1 3/4"	II	WD	STAIN	5	H.M.	PT	G-1					4"H.M. JAMB HINGE SIDE
207A	CLASSROOM	3'-0"	7'-0"	1 3/4"	III	WD	STAIN	2	H.M.	PT	G-1					
207B	CLASSROOM	(2) 3'-0"	7'-0"	1 3/4"	III	WD	STAIN	2	H.M.	PT	G-1					
208	MEETING ROOM	3'-0"	7'-0"	1 3/4"	III	WD	STAIN	2	H.M.	PT	G-1					
209	MEETING ROOM	3'-0"	7'-0"	1 3/4"	III	WD	STAIN	2	H.M.	PT	G-1					
210A	VESTIBULE	(2) 3'-0"	7'-0"	1 3/4"	II	WD	STAIN	4	H.M.	PT	G-1			X	1	
210B	VESTIBULE	(2) 3'-0"	7'-0"	1 3/4"	II	ALUM	ANOD	4	ALUM	ANOD	G-2		X	X	1	

ABBREVIATIONS:
ALUM = ALUMINUM
G = GLASS
H.M./HM = HOLLOW METAL
SWF = SECURITY WINDOW FILM
WD = WOOD



NOTES:
CONTRACTOR TO VERIFY CORRIDOR WIDTH PRIOR TO RELEASING DOORS.

INTERIOR GLAZING:
G-1 - 1/4" CLEAR TEMPERED
G-2 - 1" INSULATED CLEAR TEMPERED
G-3 - 1/4" ACID ETCHED (TRANSLUCENT)

HARDWARE NOTES:

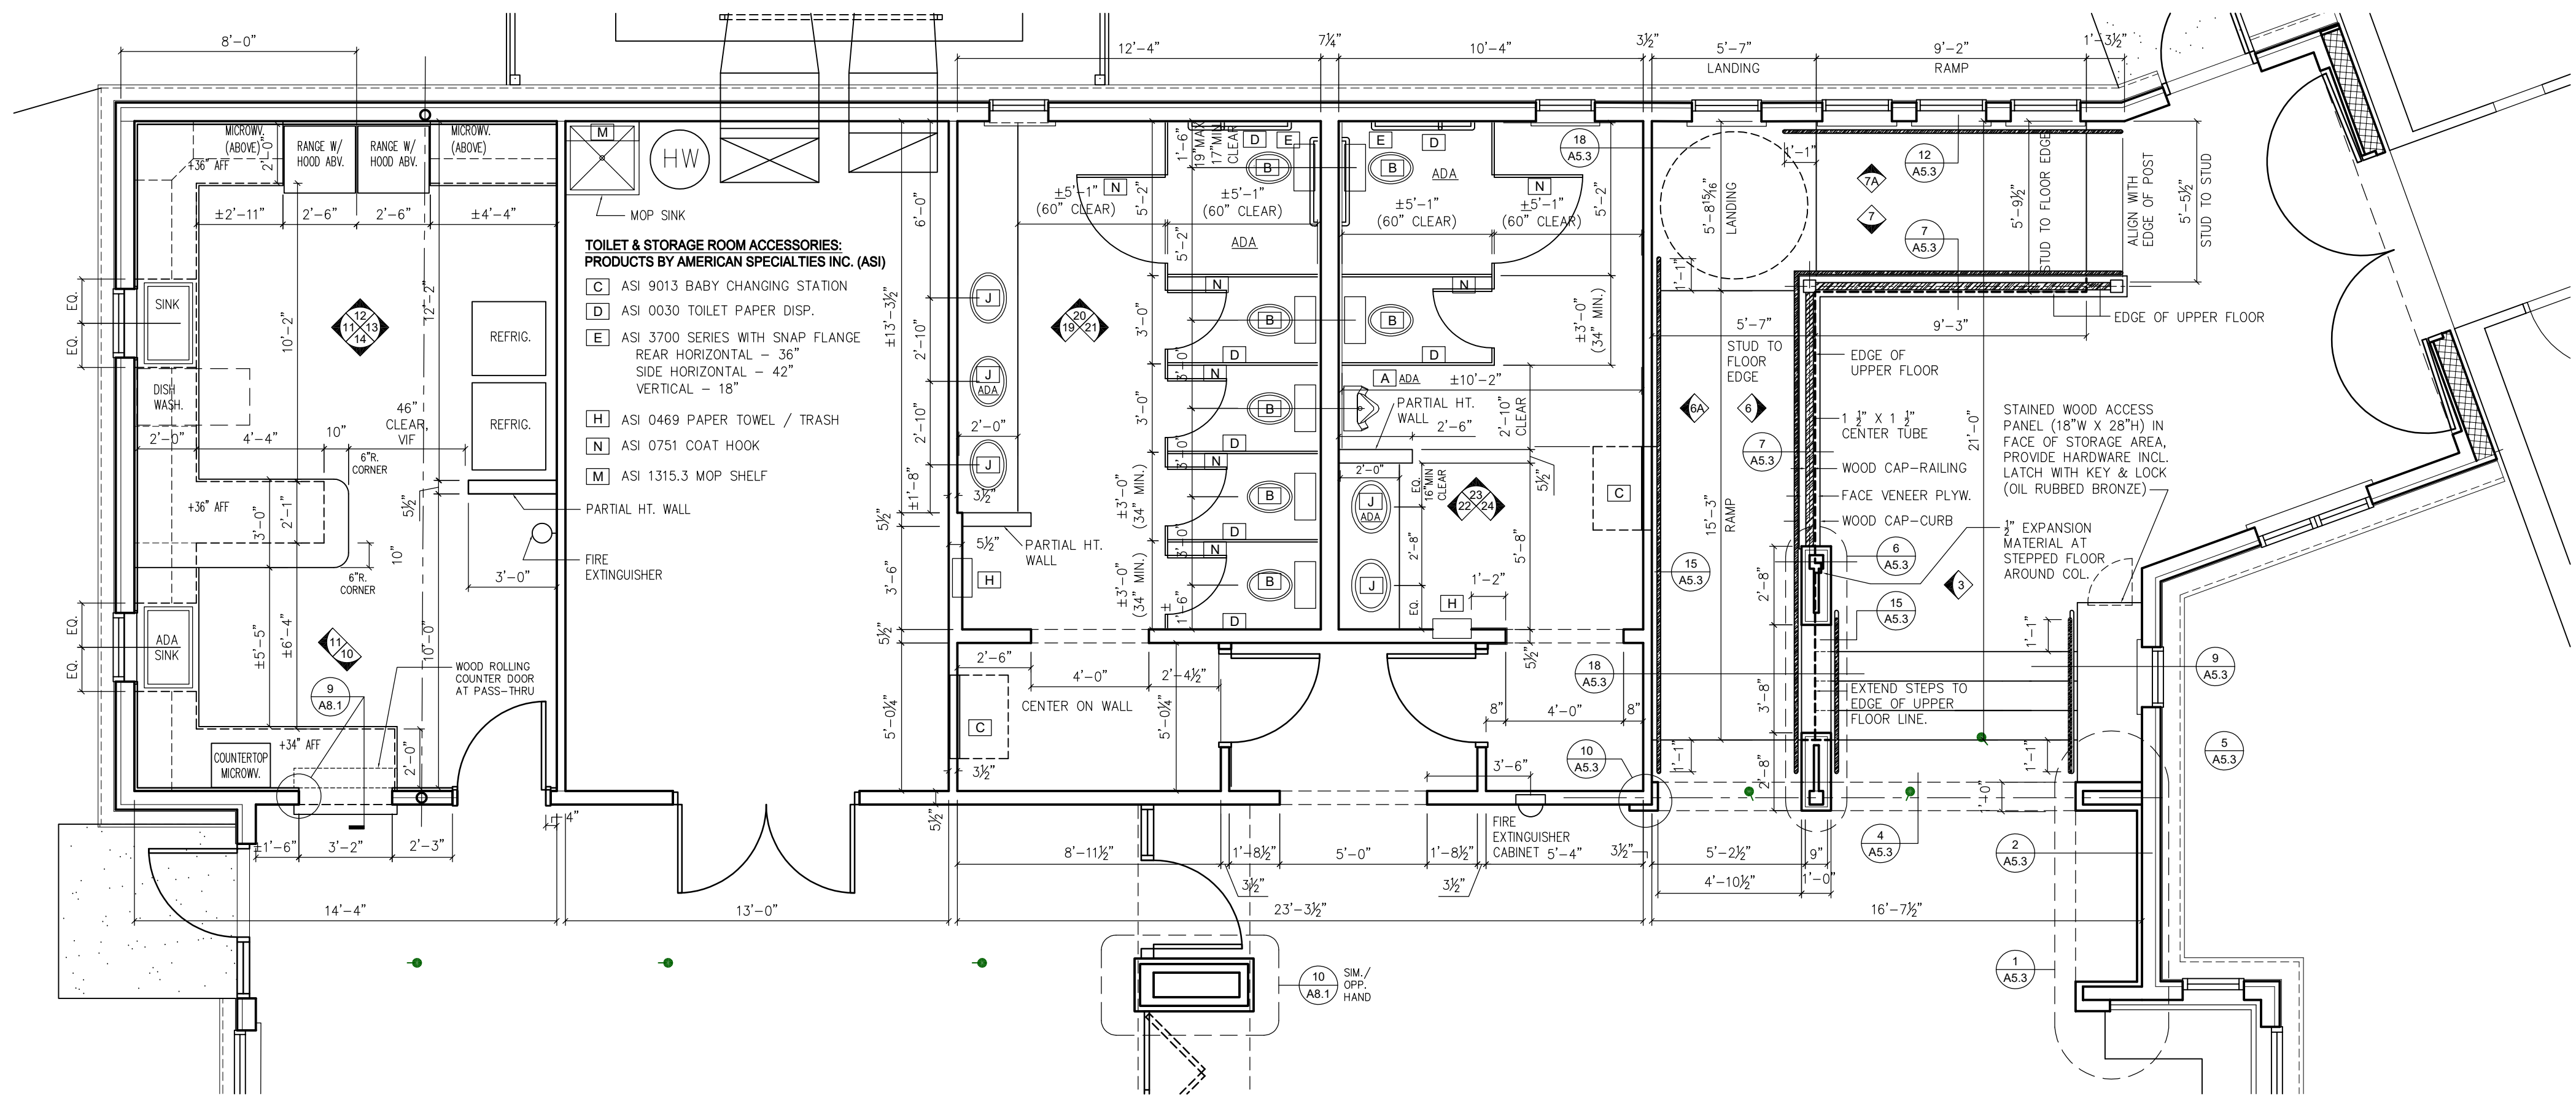


1 DETAIL PLAN @ KITCHEN, TOILET ROOM & STAIR/RAMP AREA
SCALE: 1/4" = 1'-0"

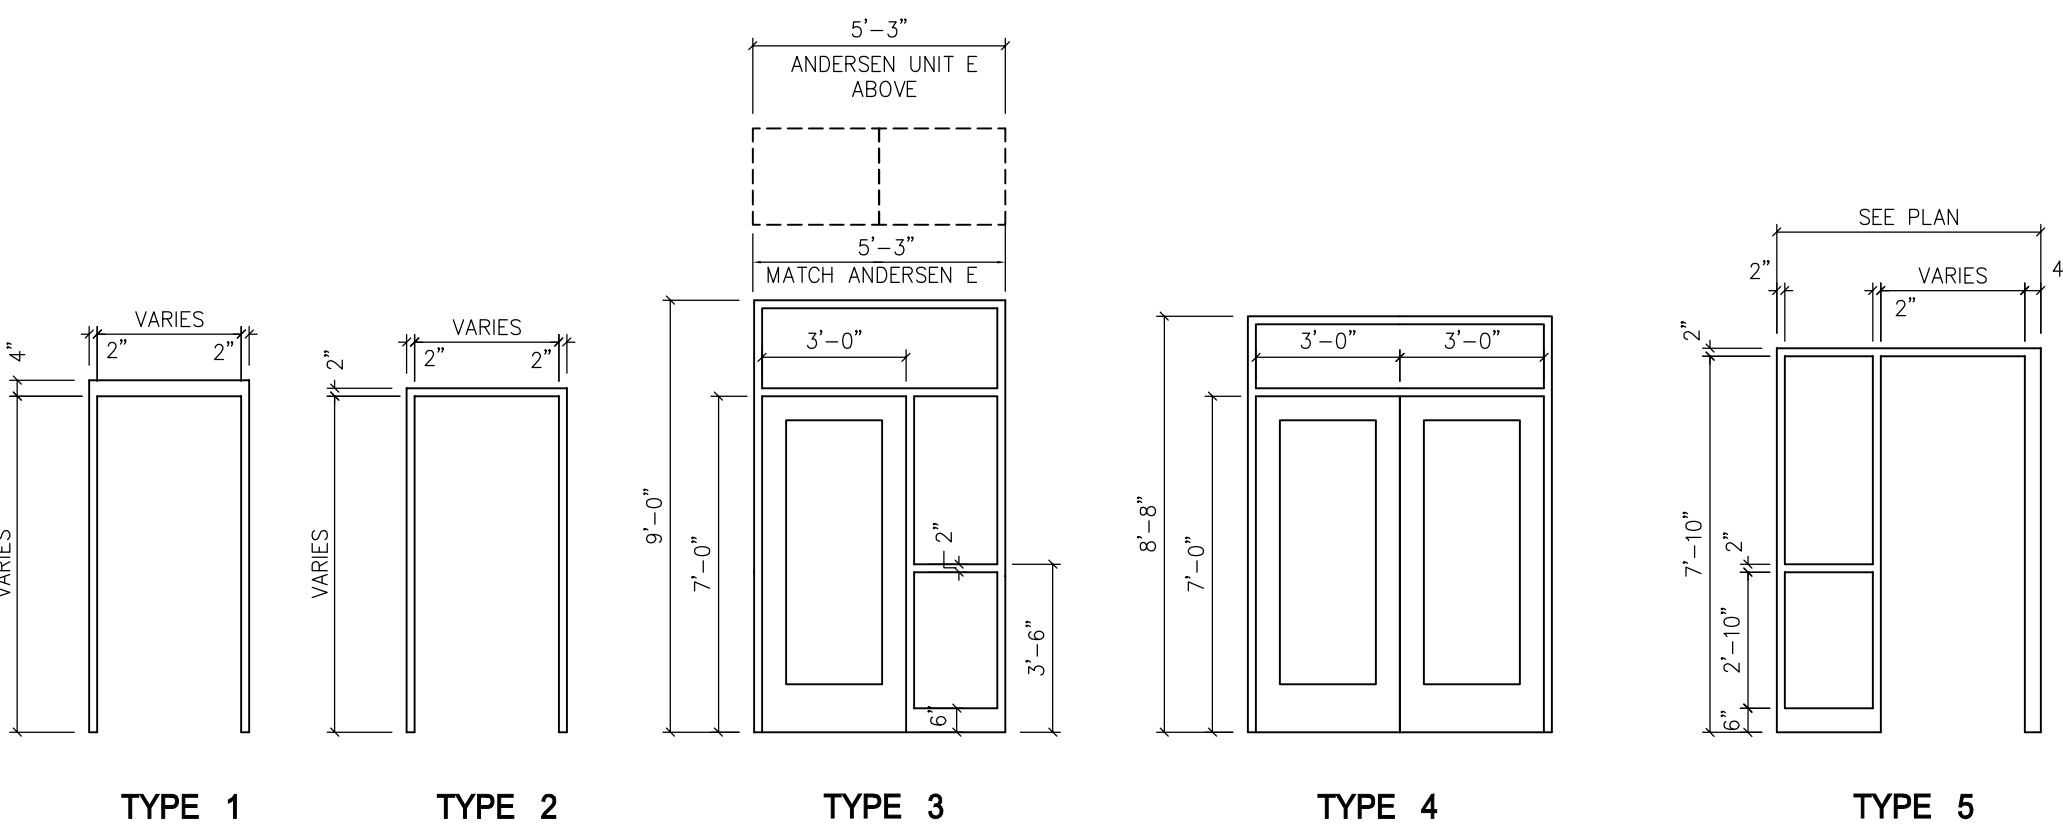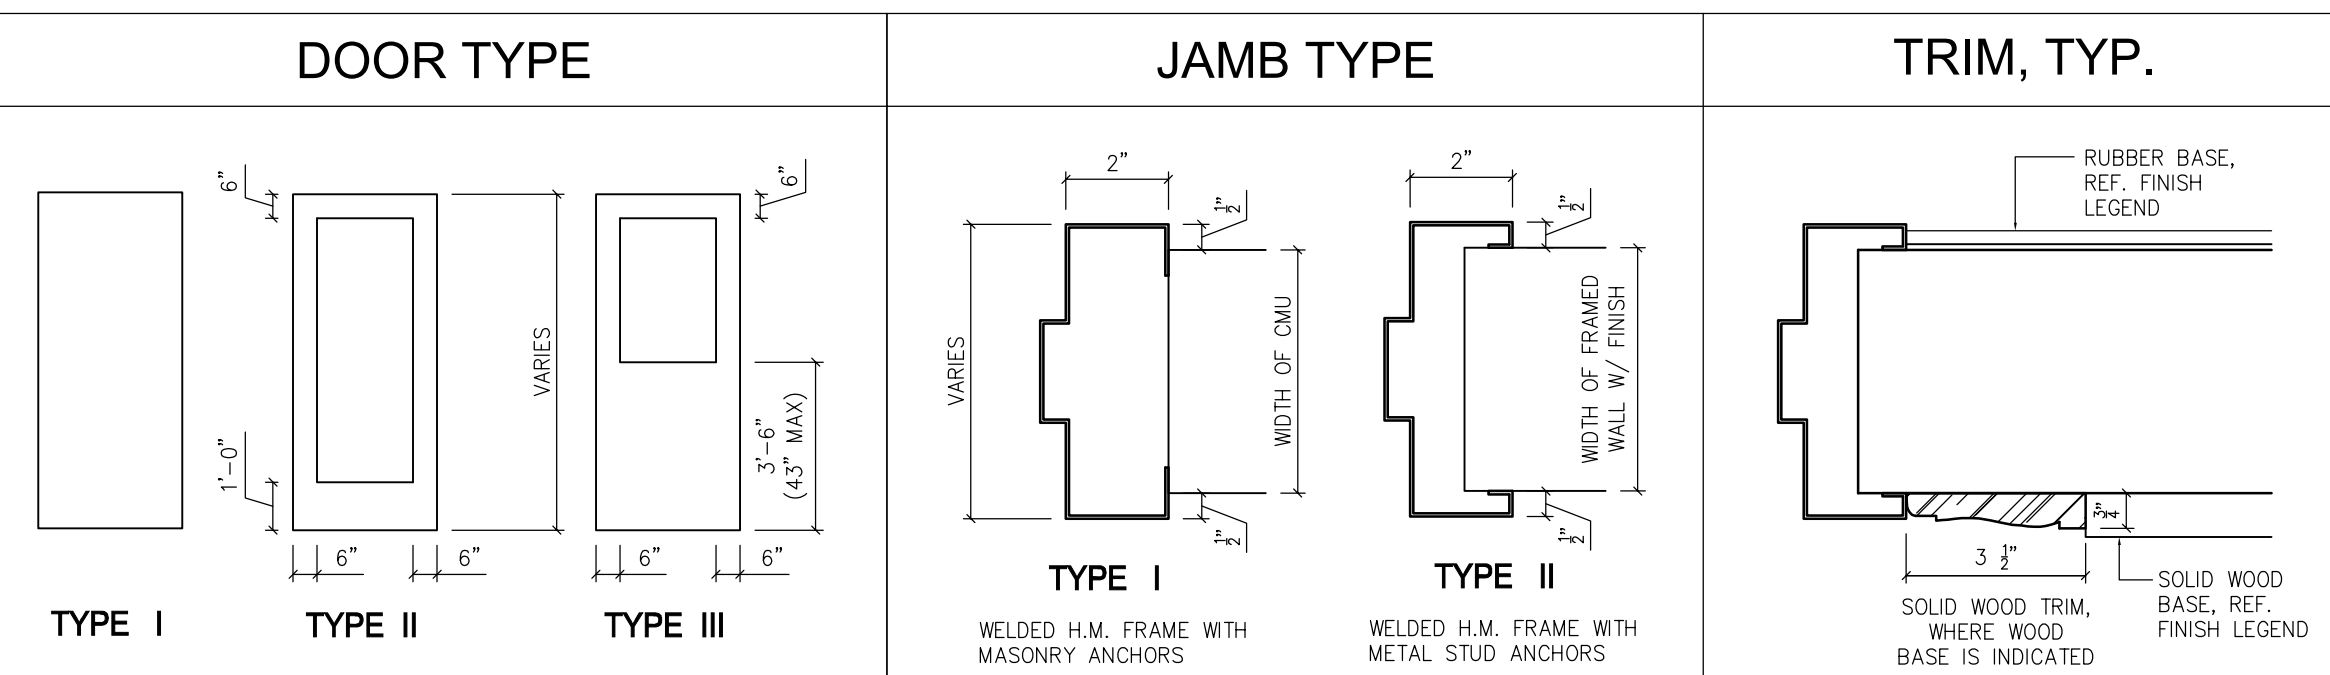


ICC A117.1 - 2009 PLUMBING ELEMENTS AND FACILITIES					
DESCRIPTION	ADULT USE - ABOVE FINISHED FLOOR			CHILD USE - ADA (PRE-K - 3RD GR)	
	STANDARD DIMENSION (INCHES)	PRIORITY ADA MOUNTING HT. * (SUFFIX: G)	ACCEPTED ADA DIM. RANGE * (SUFFIX: G)	PRIORITY ADA MOUNTING HT. * (SUFFIX: G)	ACCEPTED ADA DIM. RANGE * (SUFFIX: G)
A URINAL (WALL HUNG RM HEIGHT)	22"	16.5"	17" MAX.	15"	17" MAX.
B WATER CLOSET (WALL HUNG SEAT HEIGHT)	16"	18"	17"-19"	15"	11"-17"
C BABY CHANGING STATION		32" TO OPENED SURFACE			
D TOILET PAPER DISPENSER (SURFACE MTD. - OUTLET HEIGHT)	20"	24"	18"-33"	16"	14"-19"
E DRAB BARS					
F HORIZONTAL SIDE	-	35"	33"-36"	26"	18"-27"
G HORIZONTAL REAR	-	35"	33"-36"	26"	18"-27"
H VERTICAL BAR	-	40"	39"-41"	29"	21"-30"
I2 FEMININE PRODUCT DISPOSAL (WALL MTD. - HEIGHT TO TOP)	30"	40"	34"-48"	-	-
F3 FEMININE PRODUCT DISPOSAL (PARTITION MTD. - HEIGHT TO TOP)	30"	40"	34"-48"	-	-
G NOT USED					
G1 NOT USED					
H PAPER TOWEL DISP. + WASTE RECEPT. (RECESS/PROJECTED - HEIGHT TO DISPENSER OR OPERATOR)	54"-60"	44"	34"-48"	44"	34"-48"
J LAVATORY (HEIGHT TO TOP OF RM)	-	33.5"	34" MAX.	33.5"	34" MAX.
K LAVATORY (HEIGHT TO UNDERSIDE OF RM FOR KNEE CLEARANCE)	-	27.5"	27" MIN.	27.5"	27" MIN.
L MIRROR (BOTTOM OF REFLECTIVE SURFACE) SEE NOTE **	40"	39.5"	40" MAX.	39.5"	40" MAX.
N GARMENT HOOK (HEIGHT) SEE NOTE ***	48"	44"	34"-48"	44"	34"-48"
O ELECTRIC WATER COOLER (HEIGHT TO SPOUT)	38"-43"	34.5"	-	-	-
P FIRE ALARM PULL STATION (HEIGHT TO PULL MECHANISM)	-	47.5"	48" MAX.	-	-
Q FIRE EXTINGUISHER CABINET (HEIGHT TO DOOR HANDLE OR EXTINGUISHER GRIP - WHICHEVER HIGHER)	-	47.5"	48" MAX.	-	-

* THE ADA ANS ICC A117.1-2009 ACCEPTED MOUNTING RANGE IS BEING GIVEN IN THE TABLE FOR REFERENCE ONLY. CONTRACTORS SHALL INSTALL ADA FIXTURES AND/OR ELEMENTS IN ACCORDANCE WITH THE SINGLE DIMENSION GIVEN IN THE PRIORITY ADA MOUNTING HEIGHT COLUMN.

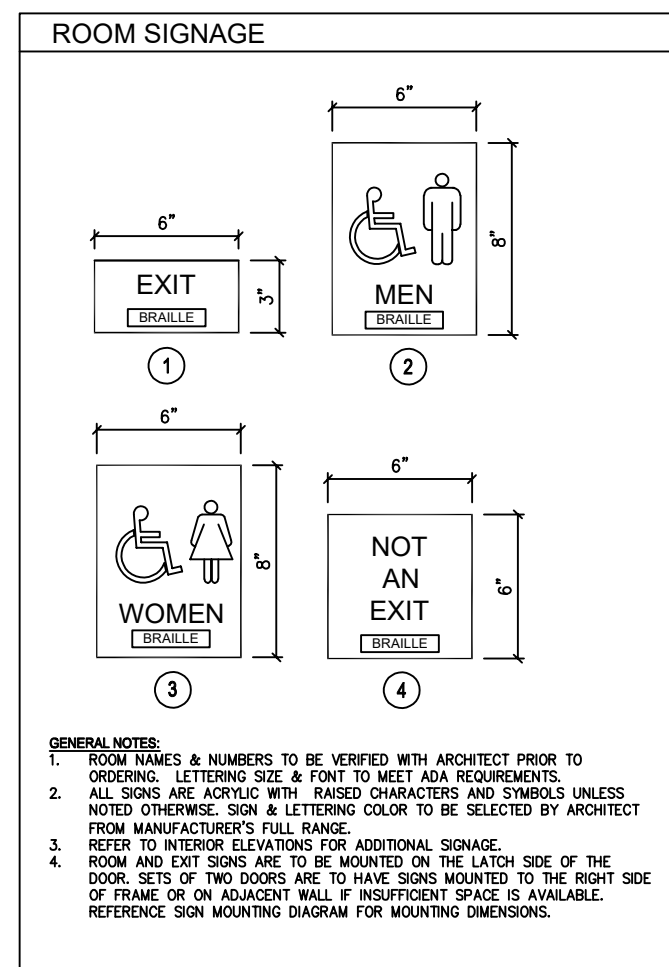


GENERAL NOTES:
1. ROOM NAMES & NUMBERS TO BE VERIFIED WITH ARCHITECT PRIOR TO ORDERING.
2. ALL SIGNS ARE TO BE ADAPTED TO THE WALL AND MOUNTING HEIGHT.
3. NOTES: ORANGE, RED & YELLOW COLOR TO BE SELECTED BY ARCHITECT FROM MANUFACTURER'S FULL RANGE.
4. NOTES TO ARCHITECT: SIGNAGE IS TO BE MOUNTED ON THE LEFT SIDE OF THE DOOR. SETS OF TWO SIGNS ARE TO HAVE SIGNS MOUNTED TO THE RIGHT SIDE OF FRAME OR ON ADJACENT WALL IF INSUFFICIENT SPACE IS AVAILABLE. REFERENCE SIGN MOUNTING DIAGRAM FOR MOUNTING DIMENSIONS.


19 WOMEN TOILET
SCALE: 1/4" = 1'-0"

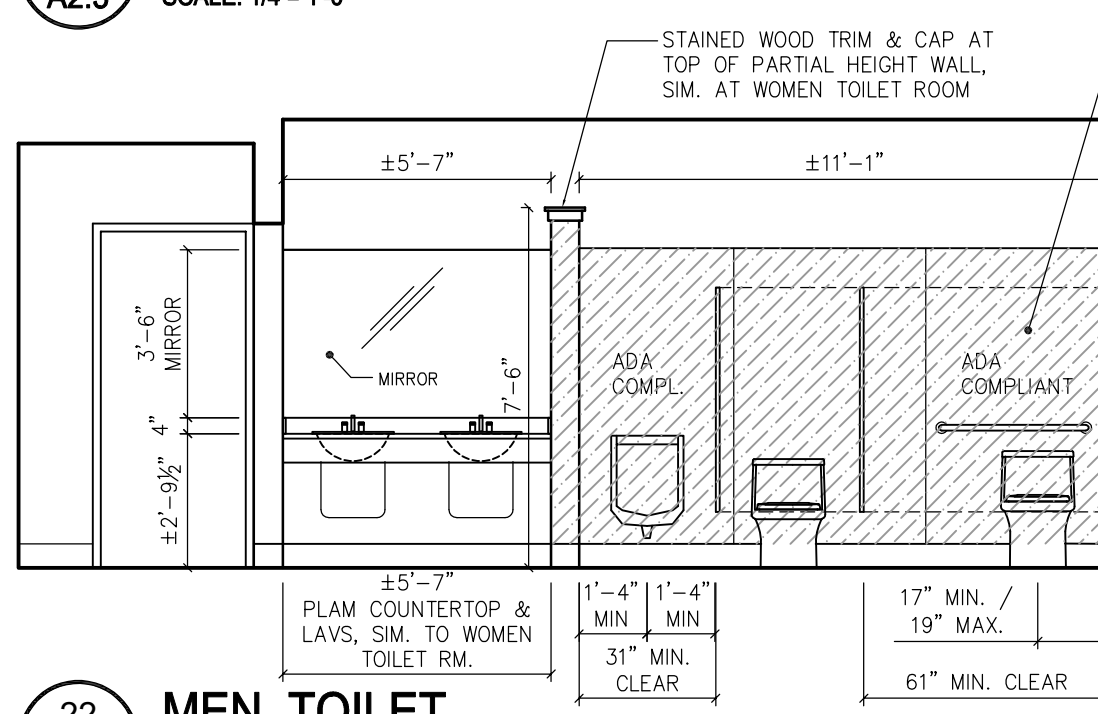


22 MEN TOILET
SCALE: 1/4" = 1'-0"

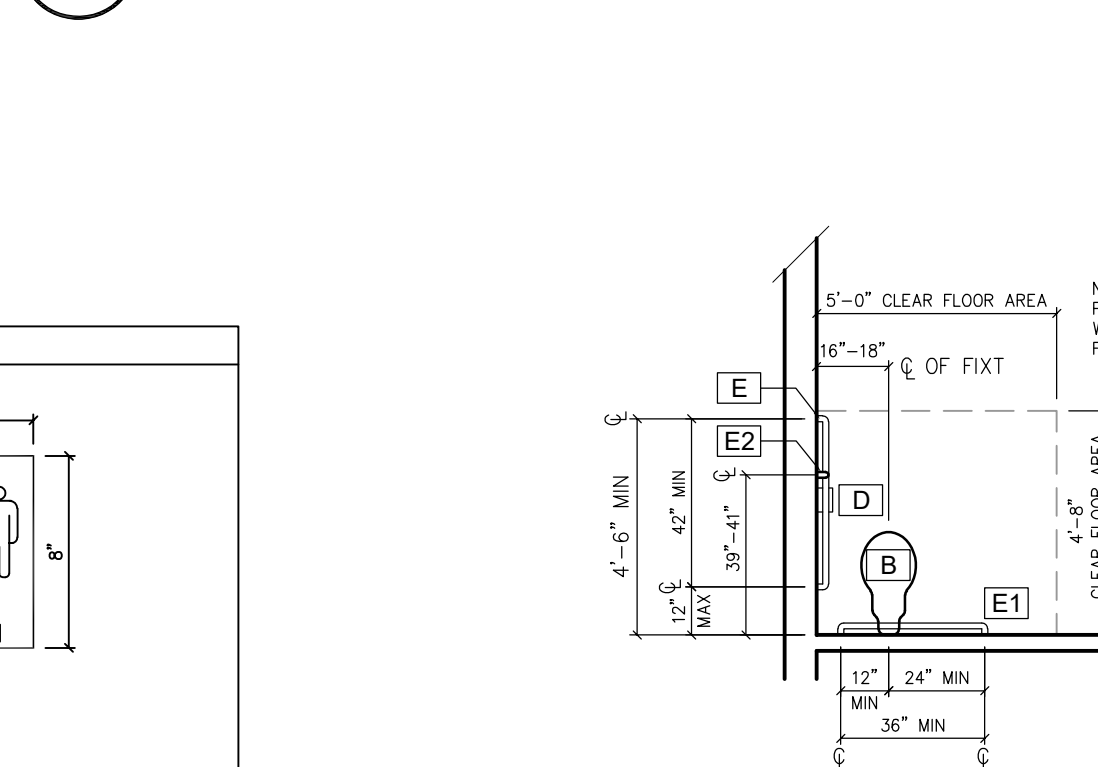


20 WOMEN TOILET
SCALE: 1/4" = 1'-0"

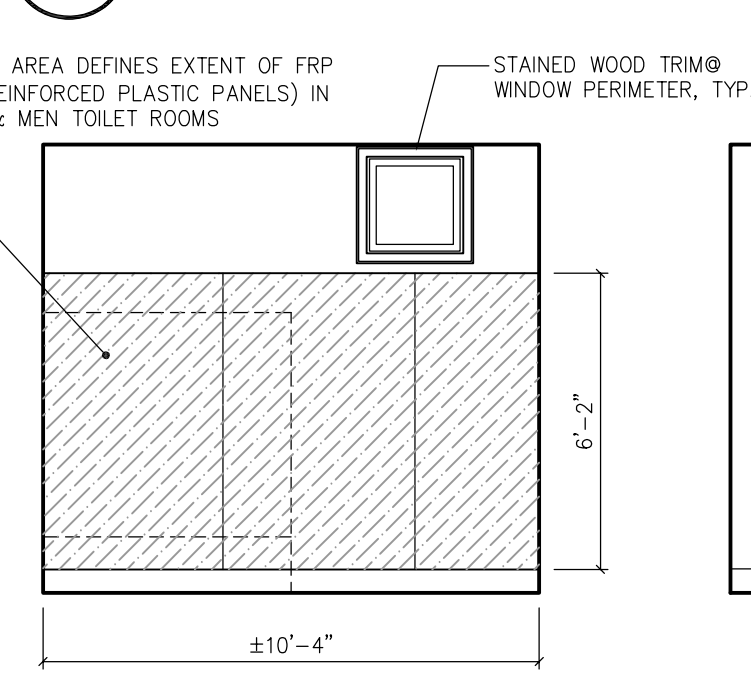


23 MEN TOILET
SCALE: 1/4" = 1'-0"

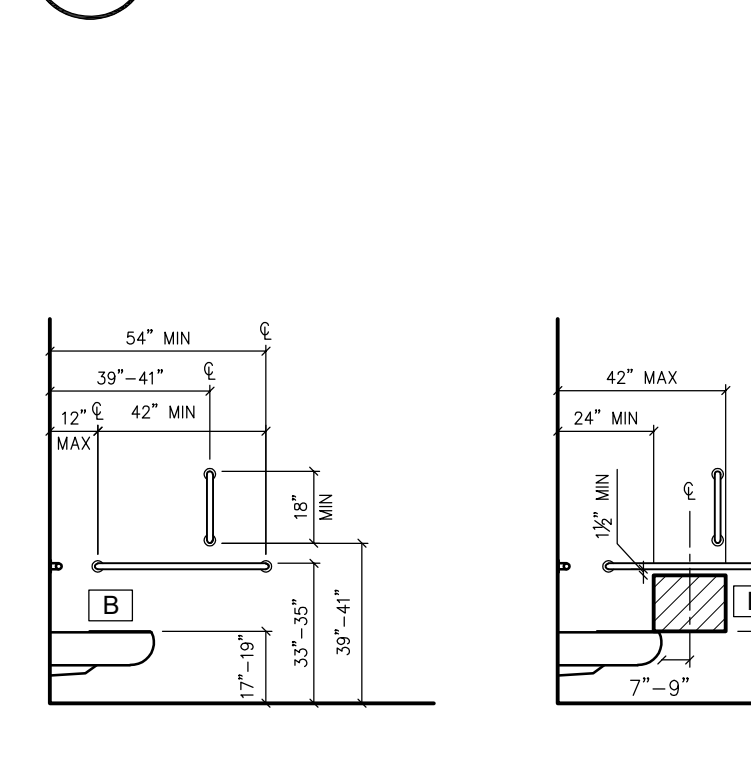

21 WOMEN TOILET
SCALE: 1/4" = 1'-0"

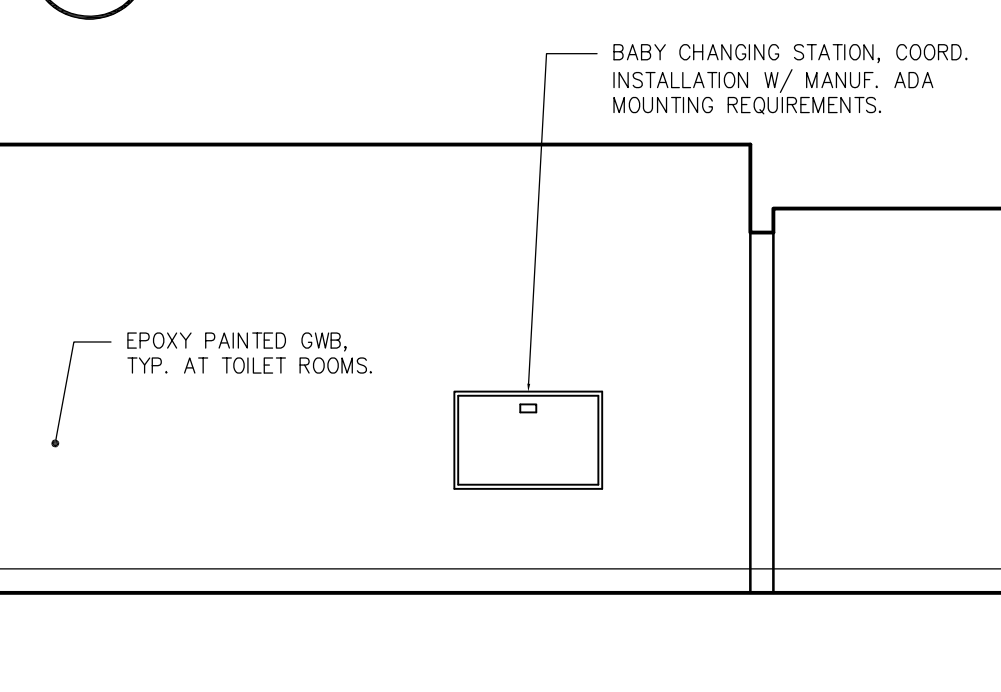

24 MEN TOILET
SCALE: 1/4" = 1'-0"

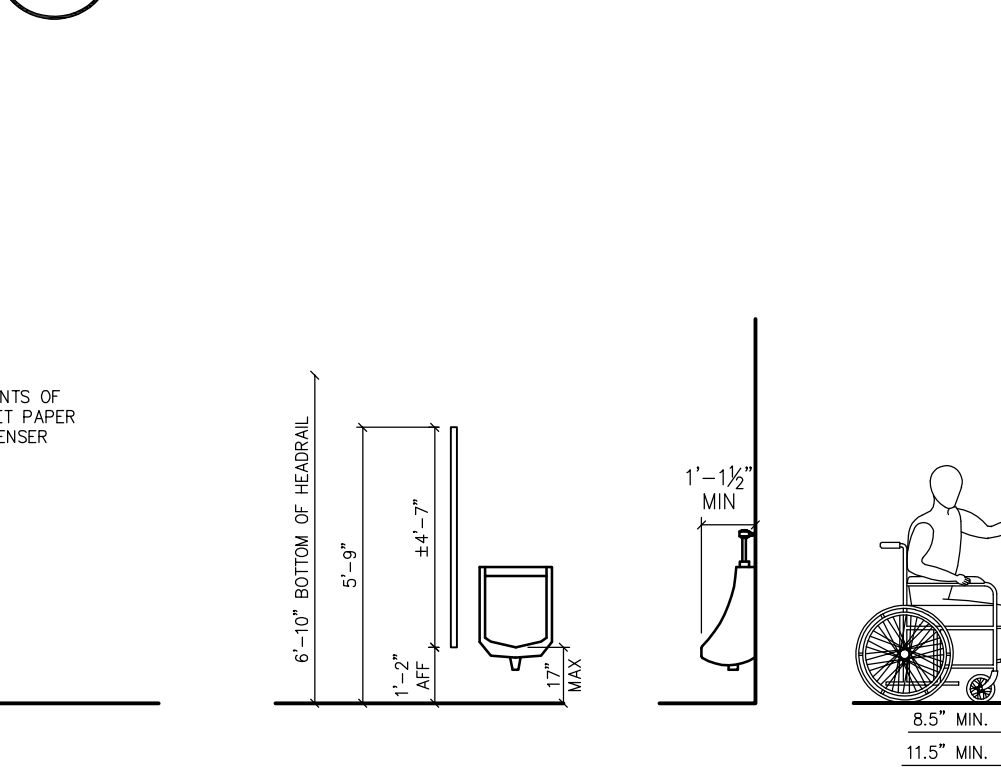

TYPICAL ACCESSIBLE TOILET ROOM PLUMBING FIXTURES & ELEMENTS
SCALE: 1/4" = 1'-0" / ADULT HEIGHT



GODSHALL KANE O'ROURKE ARCHITECTS, LLC
300 Brookside Avenue
Suite 150
Annapolis, MD 21403
T: 215.646.5707 F: 215.646.5707 W: gkarchitects.com



ADDITIONS AND RENOVATIONS FOR
CHURCH OF THE
HOLY SPIRIT
2871 BARNDT ROAD, HARLEYSVILLE, PA, 19438

REVISIONS	
4-12-2021	BID SET
DRAWN BY	PMO
REVIEWED BY	2416
JOB #	
SHEET TITLE	

DETAIL PLANS /
DOOR &
TOILET RM.
SCHEDULES

SHEET #


A2.3

SCALE	AS NOTED
DATE	4-12-2021


BID SET - APRIL 12, 2021




UNIT	MARK	WIDTH	HEIGHT
CUSTOM FIXED	A	2'-4 $\frac{1}{8}$ "	4'-6"
A21 (1) SEE GLAZING SPEC FOR 3M WDW FILM	B	2'-0 $\frac{0}{8}$ "	2'-0 $\frac{0}{8}$ "
A21 (1)	C	2'-0 $\frac{0}{8}$ "	2'-0 $\frac{0}{8}$ "
NOT USED	D		
A281 (2)	E	5'-3"	2'-0 $\frac{0}{8}$ "
A281 (2) + CUSTOM FIXED (2)	F	5'-3"	8'-0"
A21 (1) + CUSTOM FIXED (1)	G	2'-0 $\frac{0}{8}$ "	8'-0"
A21 (1) FIXED	H	2'-0 $\frac{0}{8}$ "	2'-0 $\frac{0}{8}$ "
A351 (1) + CUSTOM FIXED (1)	J	3'-4 $\frac{13}{16}$ "	8'-0"
A351 (1) FIXED	K	3'-4 $\frac{13}{16}$ "	2'-0 $\frac{0}{8}$ "
AN281 (1) + CUSTOM FIXED (2)	L	5'-2 $\frac{3}{4}$ "	5'-9"
A231 (1) + CUSTOM FIXED (2)	M	5'-11 $\frac{5}{8}$ "	5'-9"
AN281 (1) + CUSTOM FIXED (1)	N	2'-7 $\frac{1}{2}$ "	5'-9"
A251 (1) + CUSTOM FIXED (1)	O	2'-4 $\frac{0}{8}$ "	6'-4 $\frac{1}{2}$ "
A251 (1) FIXED	P	2'-4 $\frac{0}{8}$ "	2'-0 $\frac{0}{8}$ "
A351 (1) + CUSTOM FIXED (1)	Q	3'-4 $\frac{13}{16}$ "	6'-4 $\frac{1}{2}$ "
A351 (1) FIXED	R	3'-4 $\frac{13}{16}$ "	2'-0 $\frac{0}{8}$ "
CUSTOM TRAPEZOID (FIELD VERIFY)	S1	3'-4 $\frac{13}{16}$ "	3'-2 $\frac{1}{2}$ "
CUSTOM TRAPEZOID (FIELD VERIFY)	S2	2'-0 $\frac{0}{8}$ "	4'-6 $\frac{11}{16}$ "
CUSTOM TRAPEZOID (FIELD VERIFY)	S3	2'-0 $\frac{0}{8}$ "	5'-10 $\frac{11}{16}$ "
A21 (1) + CUSTOM FIXED (1)	T	2'-0 $\frac{0}{8}$ "	6'-4 $\frac{1}{2}$ "
A21 (1) FIXED	U	2'-0 $\frac{0}{8}$ "	2'-0 $\frac{0}{8}$ "
AN281 (2) + CUSTOM FIXED (2)	V	5'-3"	5'-2"
A281 (1) + CUSTOM FIXED (1)	W	2'-7 $\frac{1}{2}$ "	8'-0"
A281 (1) FIXED	X	2'-7 $\frac{1}{2}$ "	2'-0 $\frac{0}{8}$ "

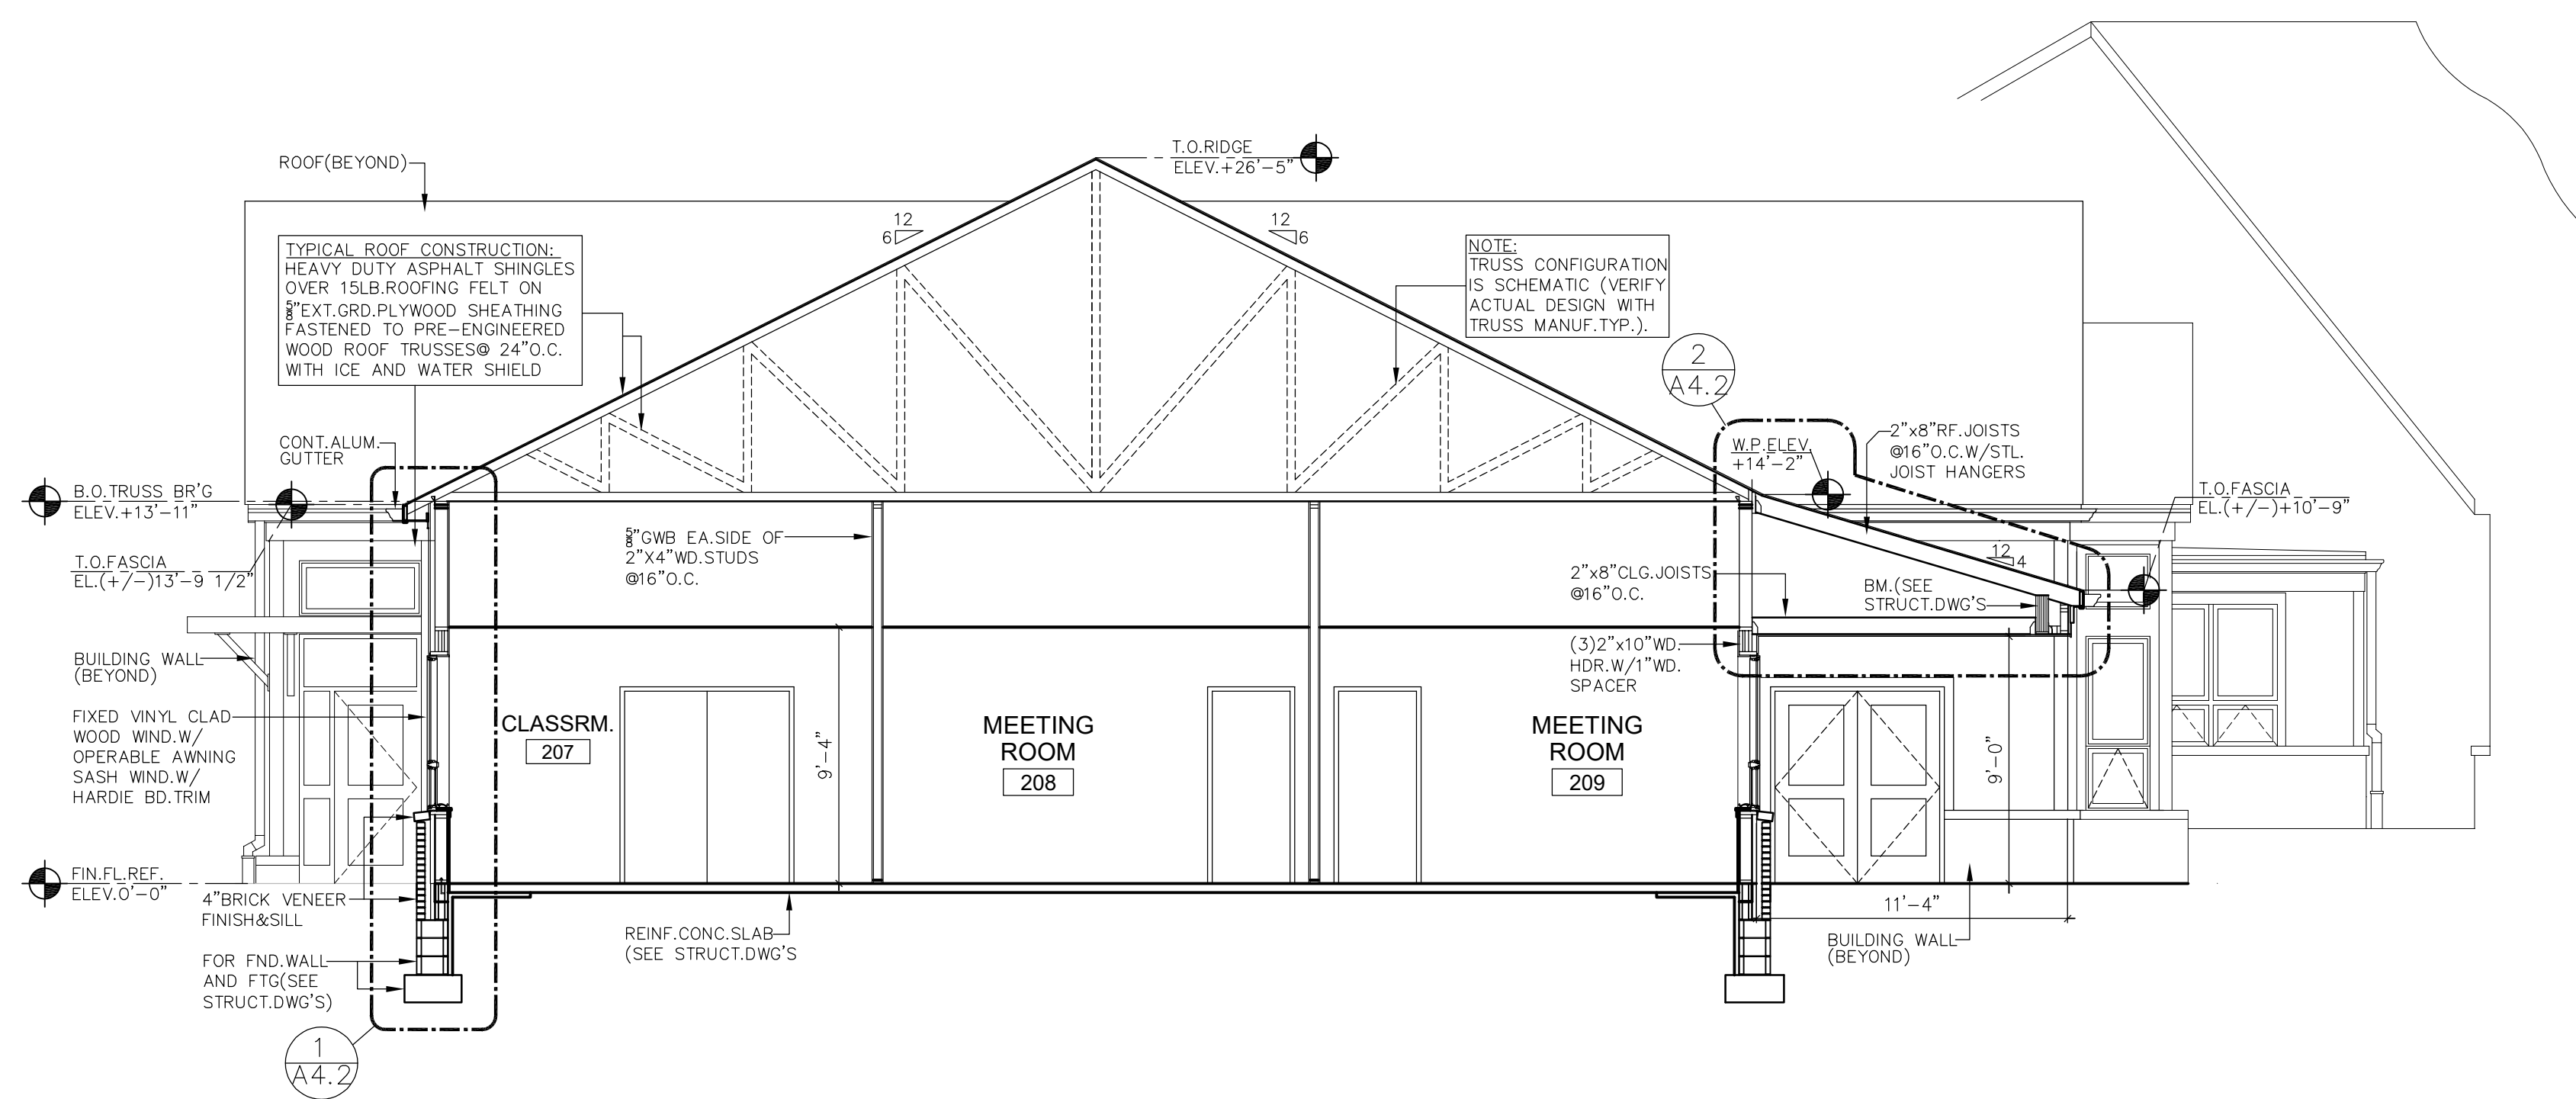


1 BUILDING SECTION "AA"
SCALE: 3/16"=1'-0"

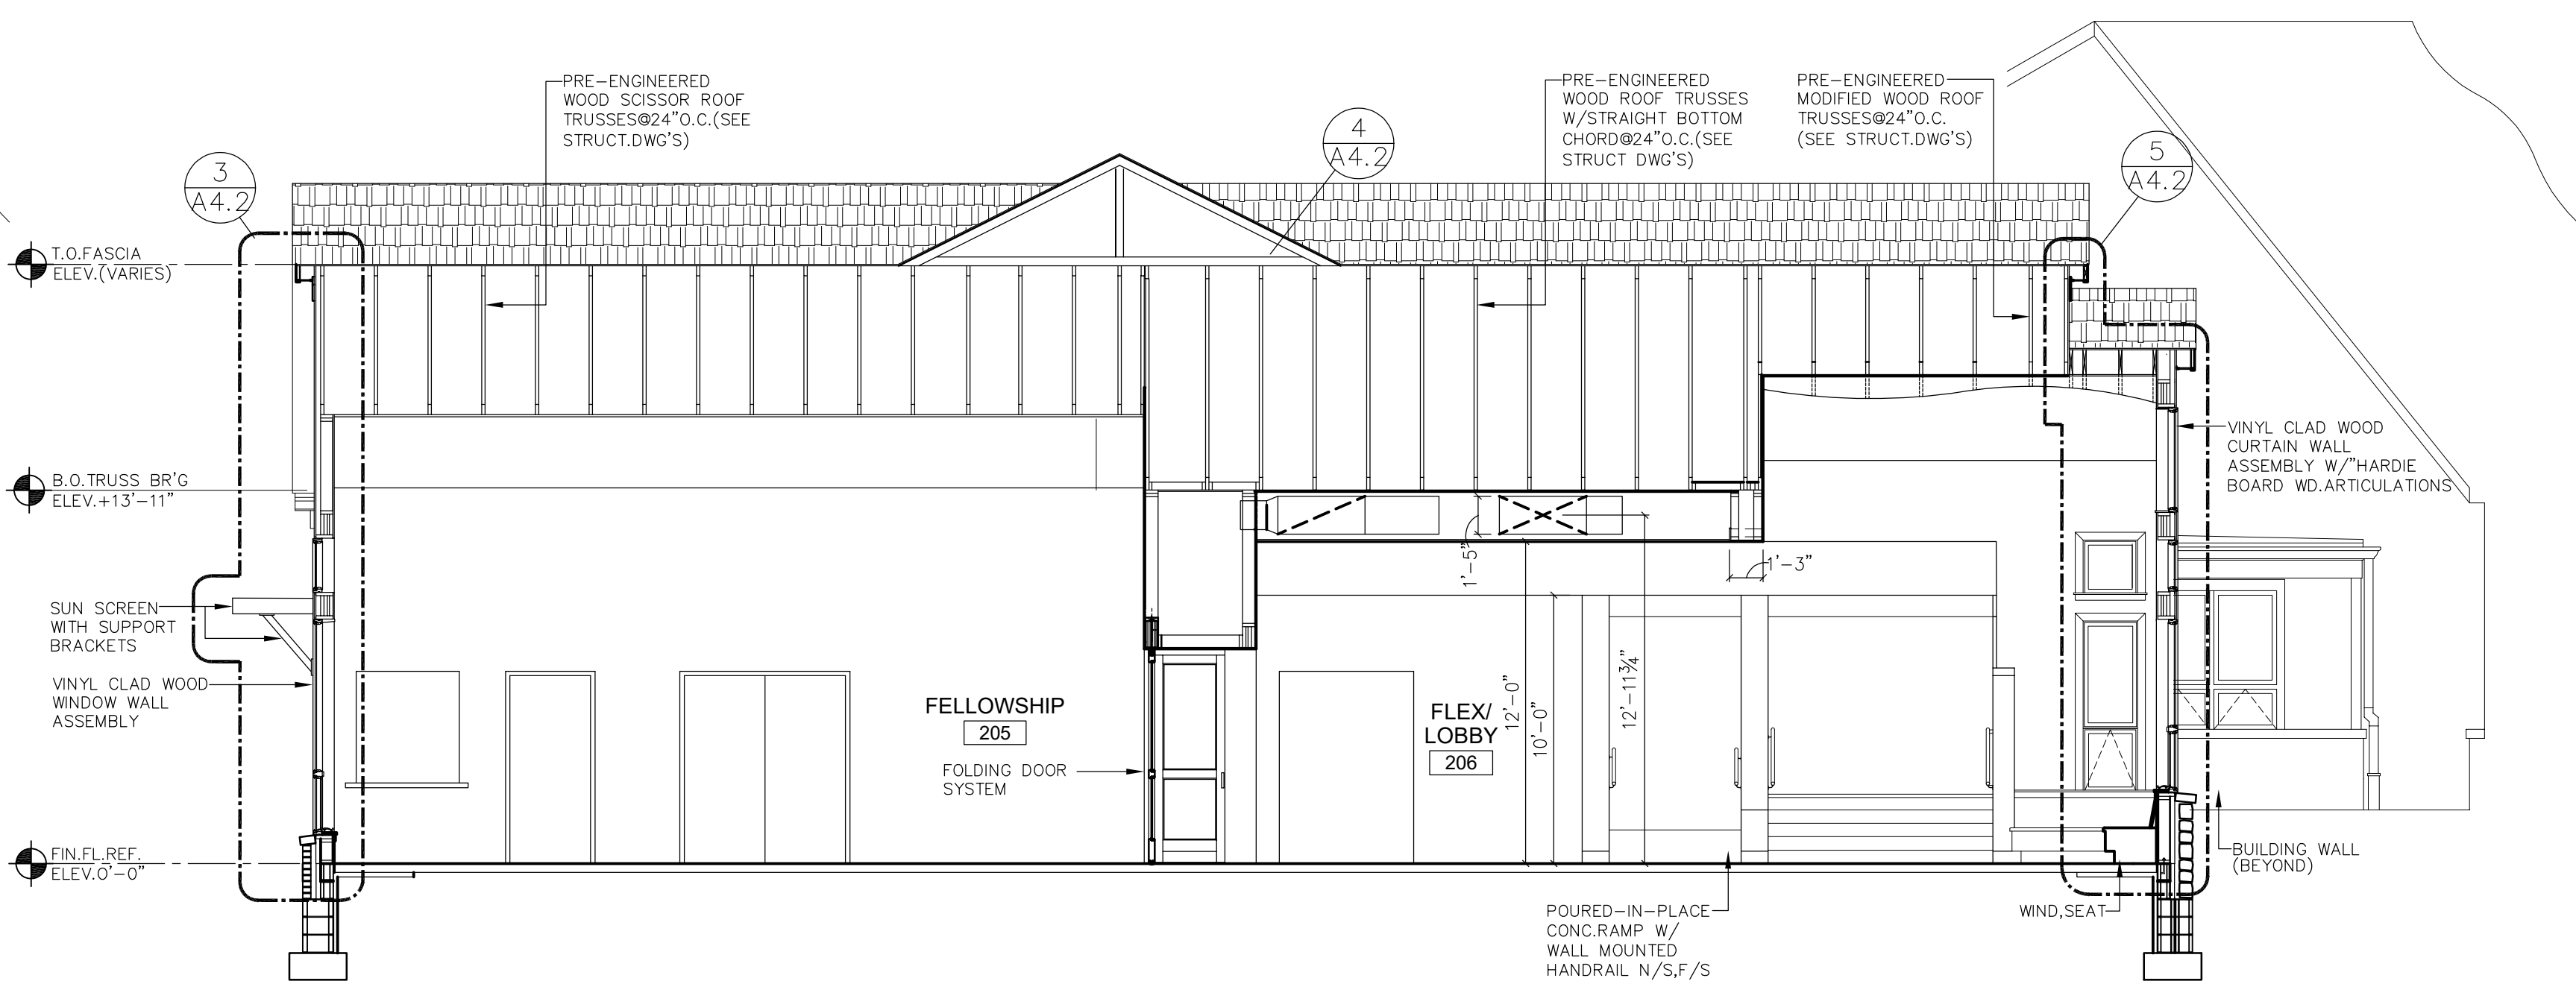


2 BUILDING SECTION "BB"
SCALE: 3/16"=1'-0"

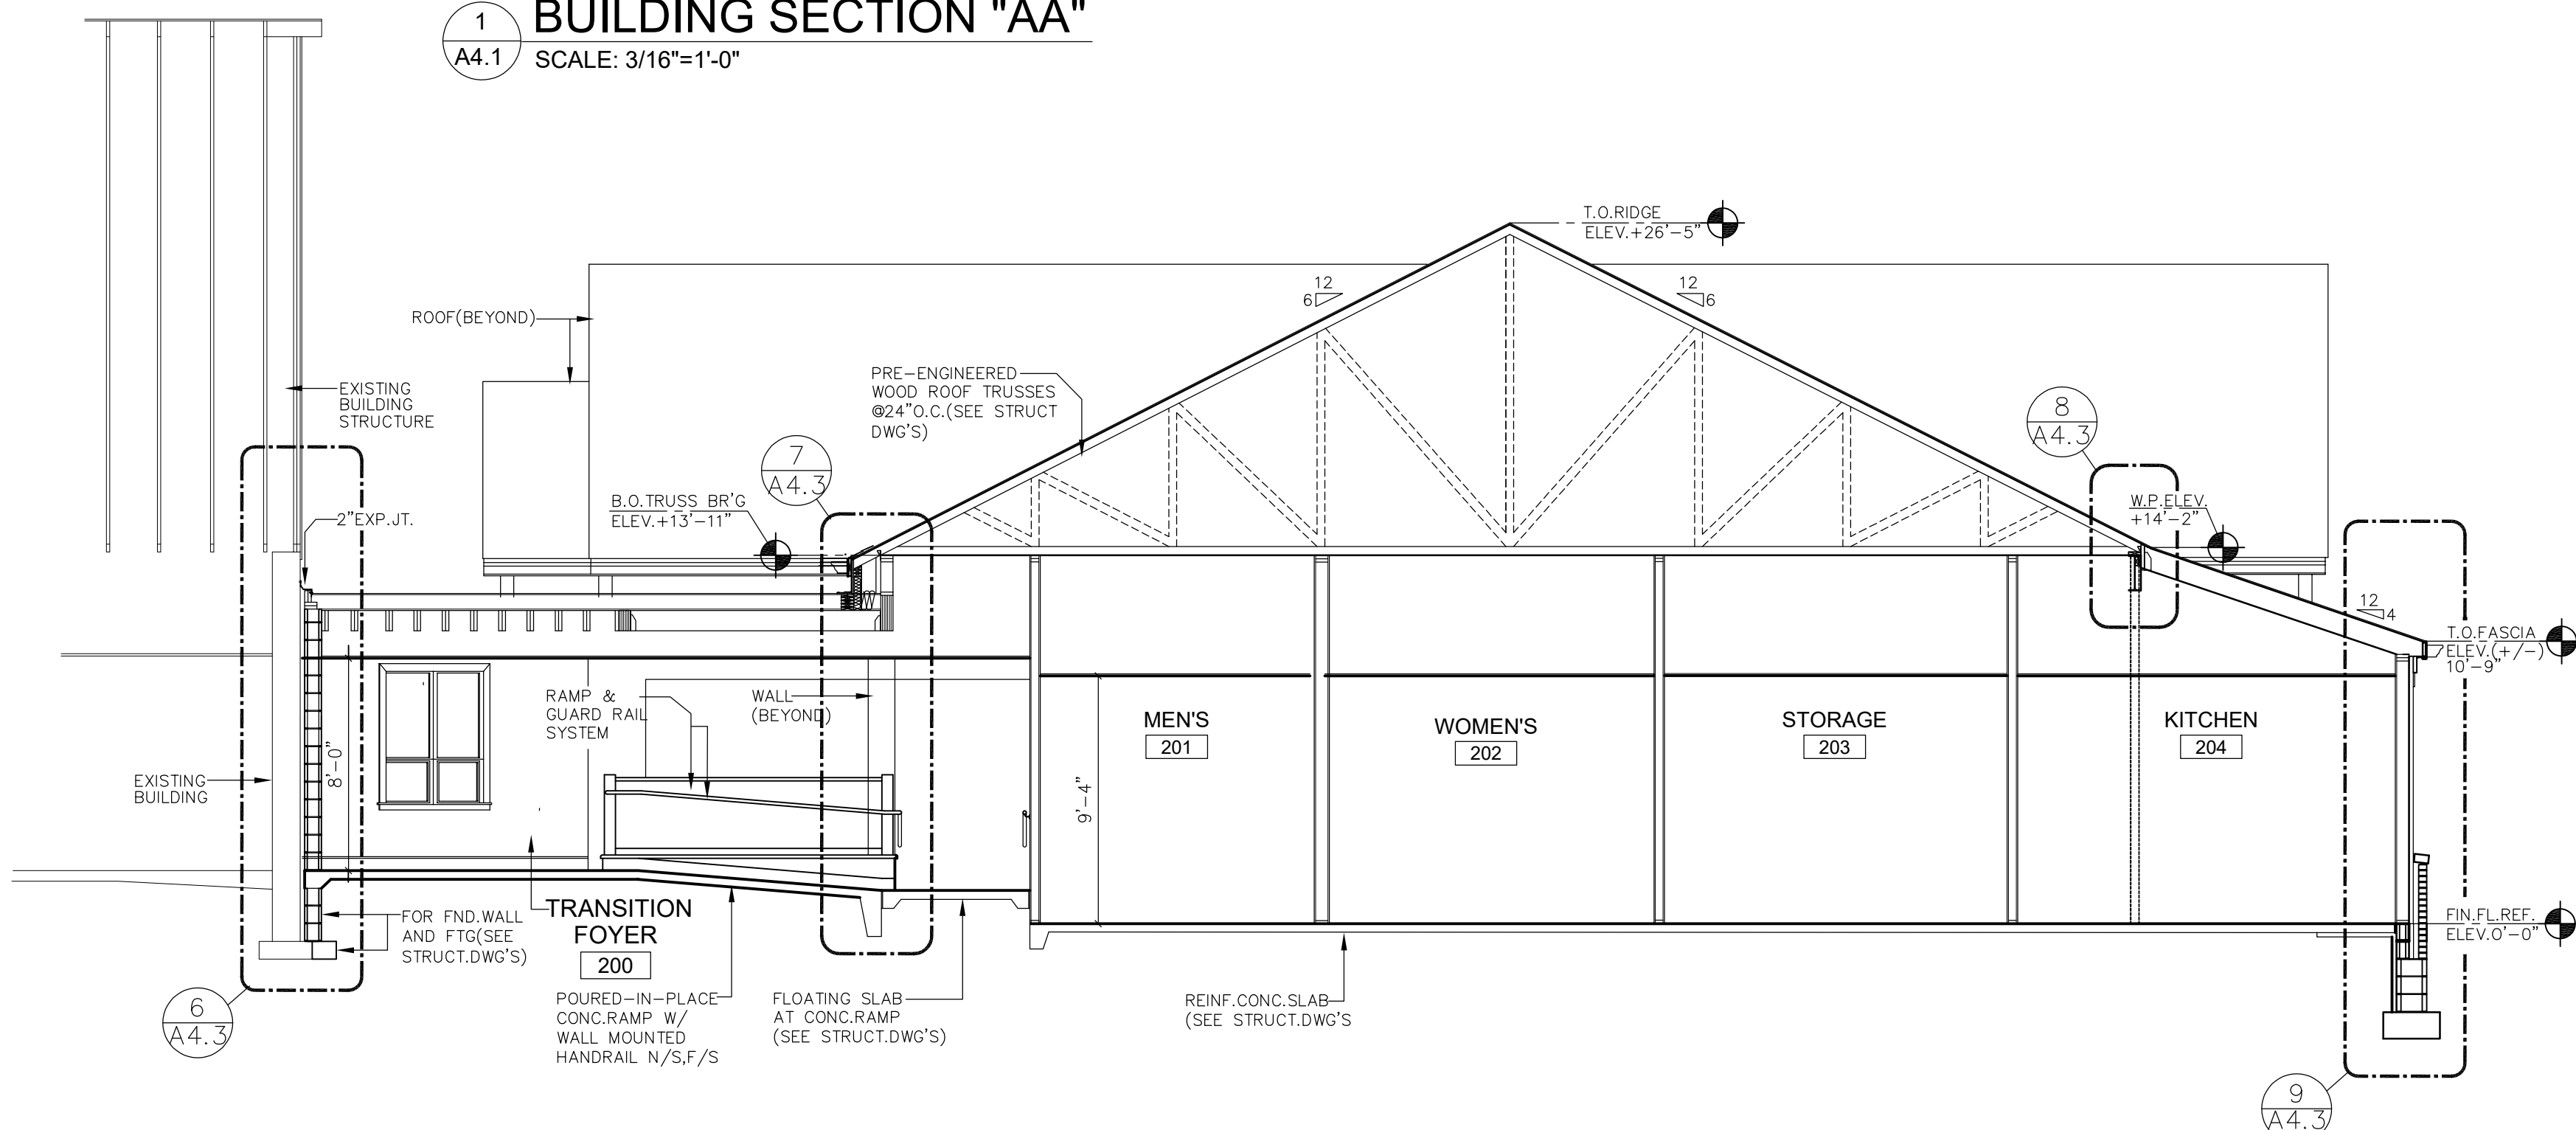


3 BUILDING SECTION "CC"
SCALE: 3/16"=1'-0"

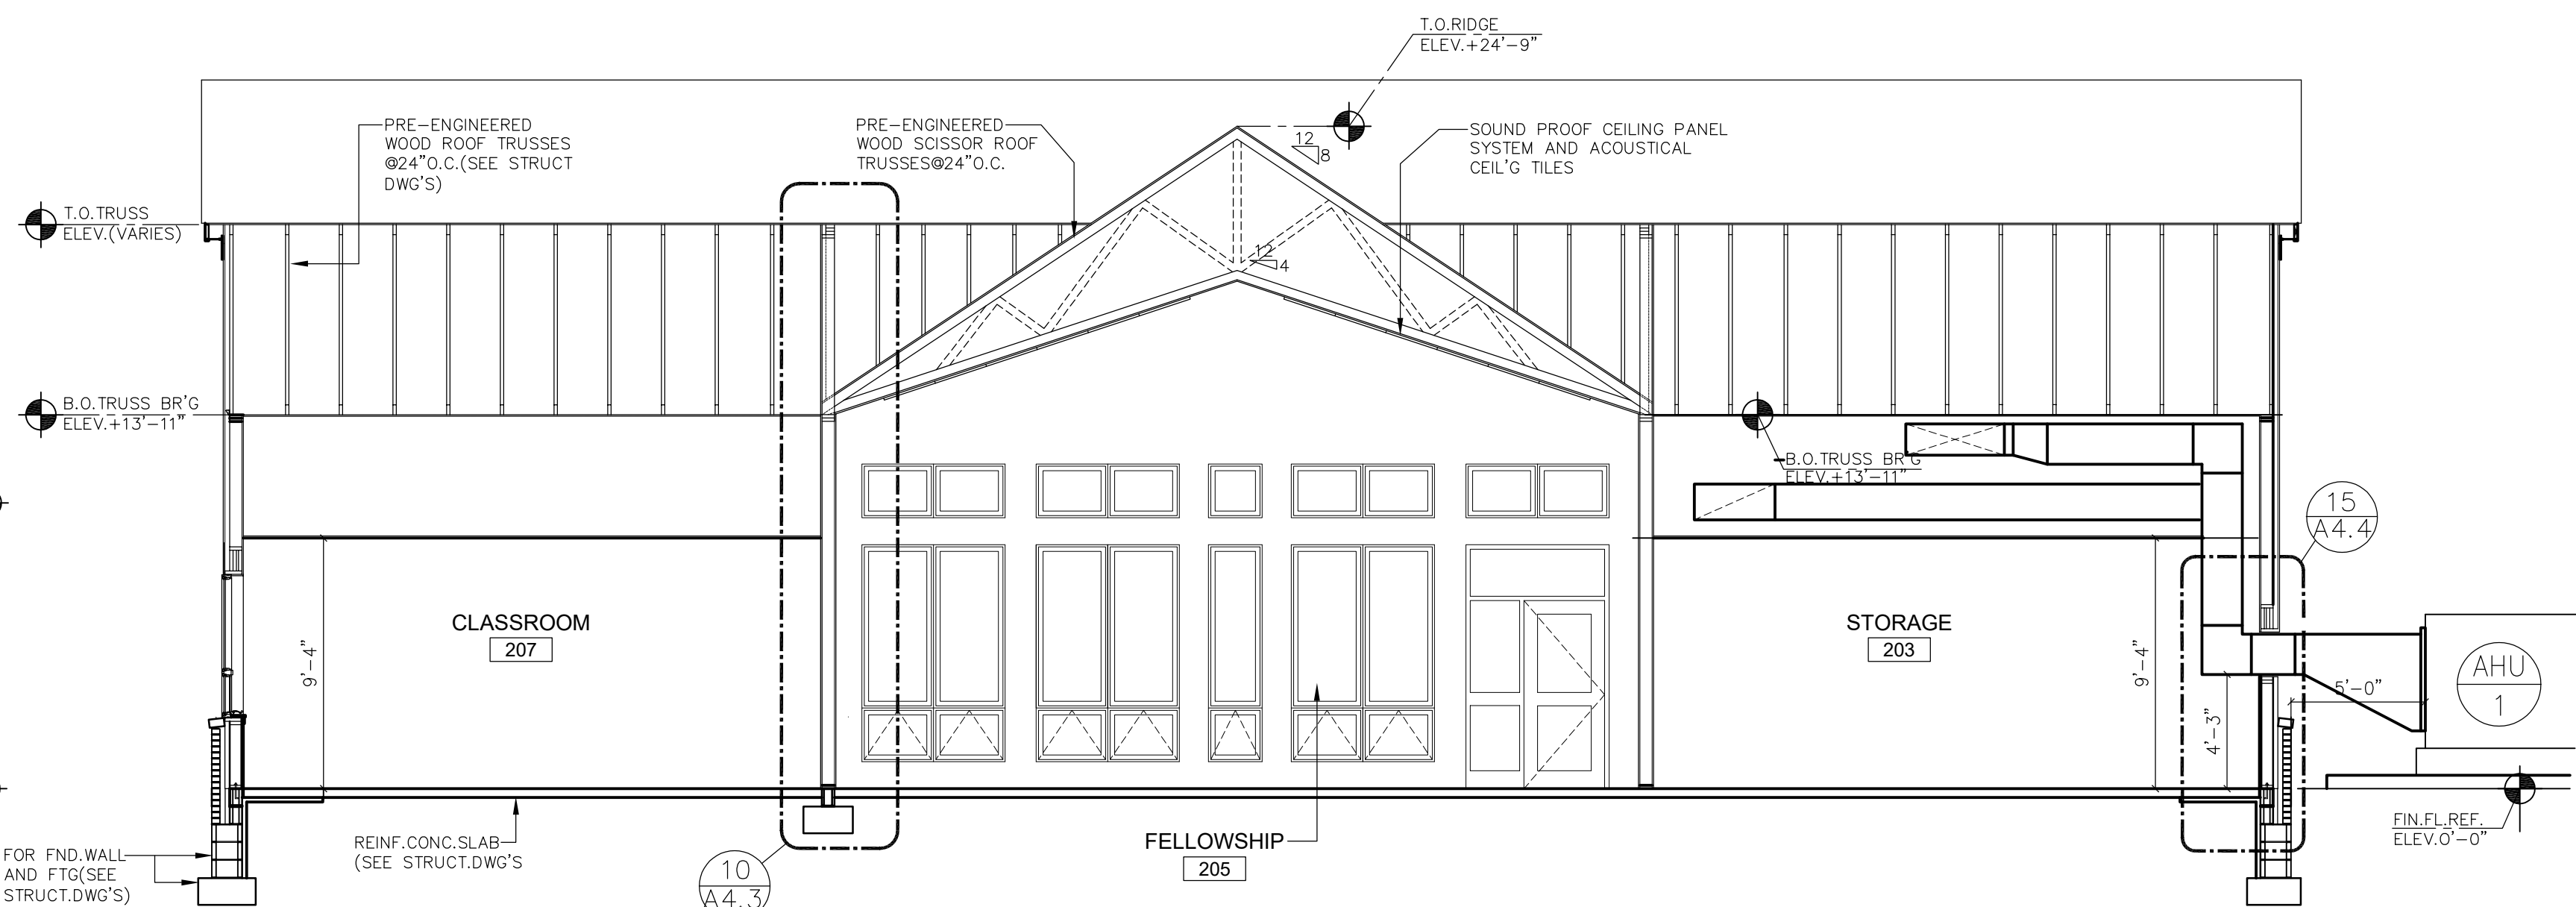

4 BUILDING SECTION "DD"
SCALE: 3/16"=1'-0"

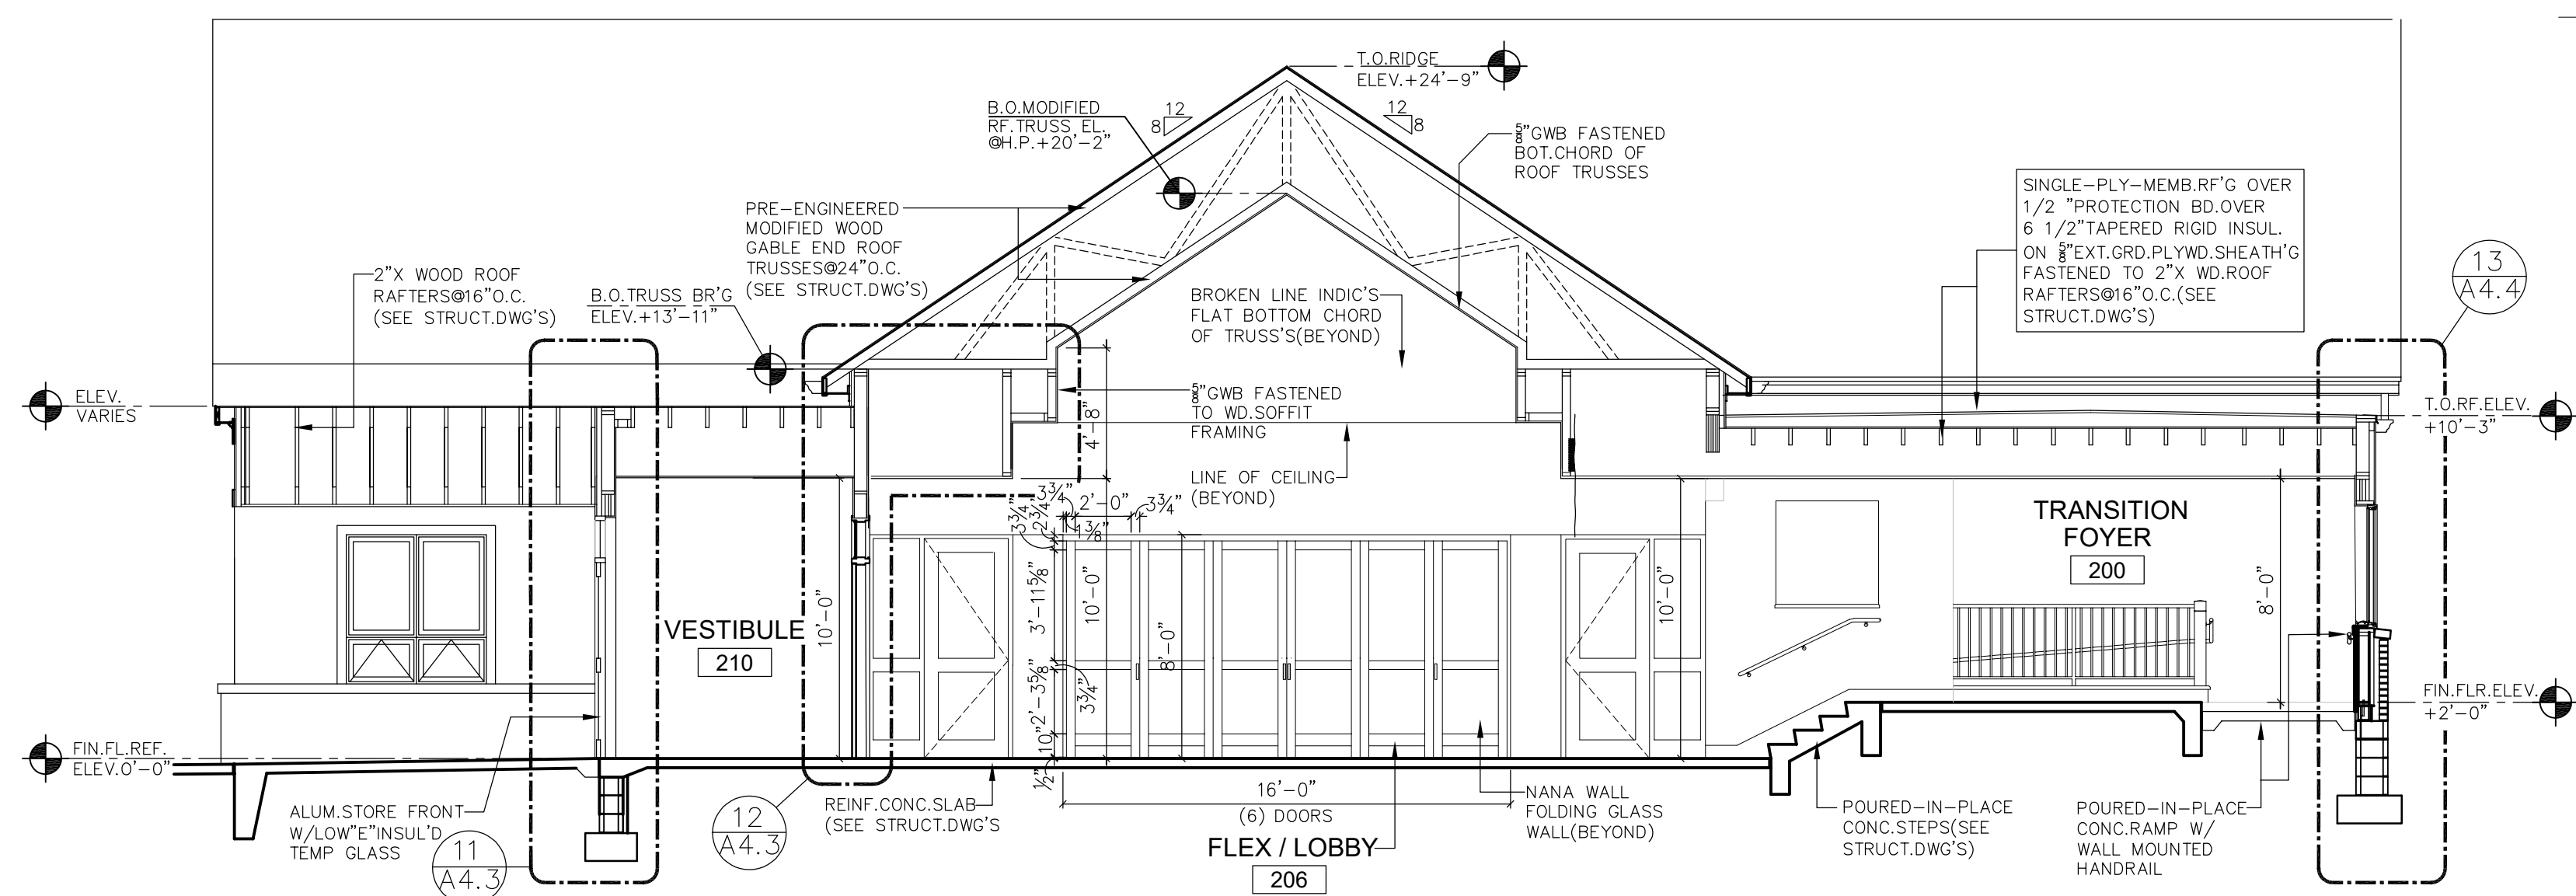

5 BUILDING SECTION "EE"
SCALE: 3/16"=1'-0"

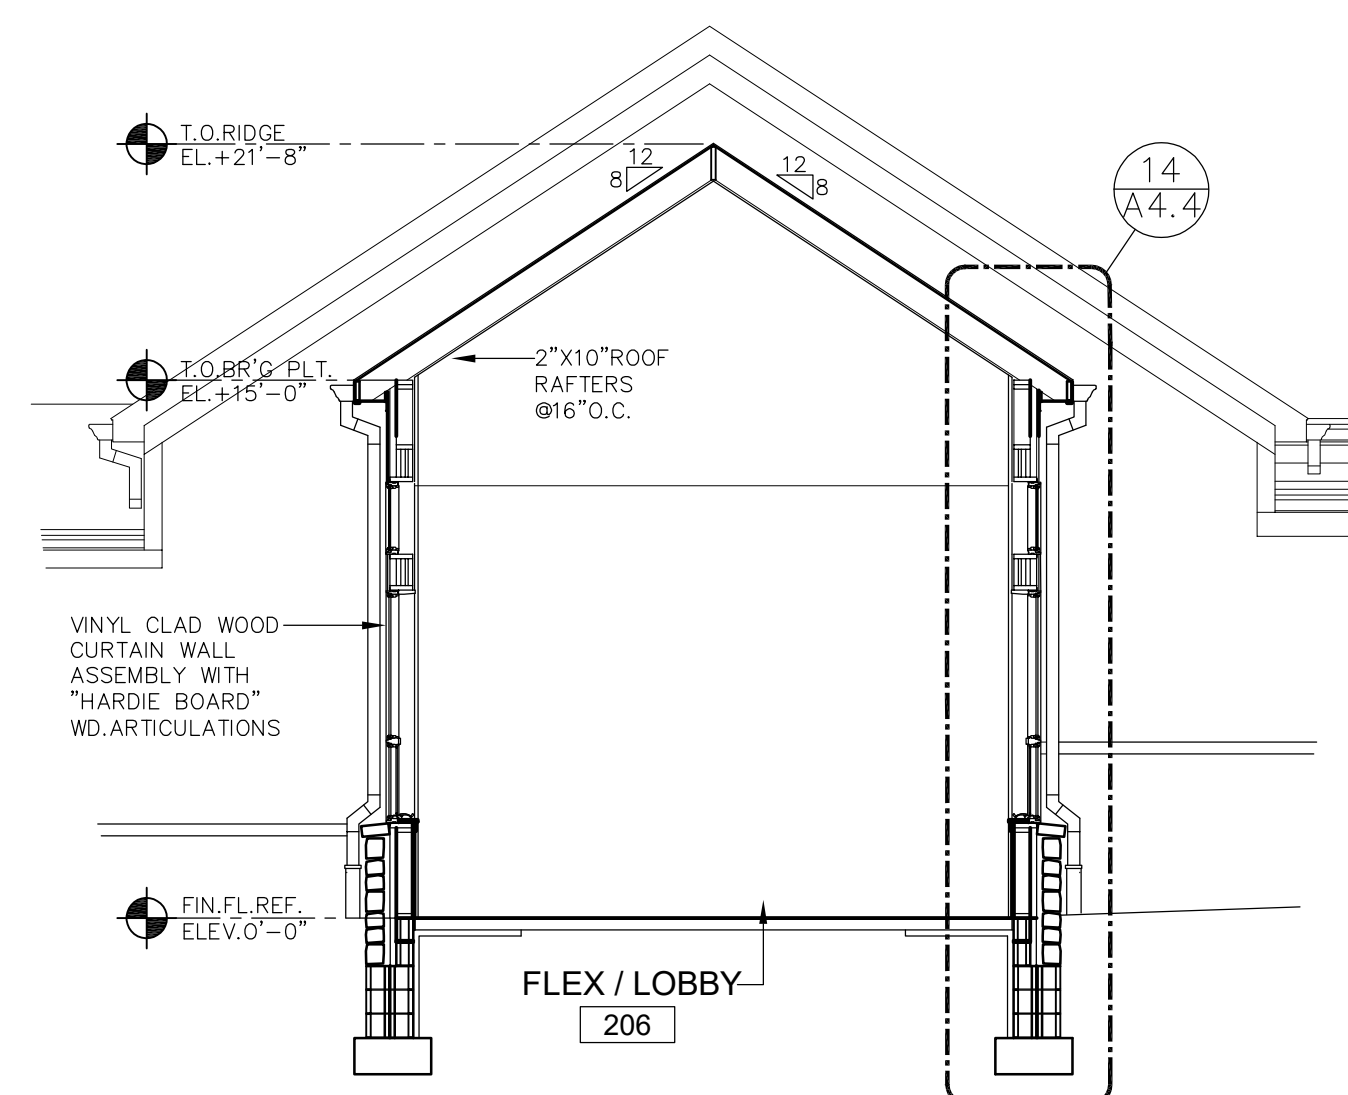

6 BUILDING SECTION "FF"
SCALE: 3/16"=1'-0"

STAMP

CONSULTANTS

GODSHALL KANE O'ROURKE ARCHITECTS, LLC
300 Brookside Avenue
Suite 150
Ambler, PA 19002
T: 215.646.5707 F: 215.646.5707 W: gkoarchitects.com



ADDITIONS AND RENOVATIONS FOR

CHURCH OF THE
HOLY SPIRIT

2871 BARNDT ROAD, HARLEYSVILLE, PA, 19438

REVISIONS

4-12-2021 BID SET

DRAWN BY

REVIEWED BY

JOB #

SHEET TITLE

PMO

2416

BUILDING SECTIONS

SHEET #

A4.1






SCALE

AS NOTED

DATE

4-12-2021

BID SET - APRIL 12, 2021

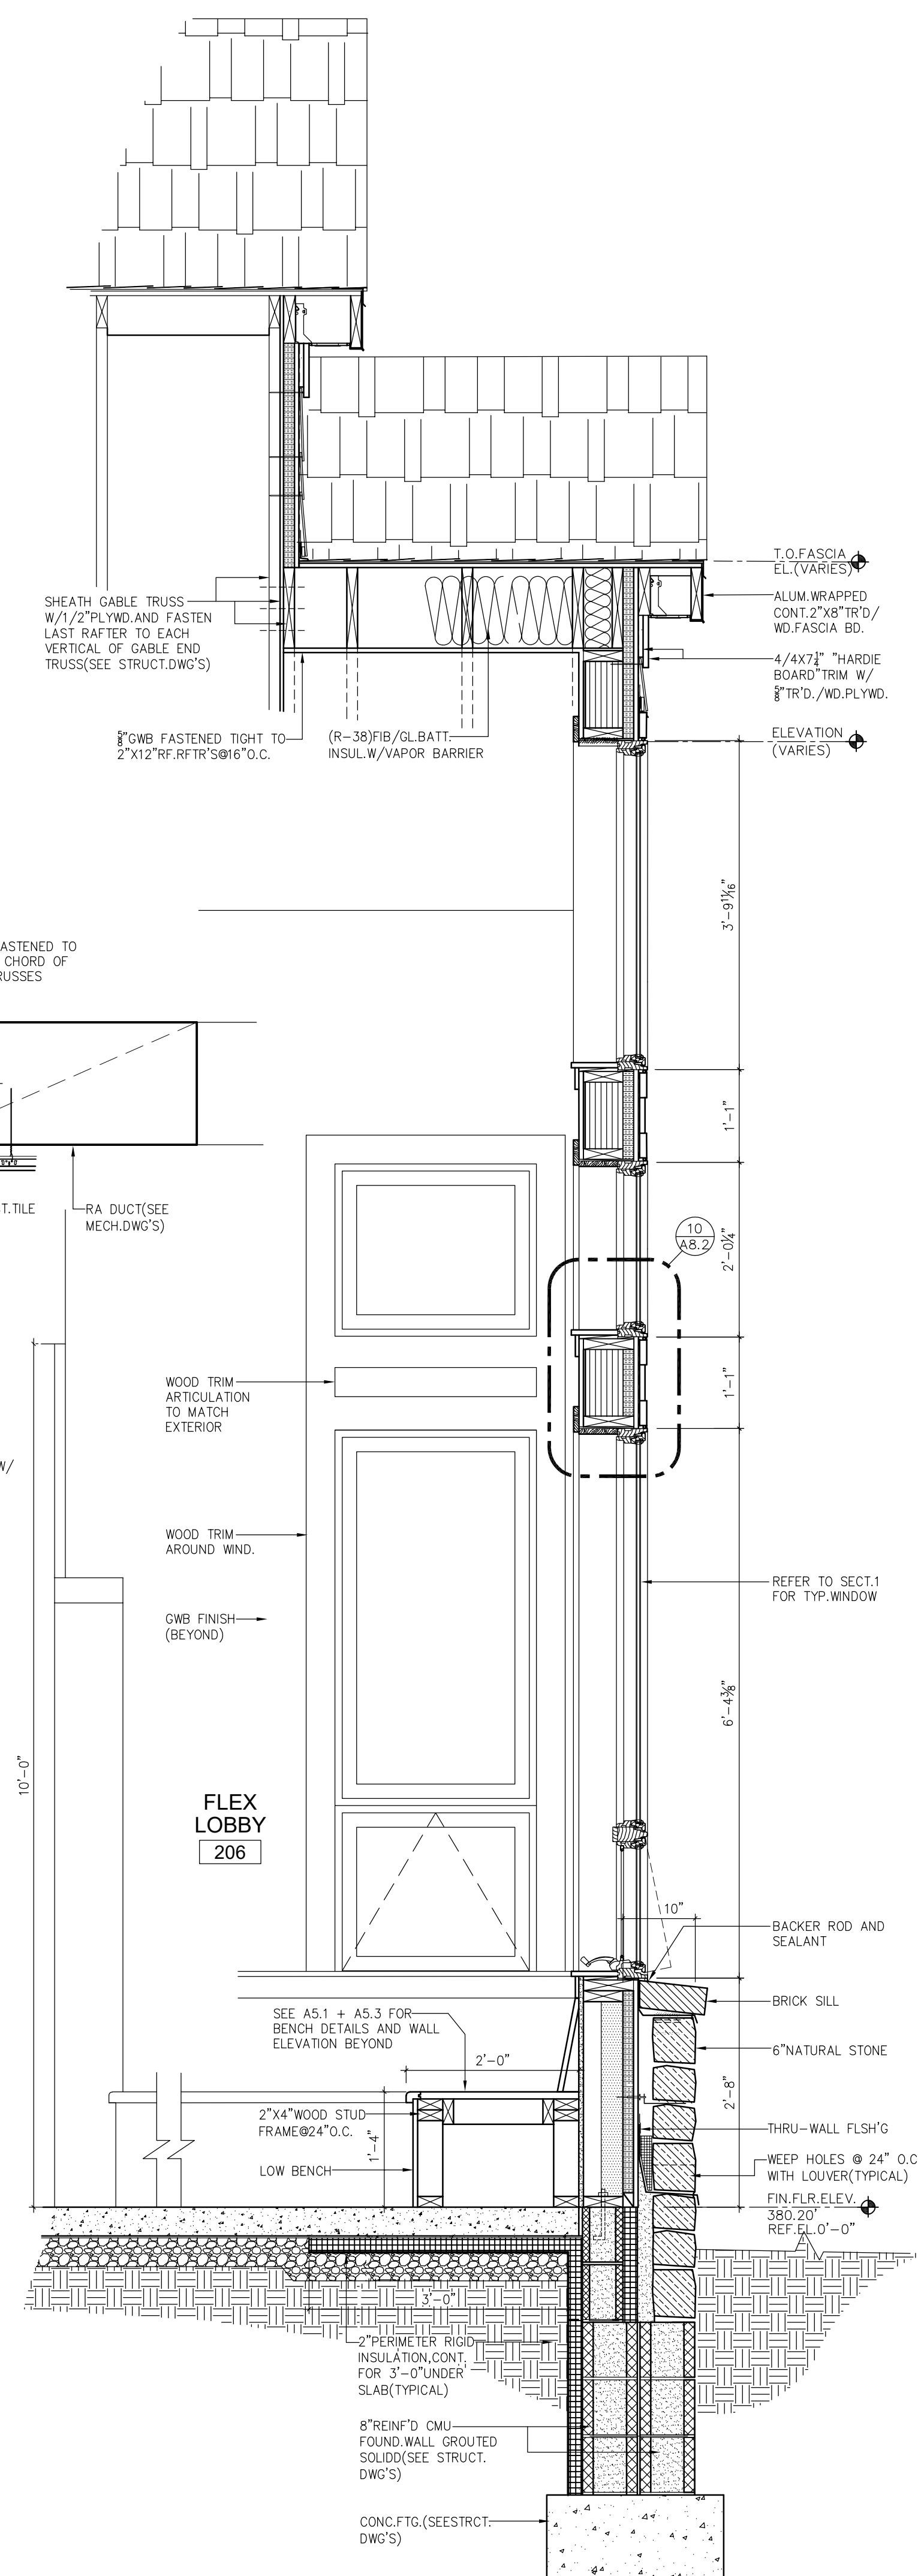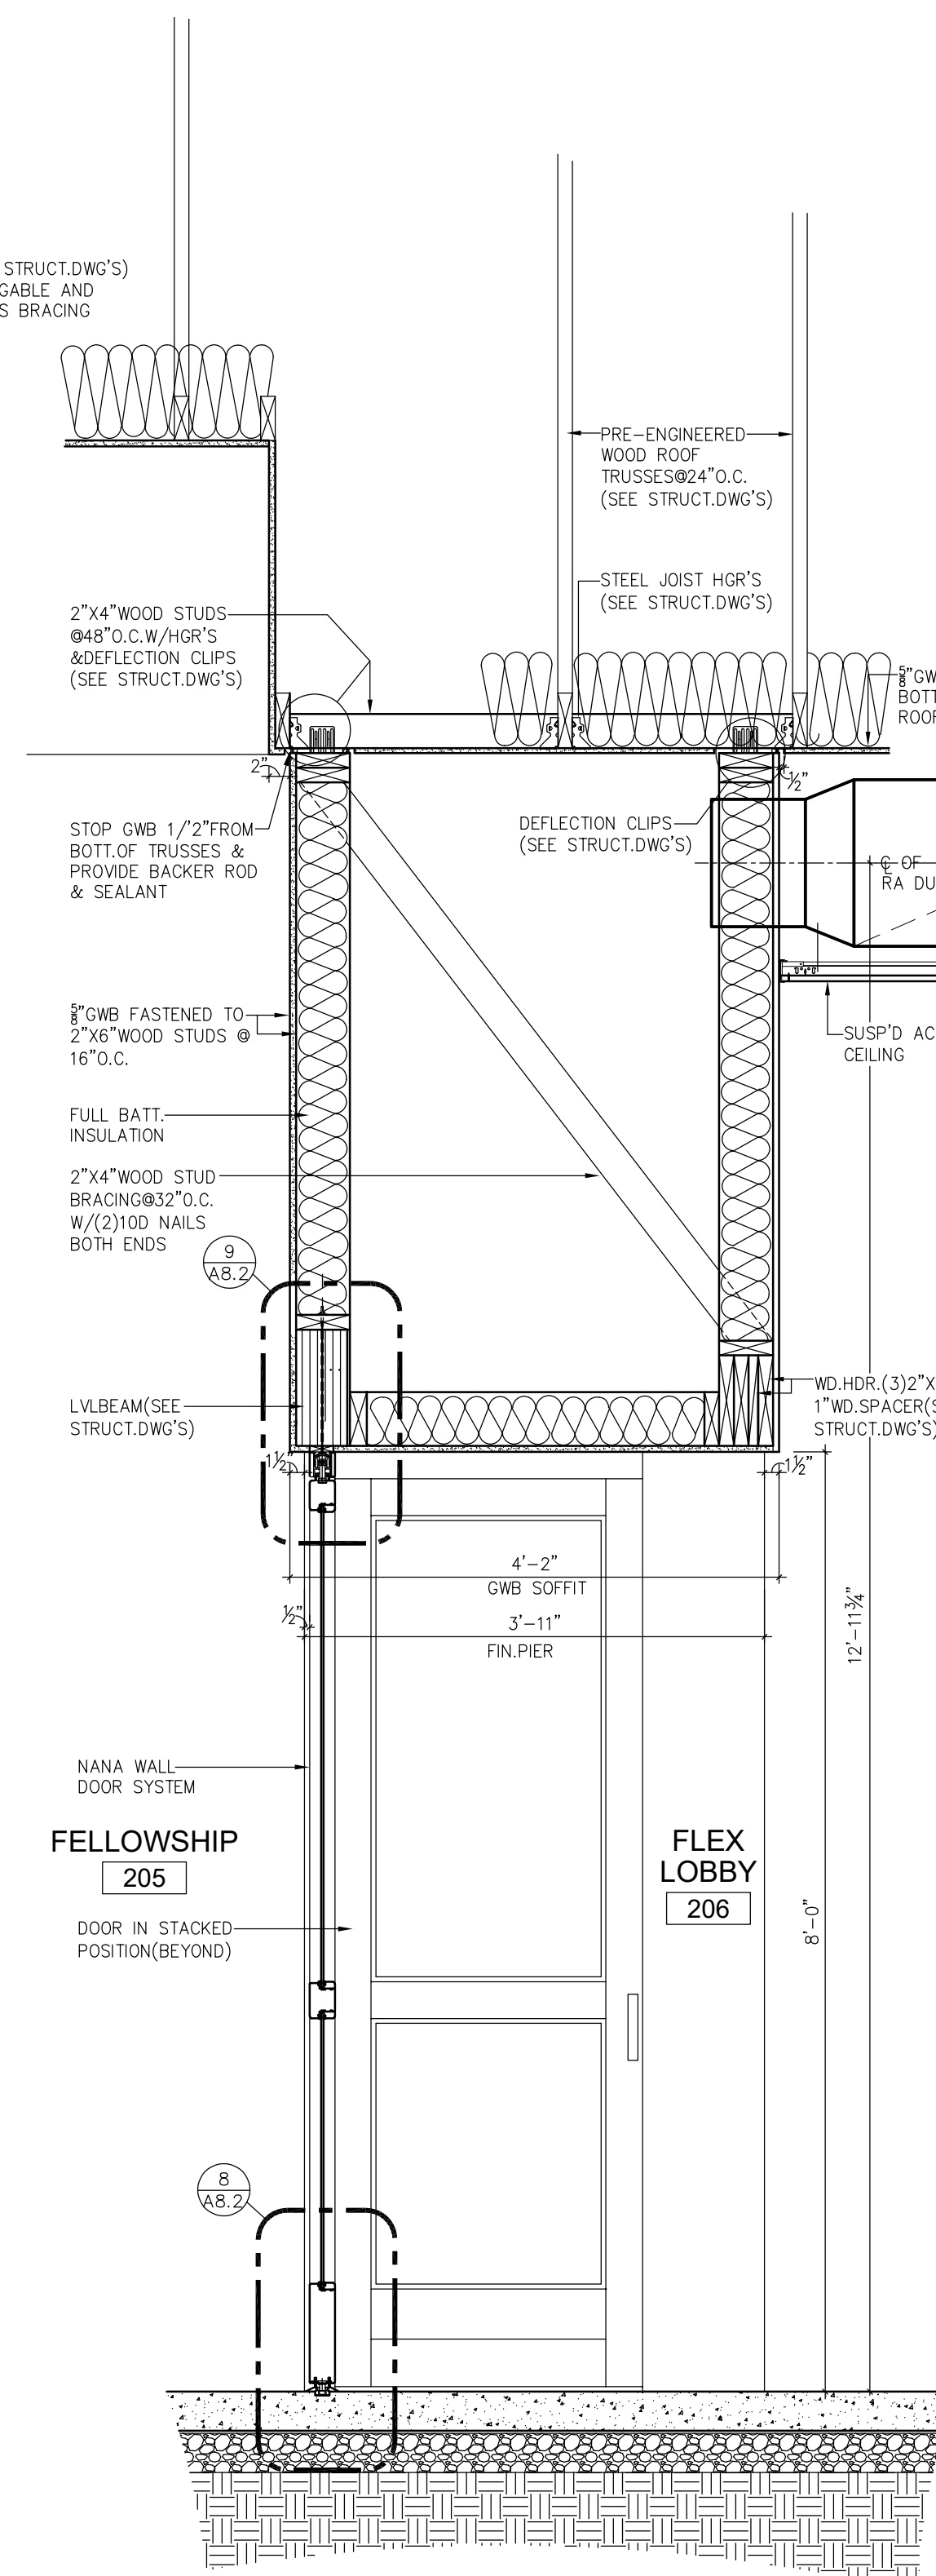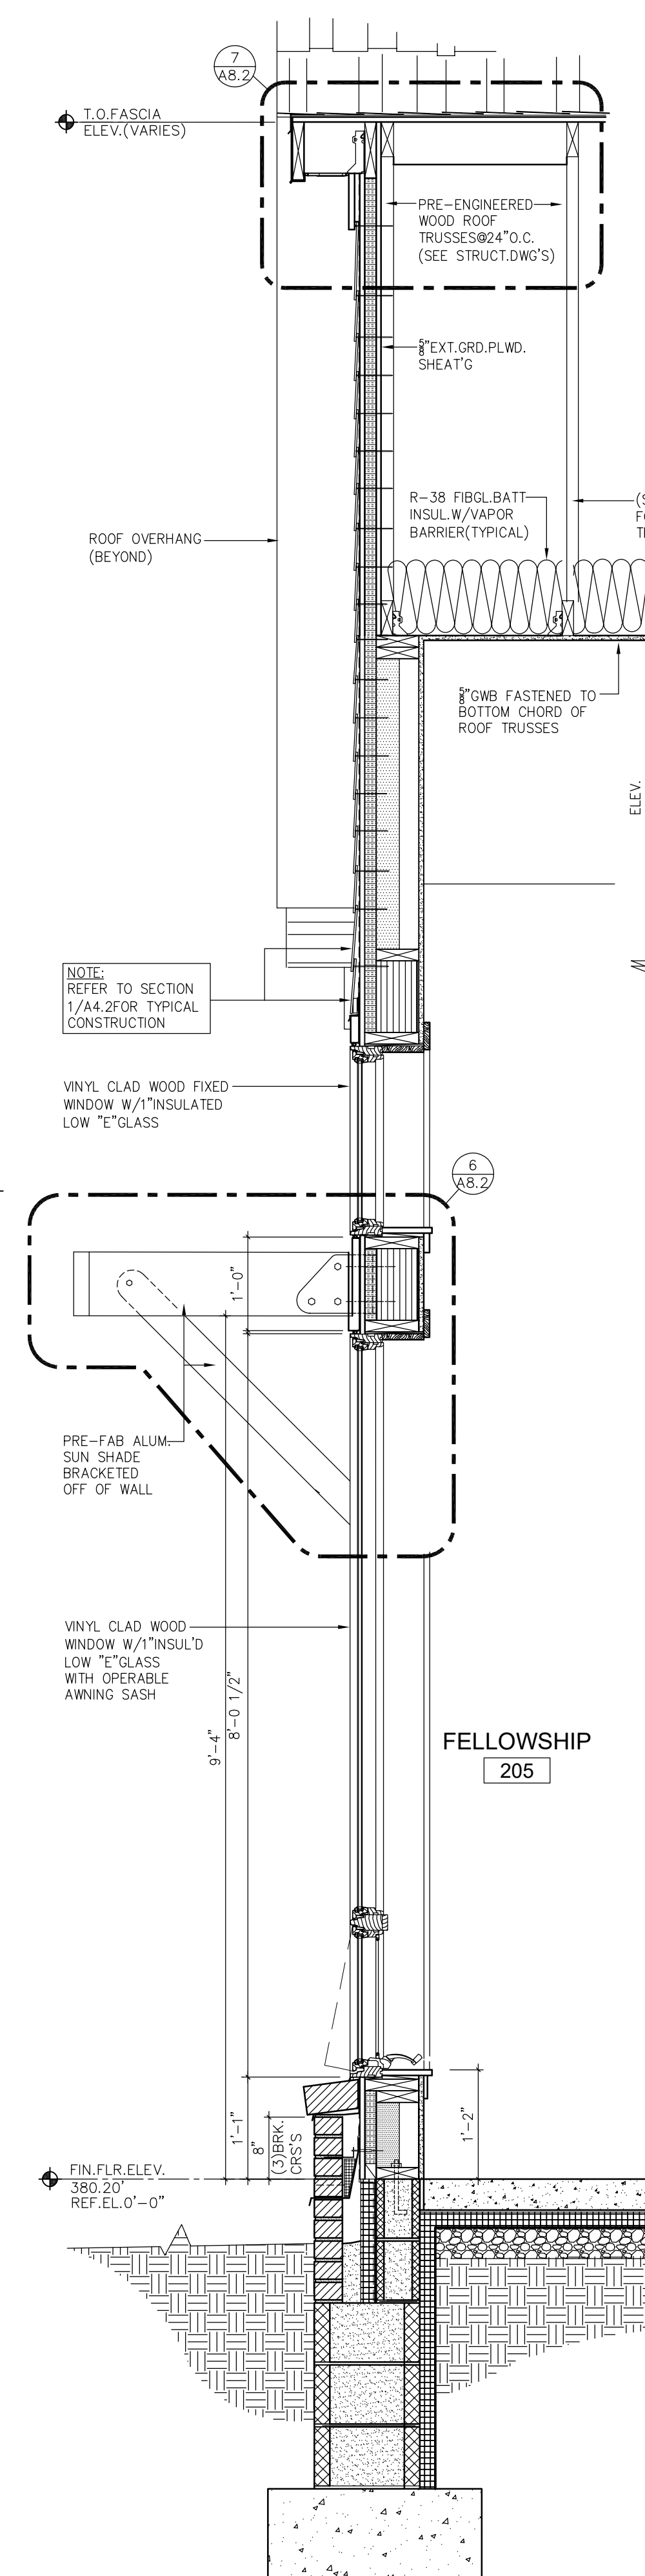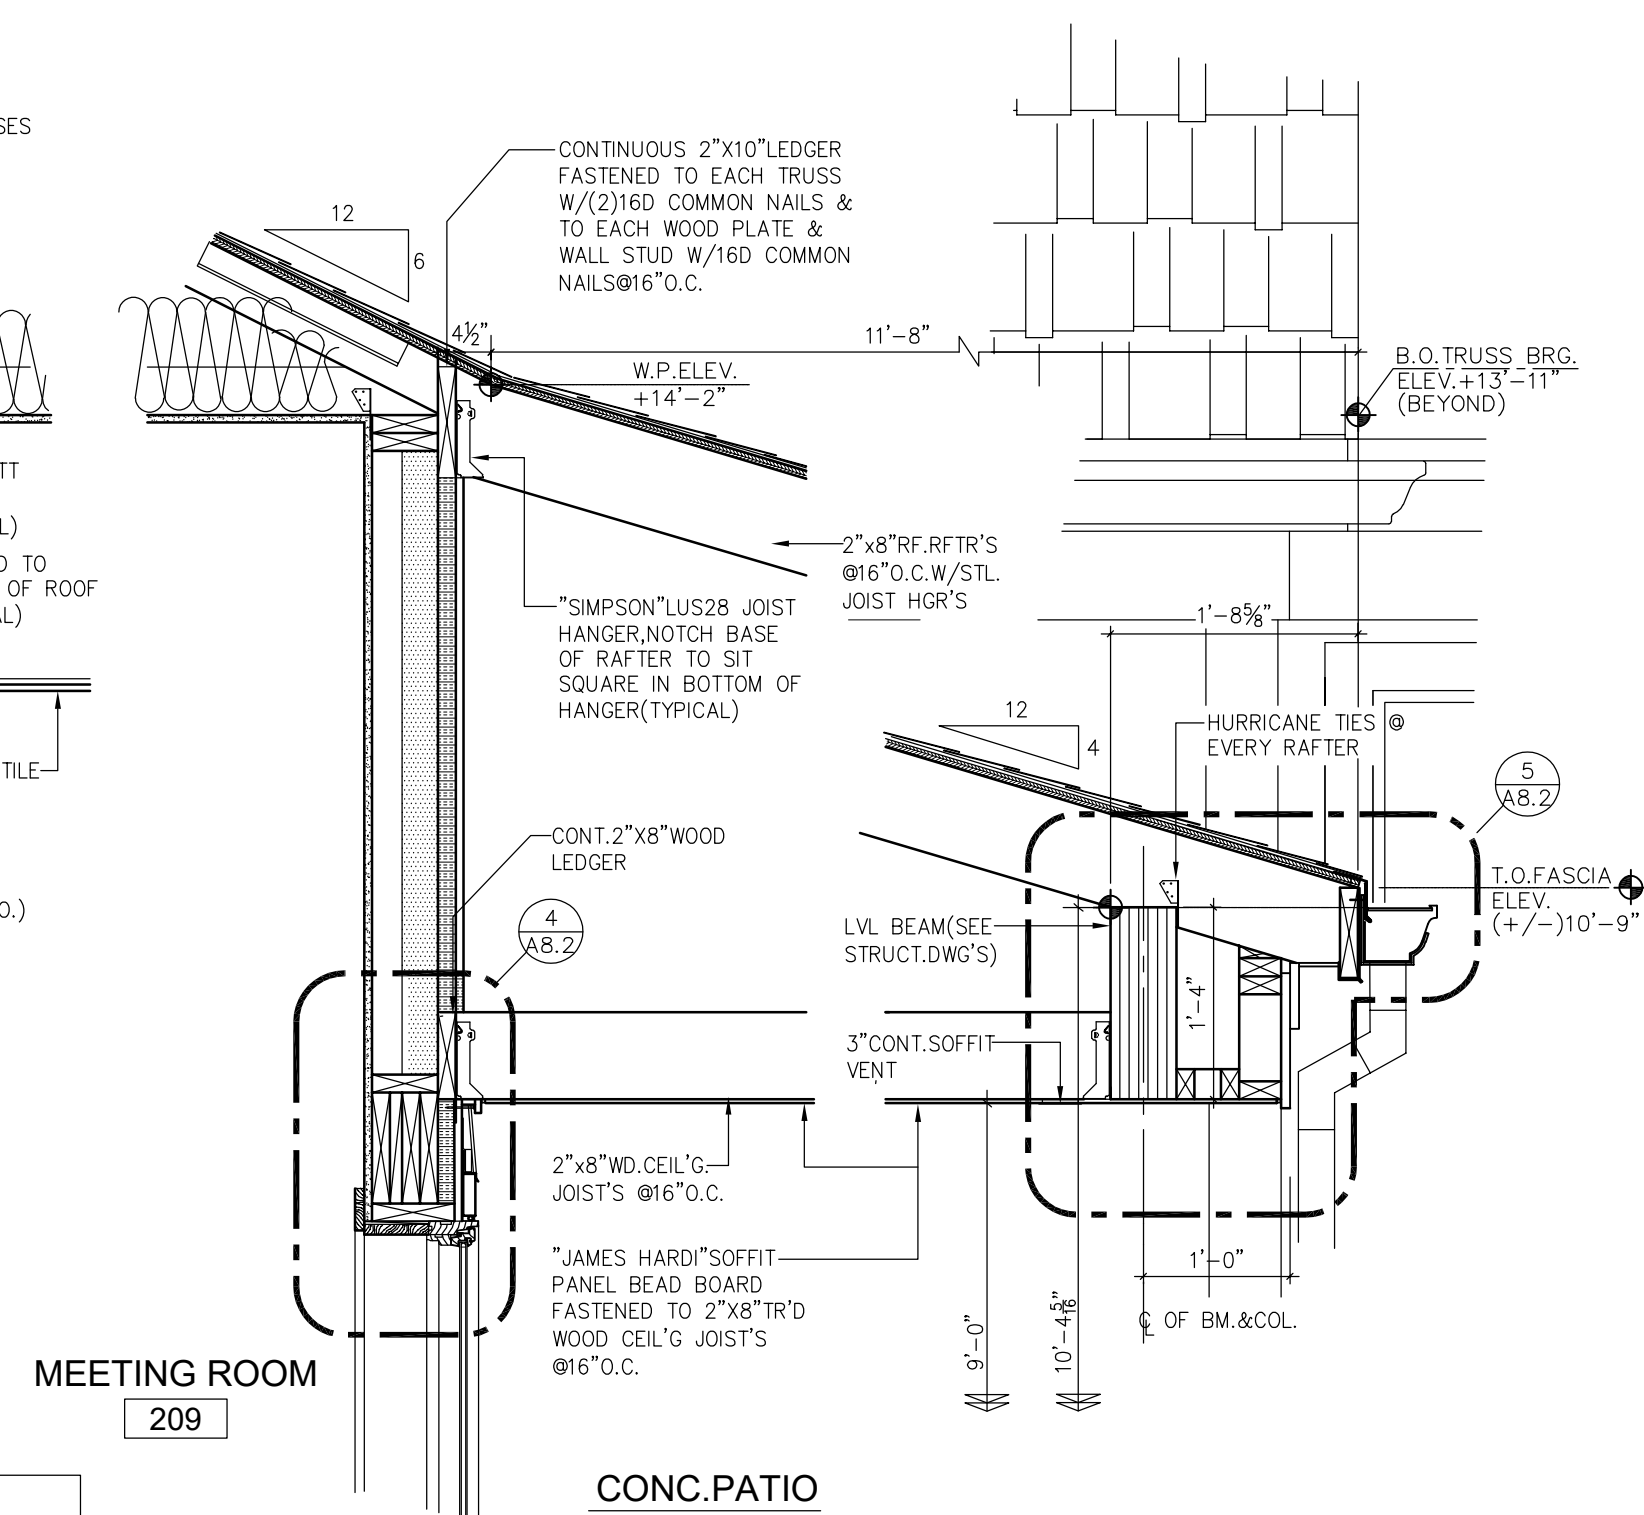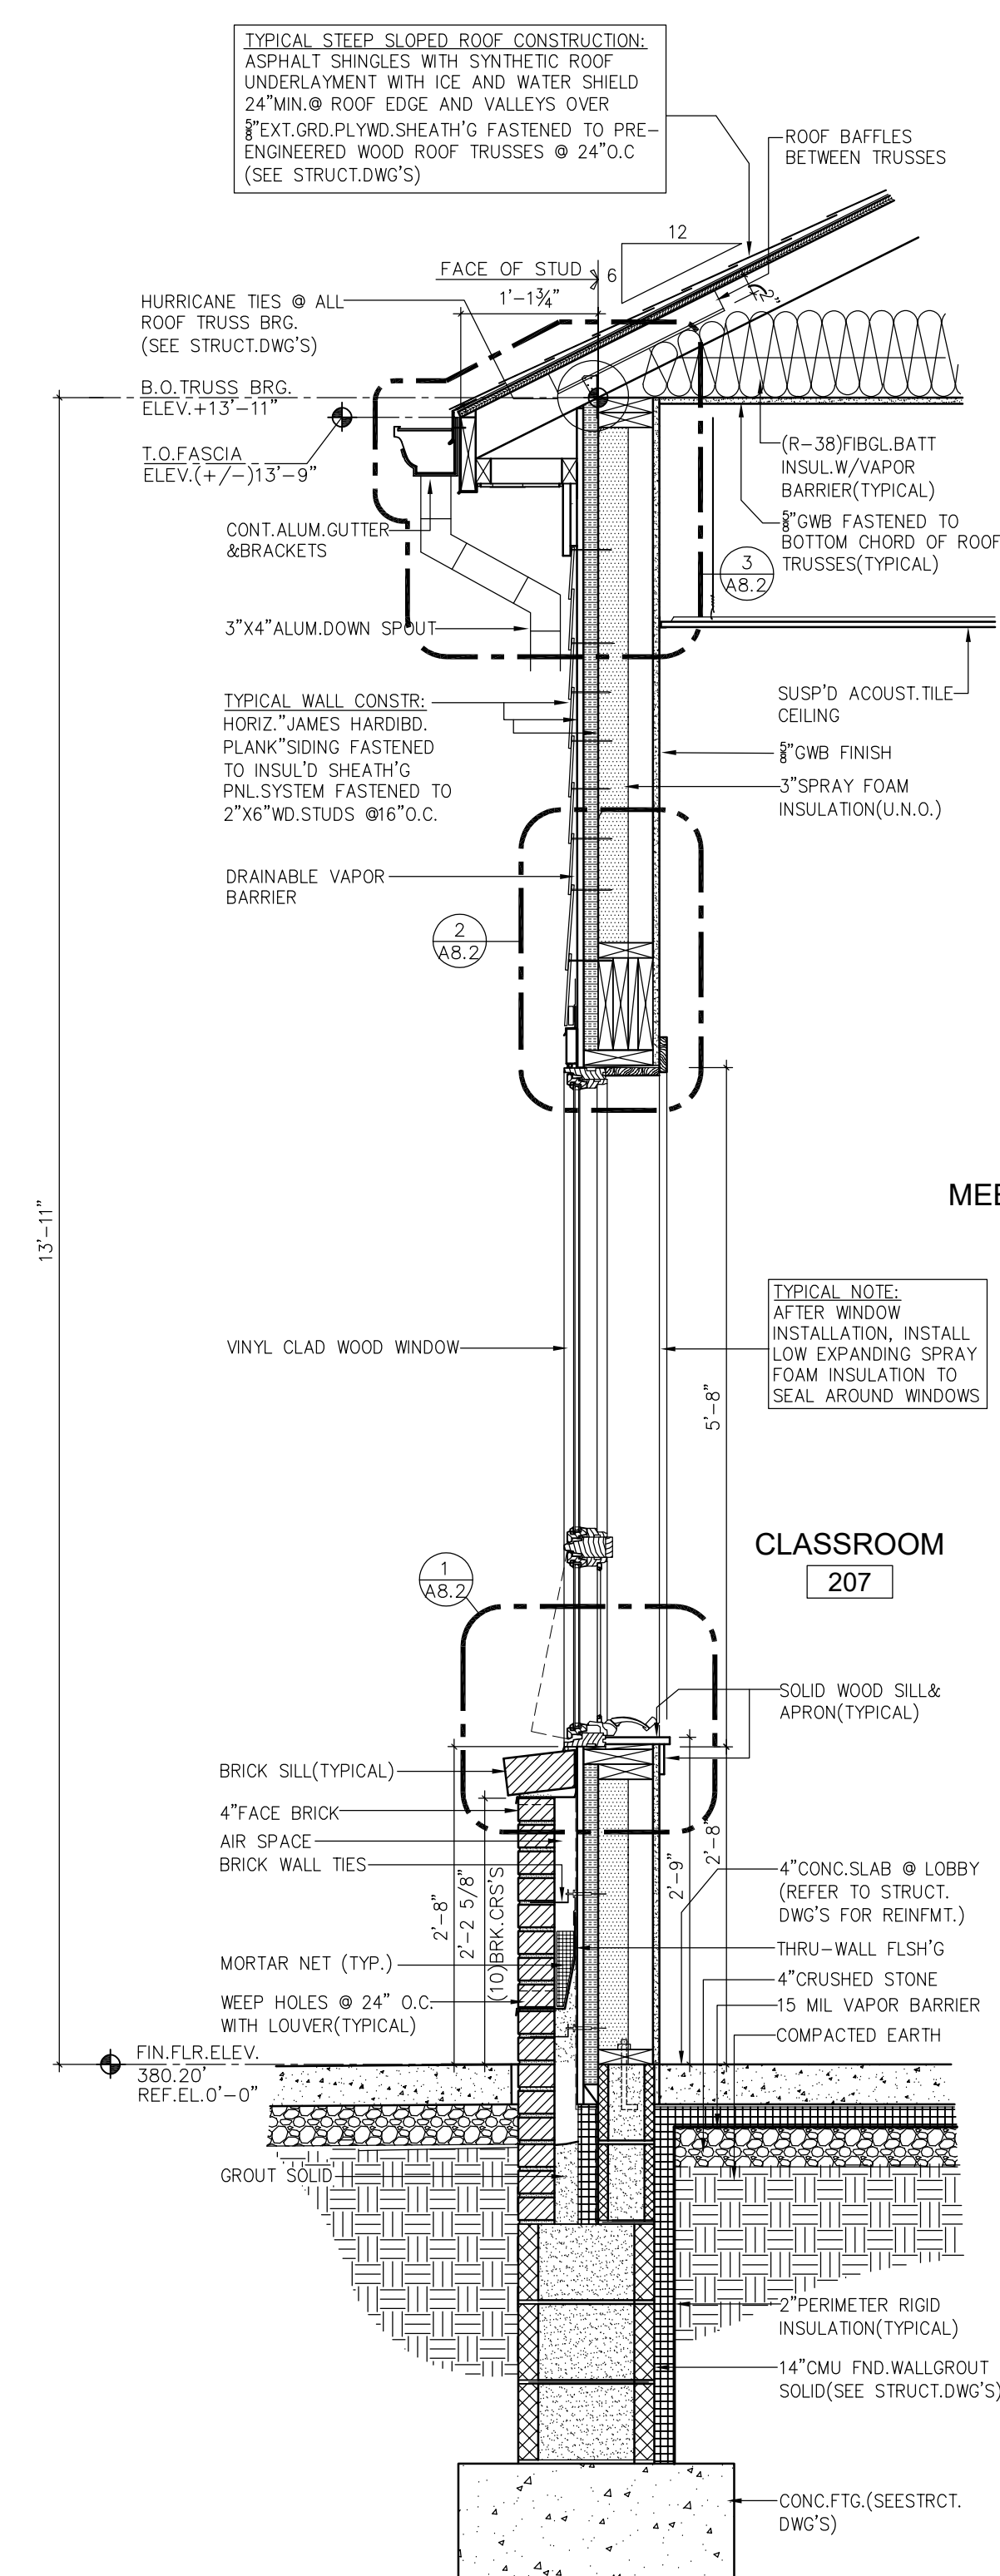

BID SET - APRIL 12, 2021

ADDITIONS AND RENOVATIONS FOR

CHURCH OF THE
HOLY SPIRIT

2871 BARNDT ROAD, HARLEYSVILLE, PA, 19438

CONSULTANTS

STAMP

GODSHALL KANE O'ROURKE ARCHITECTS, LLC

3300 Brookside Avenue
Aptler Verde - Building 18 - Suite 150

300 Brookside Avenue
Ambler Yards - Building 18 - Suite 150

T: 215.646.2003 F: 215.646.5707 W: gkoarchitects.com



REVISION

4-12-2021	BID SE
-----------	--------

DRAWN BY

RECEIVED BY


JOB #

QUEST TO


WALL SECTIONS & DETAILS

A4.2


SCALE	AS NOTED
DATE	4-12-2021

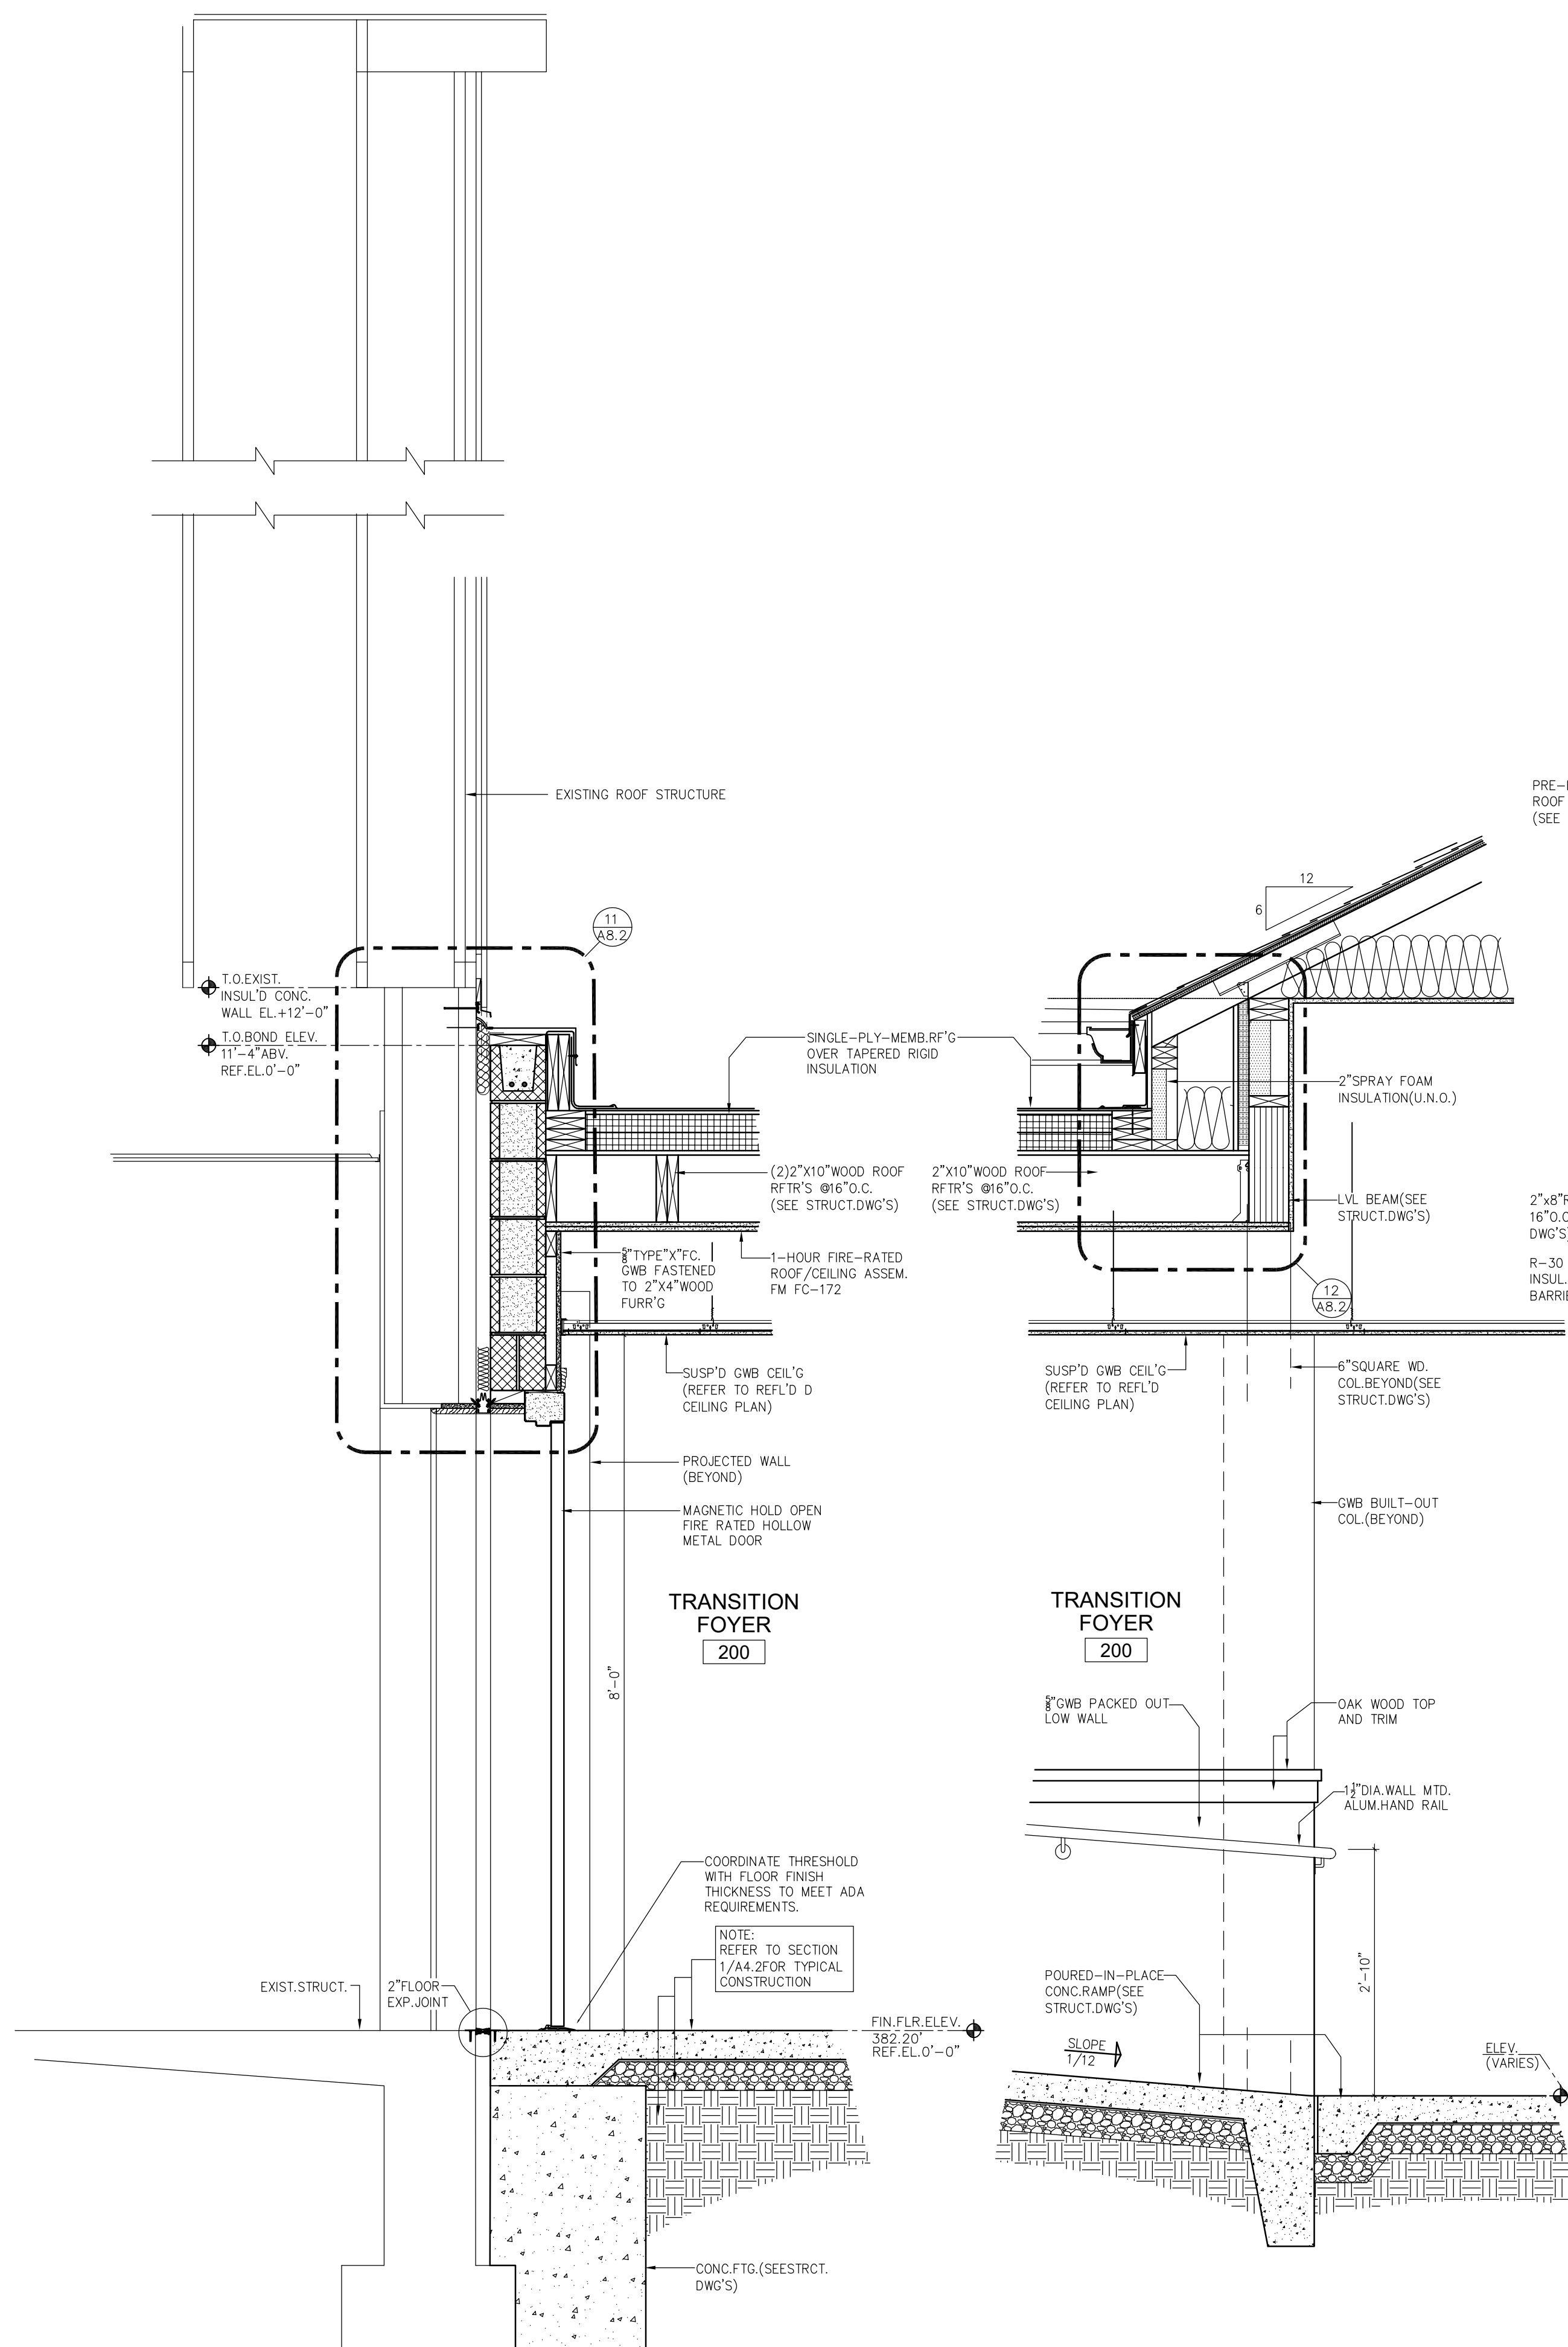


6 WALL SECTION
A4.3 SCALE: 3/4"=1'-0"

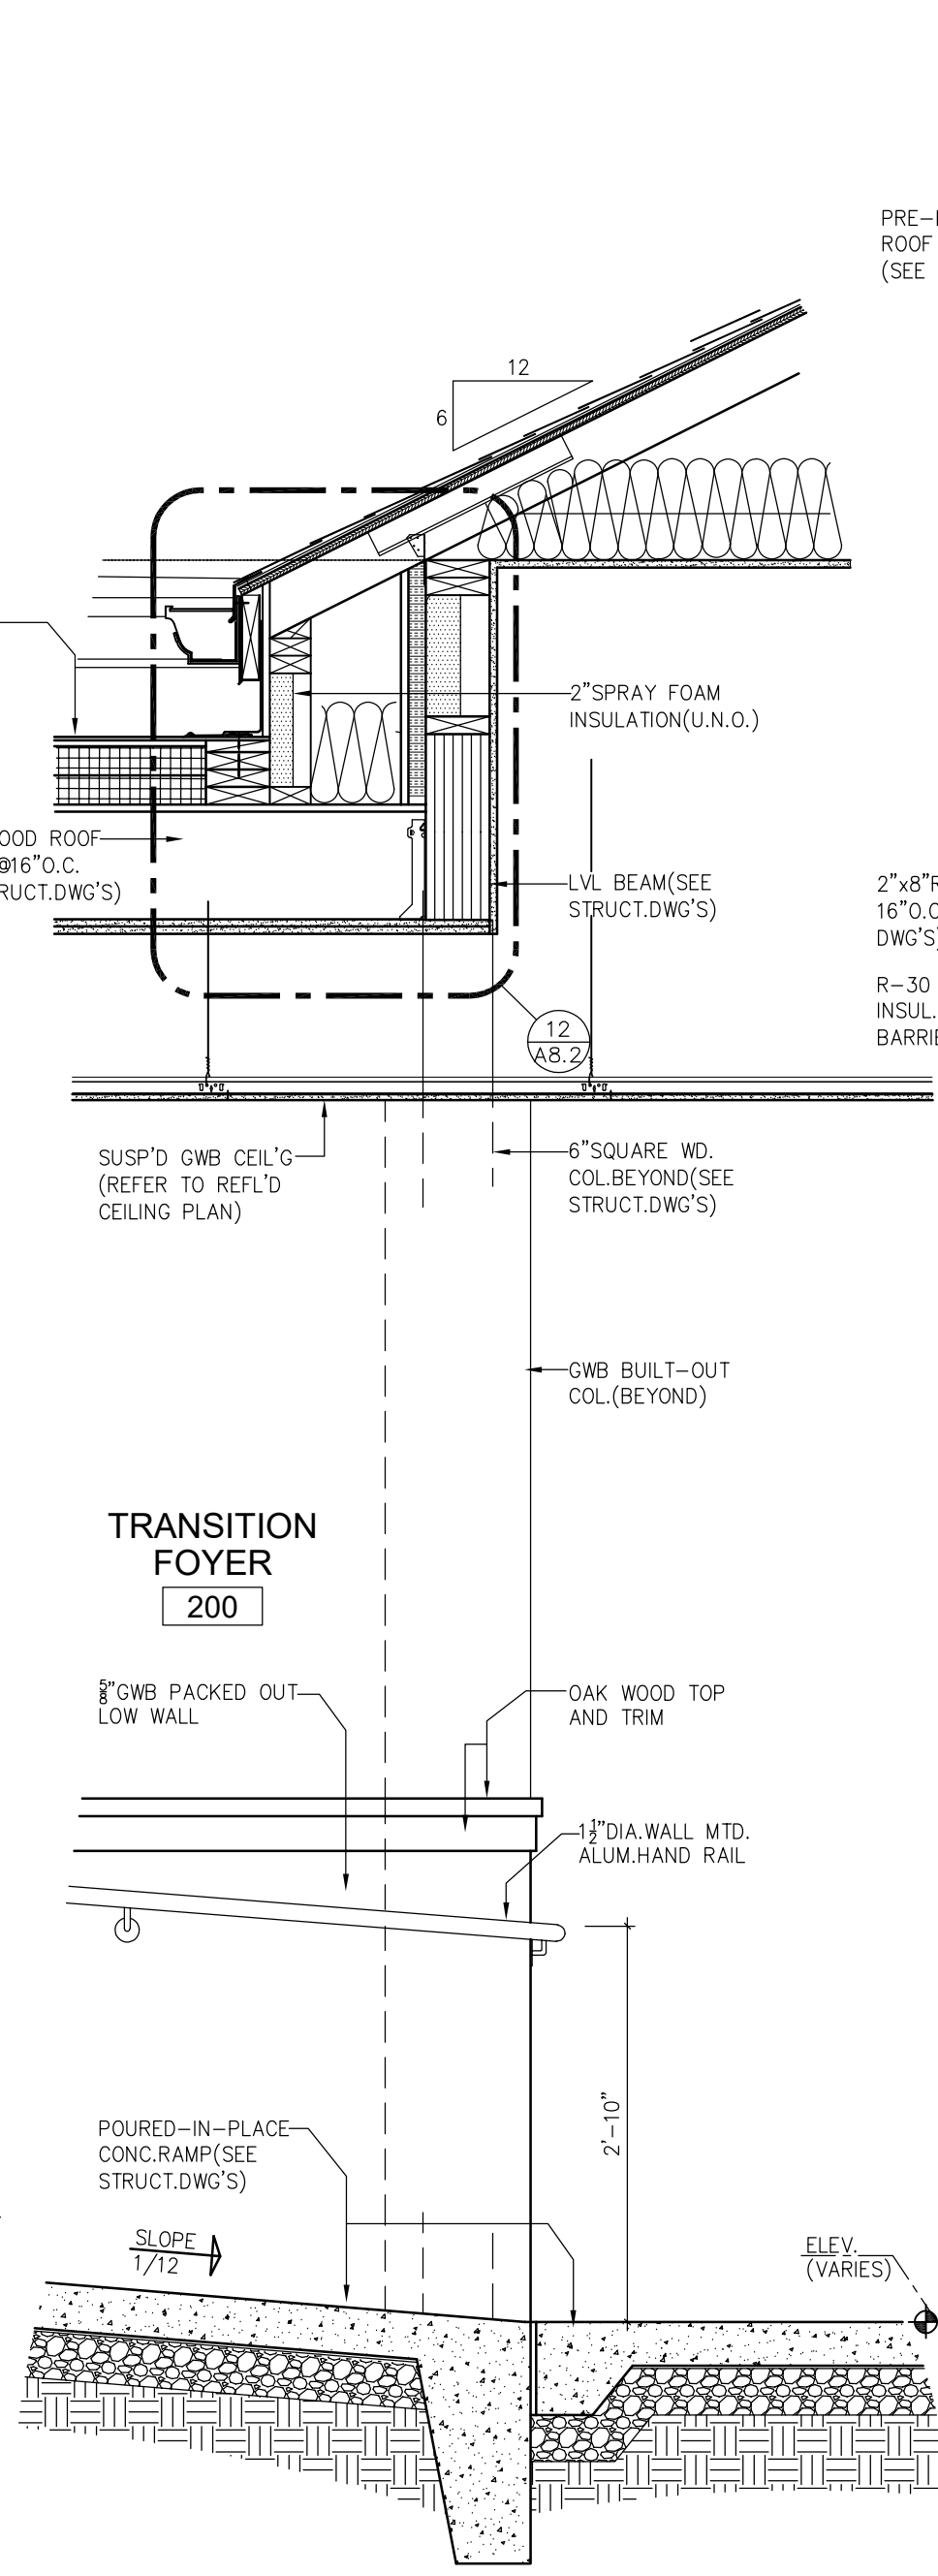


7 WALL SECTION
A4.3 SCALE: 3/4"=1'-0"

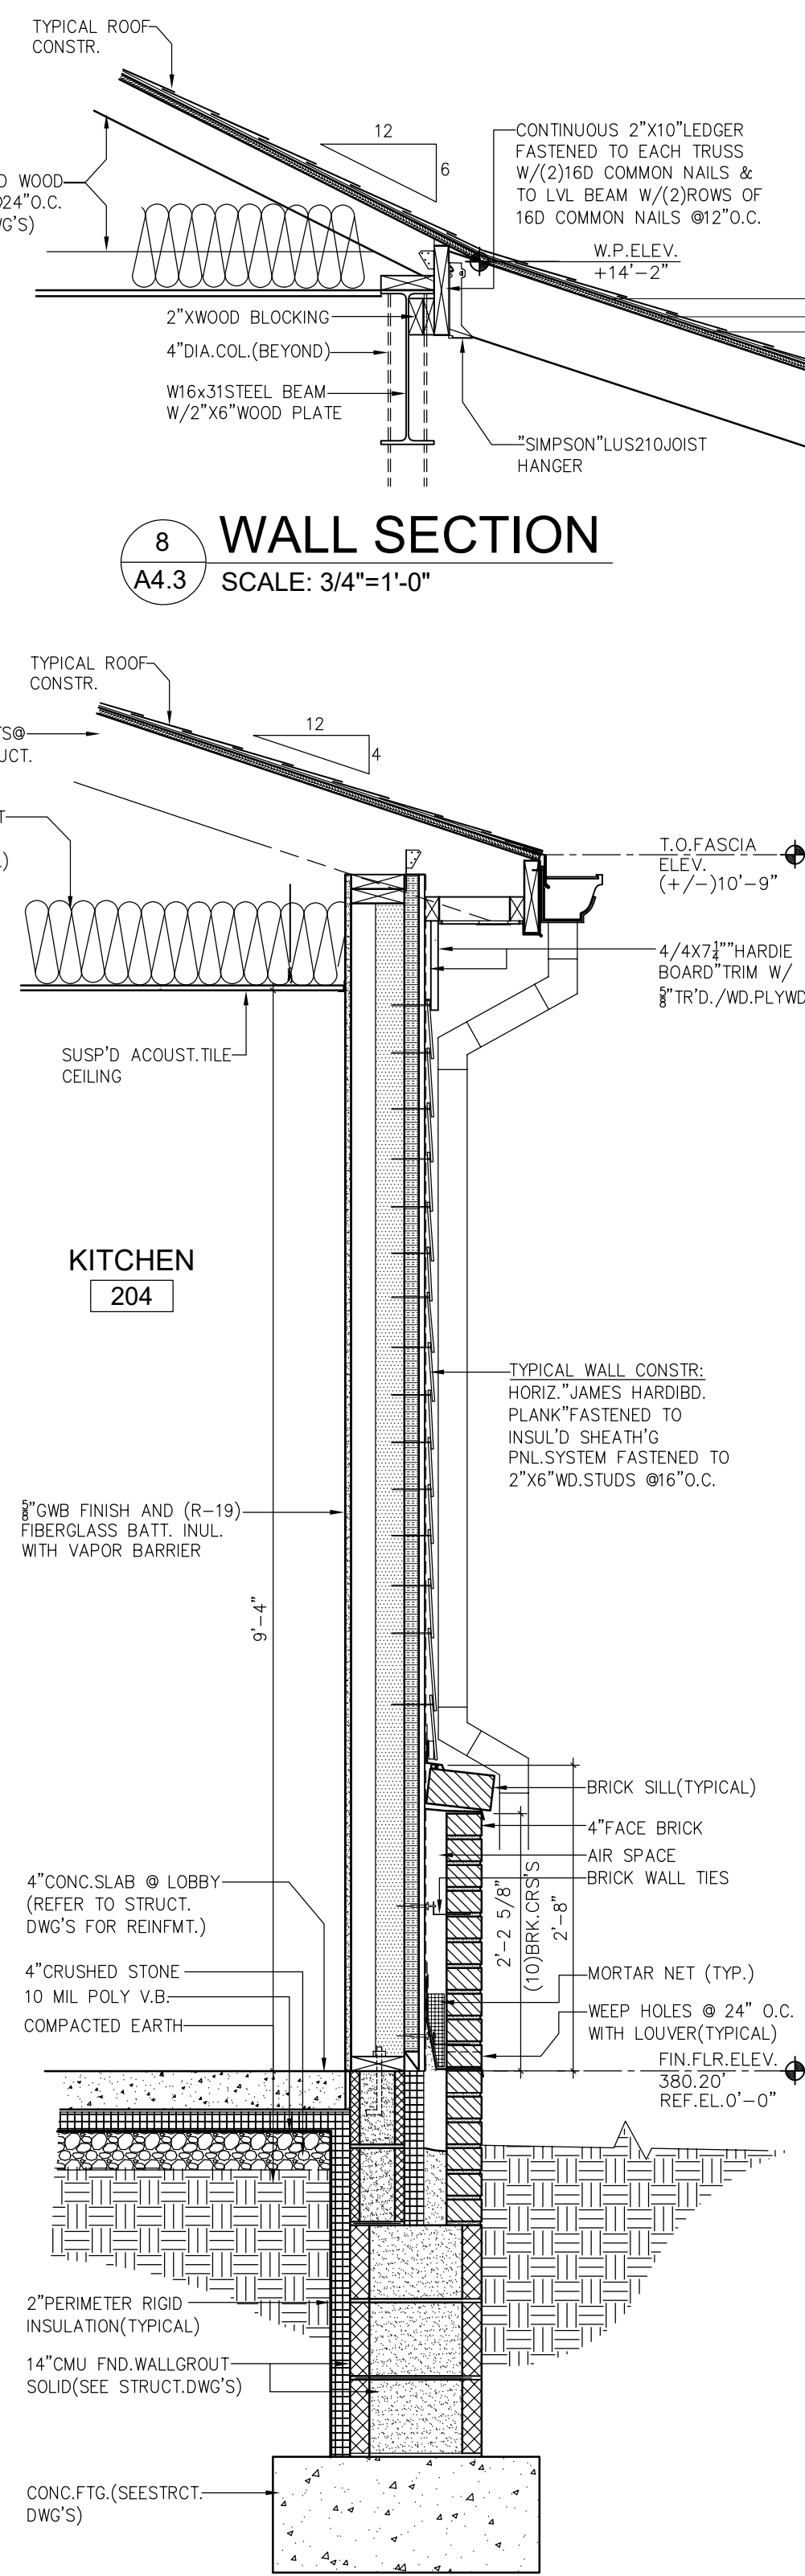


9 WALL SECTION
A4.3 SCALE: 3/4"=1'-0"

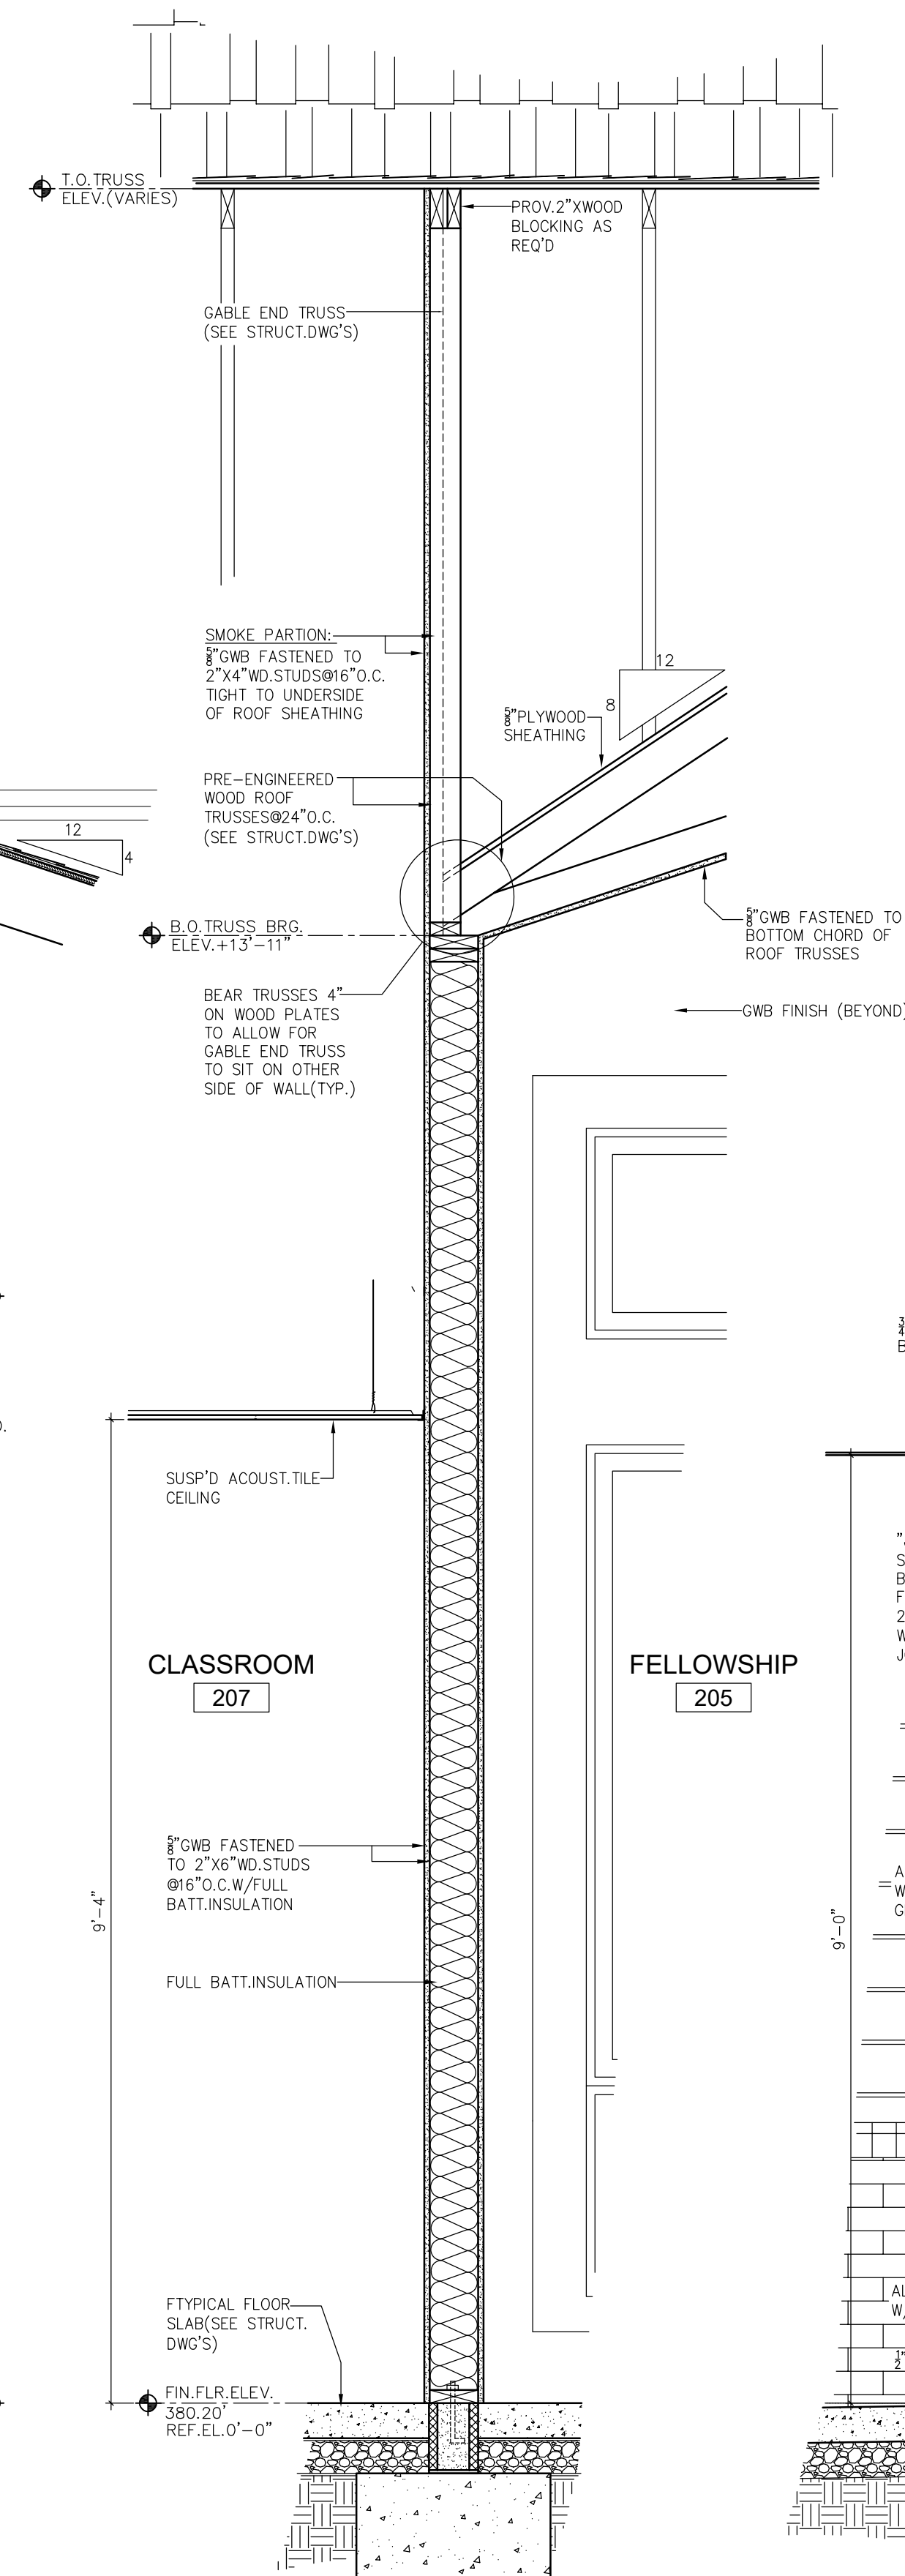

10 WALL SECTION
A4.3 SCALE: 3/4"=1'-0"

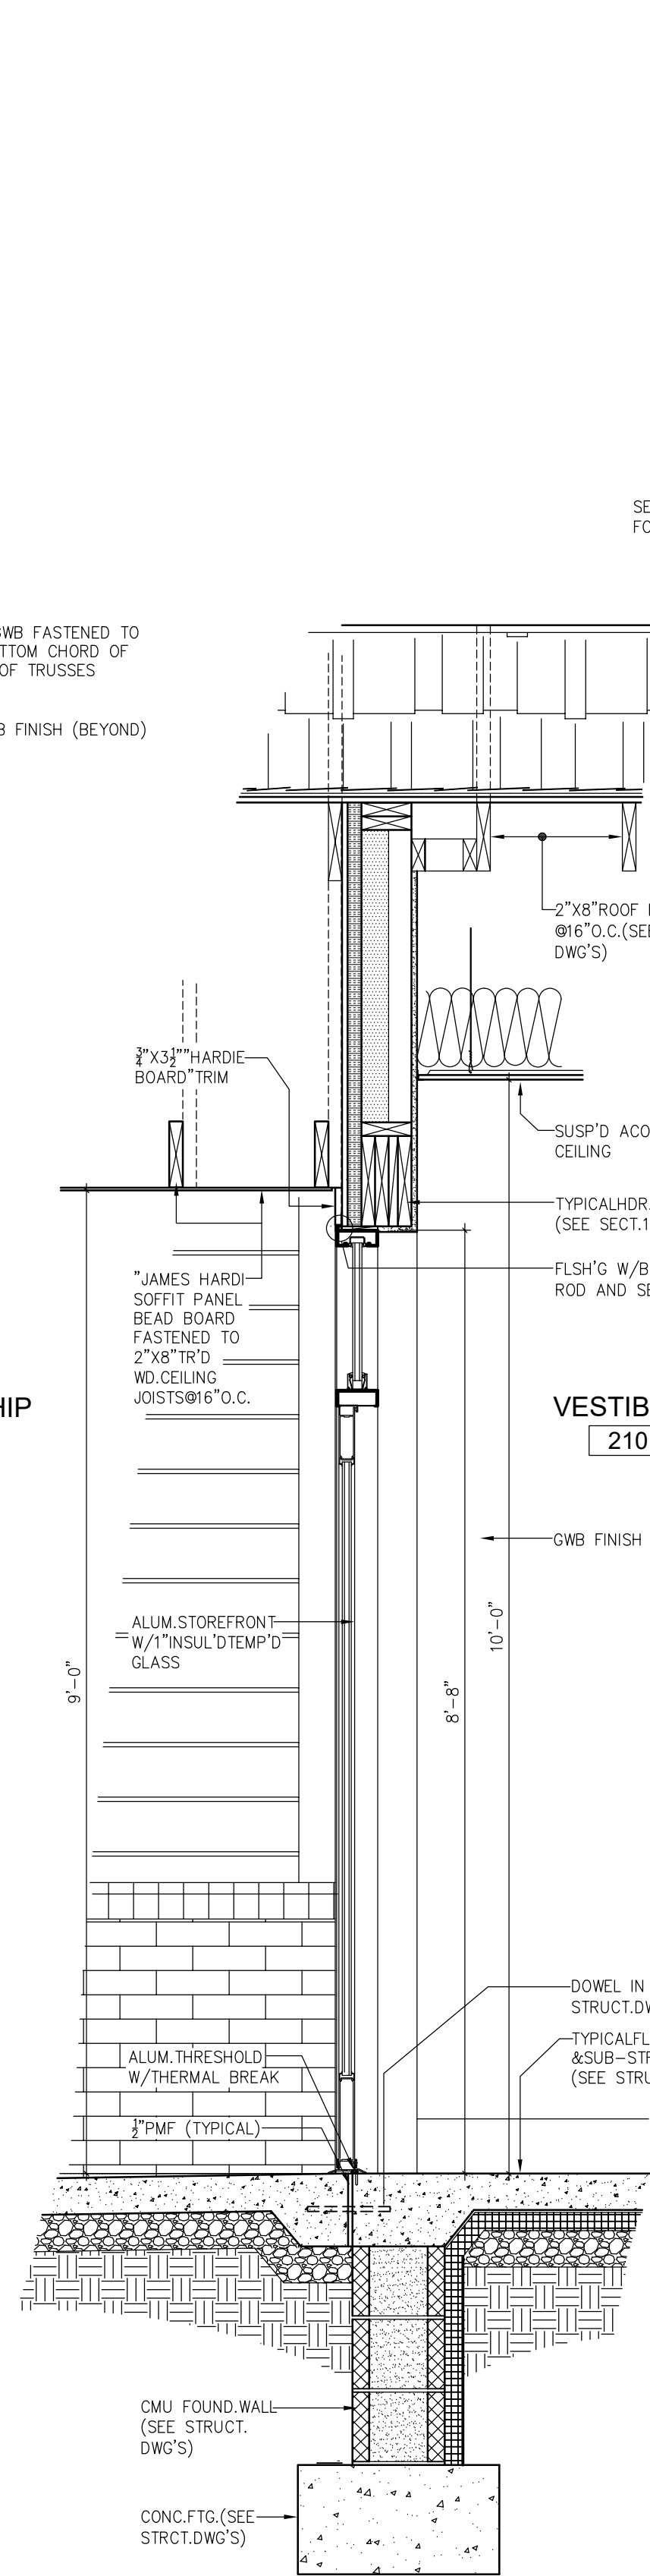

11 WALL SECTION
A4.3 SCALE: 3/4"=1'-0"

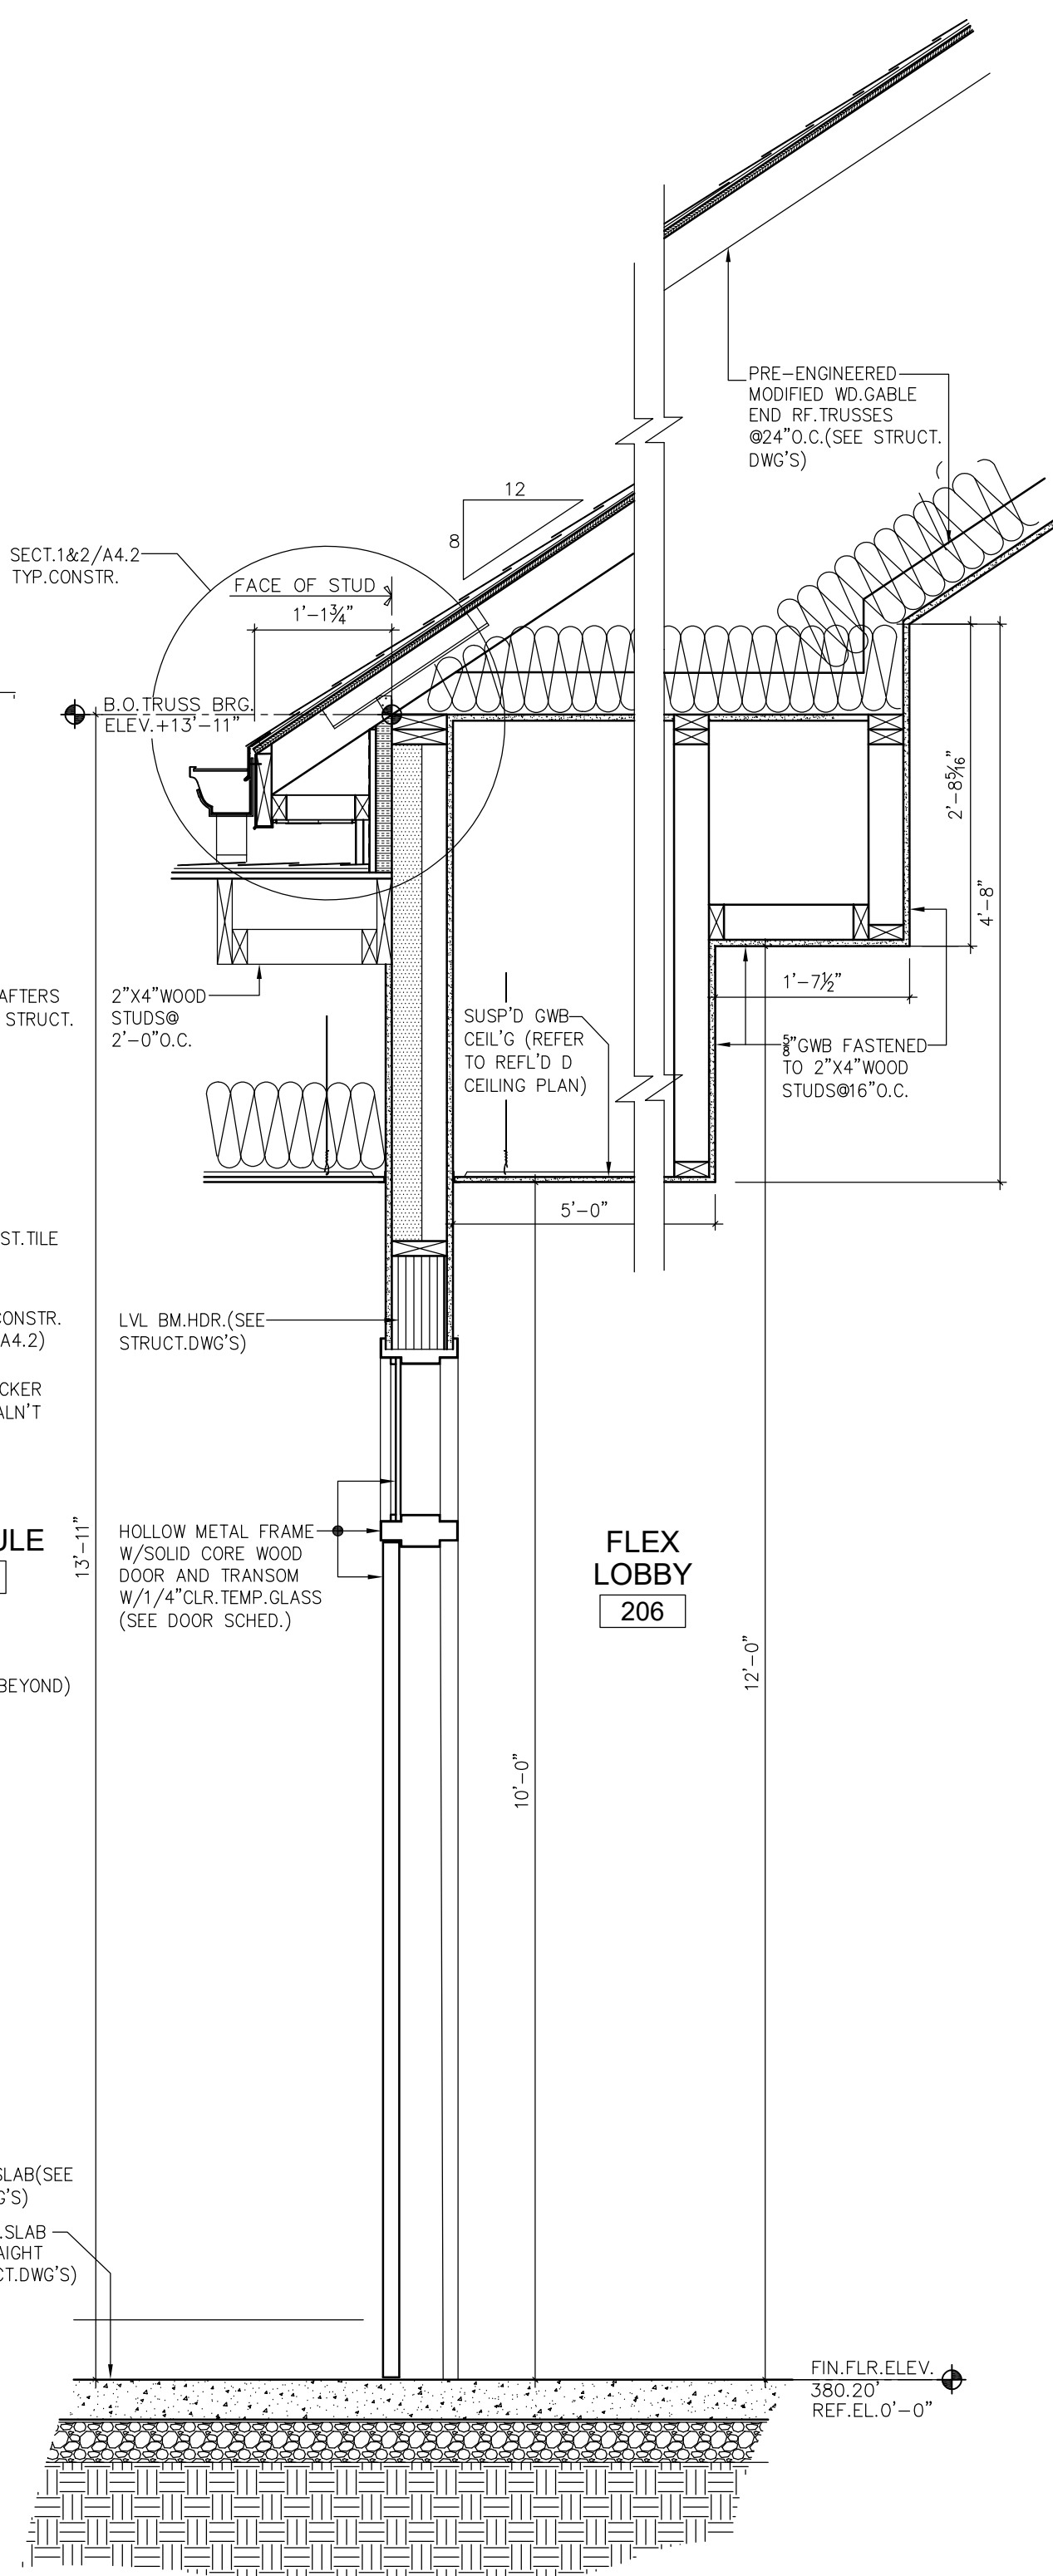

12 WALL SECTION
A4.3 SCALE: 3/4"=1'-0"

BID SET - APRIL 12, 2021

ADDITIONS AND RENOVATIONS FOR

CHURCH OF THE
HOLY SPIRIT

2871 BARNDT ROAD, HARLEYSVILLE, PA, 19438

REVISIONS	

WALL
SECTIONS &
DETAILS

SCALE	AS NOTED
DATE	4-12-2021

GODSHALL KANE O'ROURKE ARCHITECTS, LLC

300 Brookside Avenue






Harleysville, PA 17033


Amherst, PA 18802

T: 215.646.2003 F: 215.646.5707 W: gkoarchitects.com



GKO

ARCHITECTS

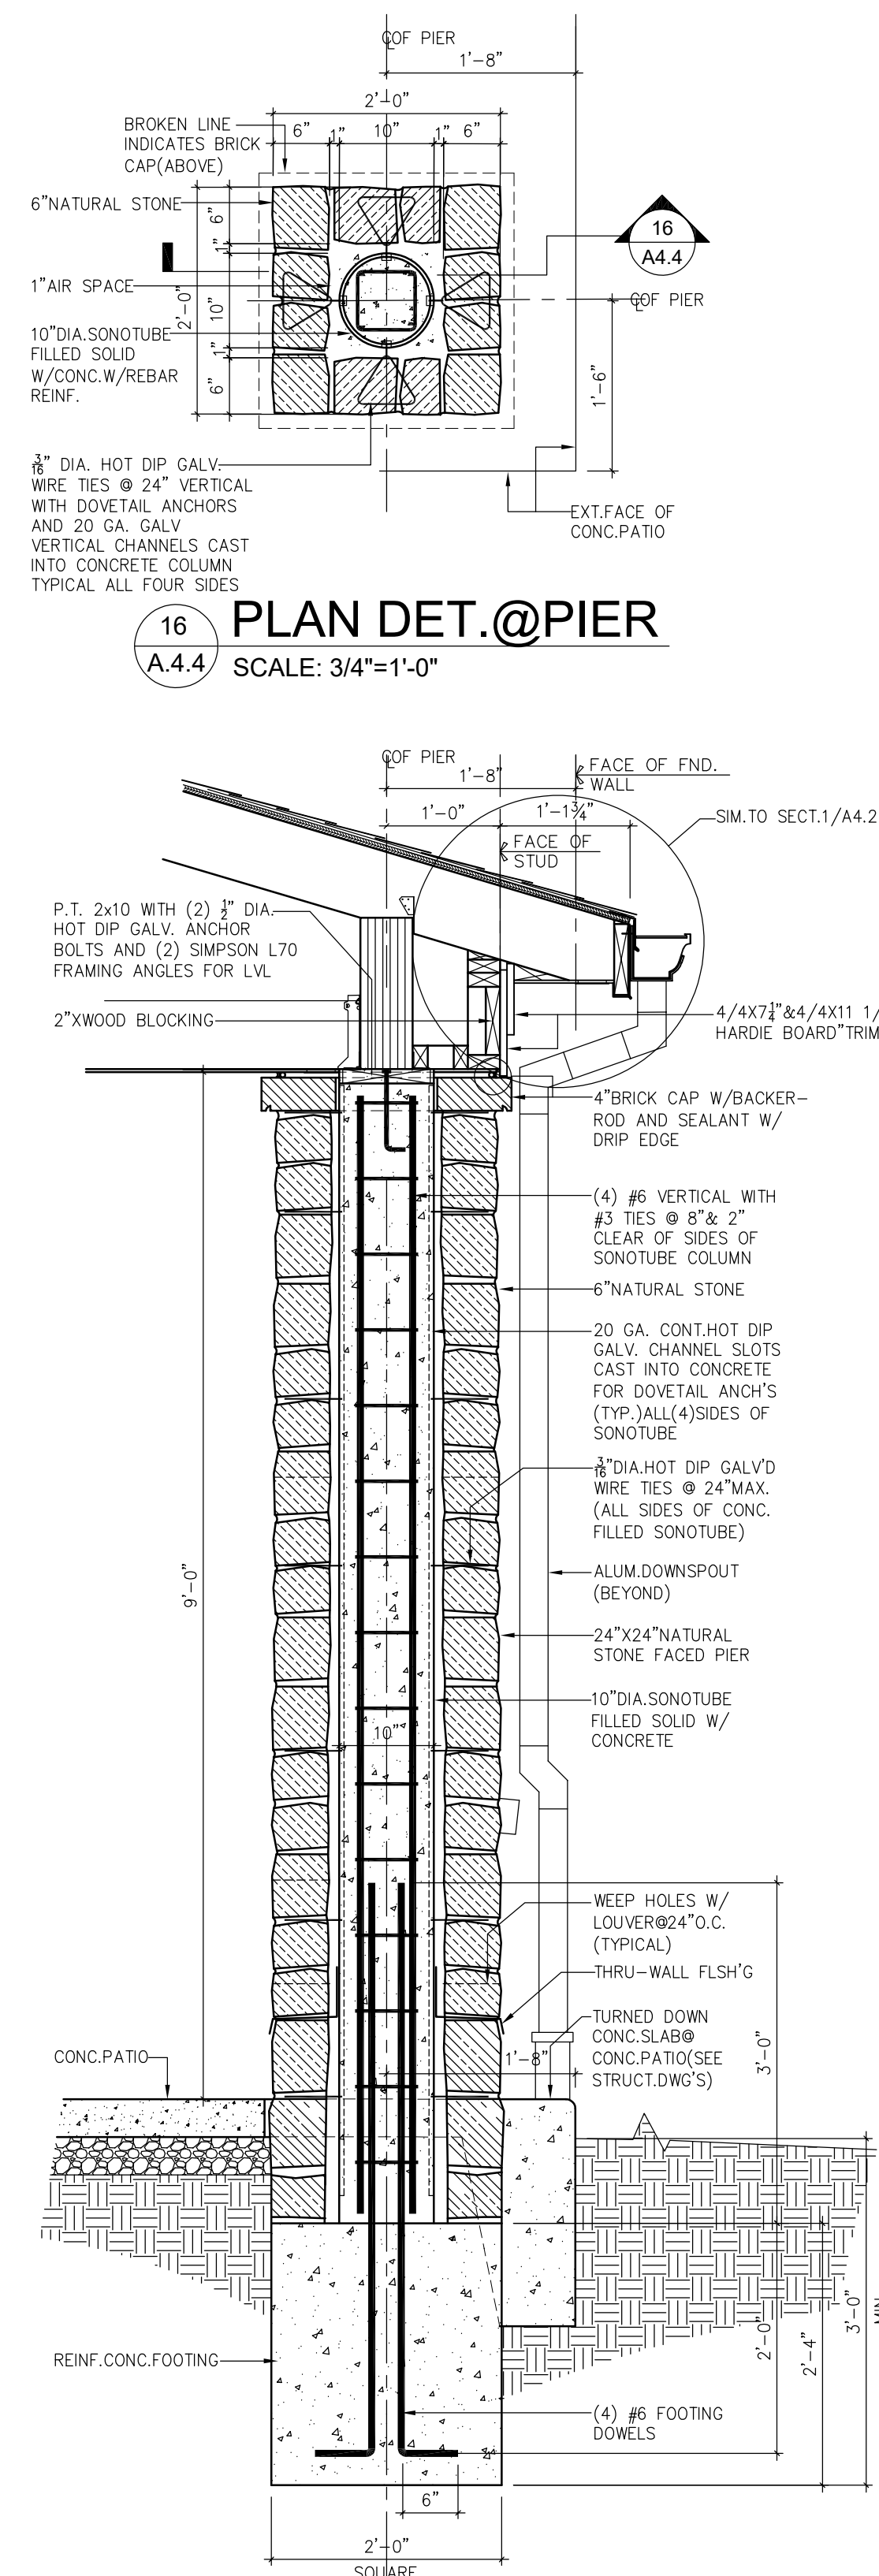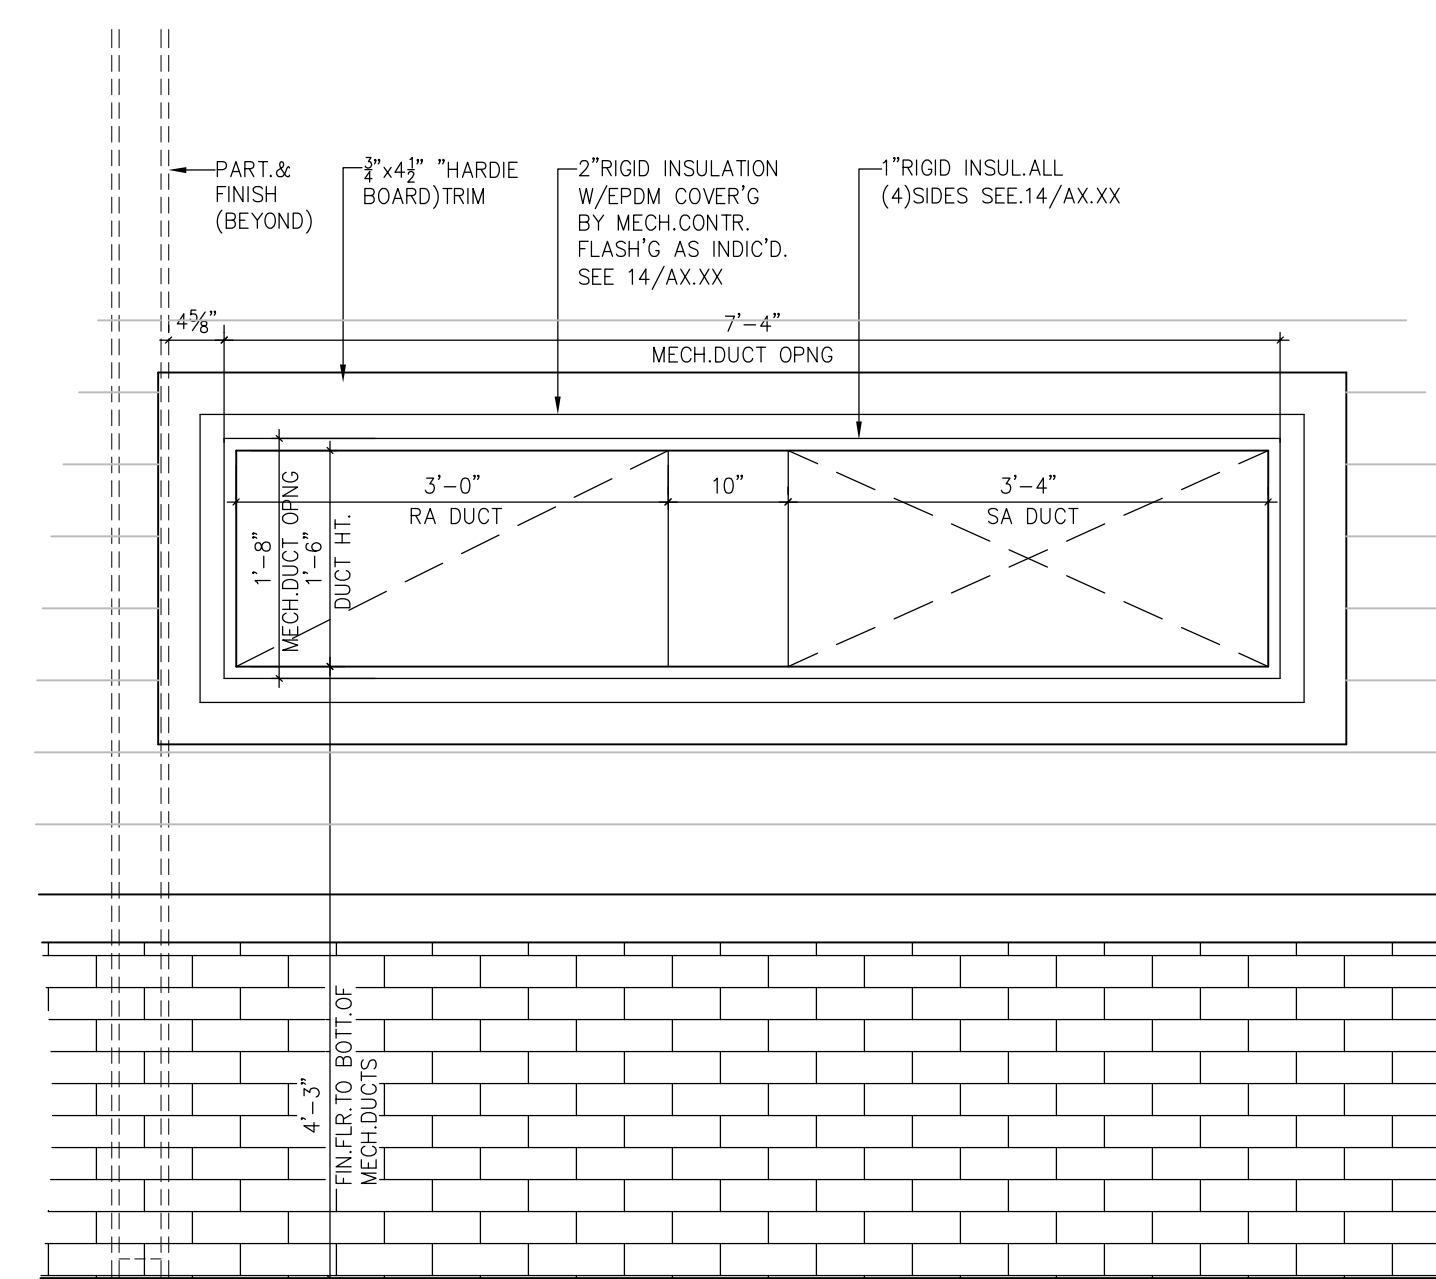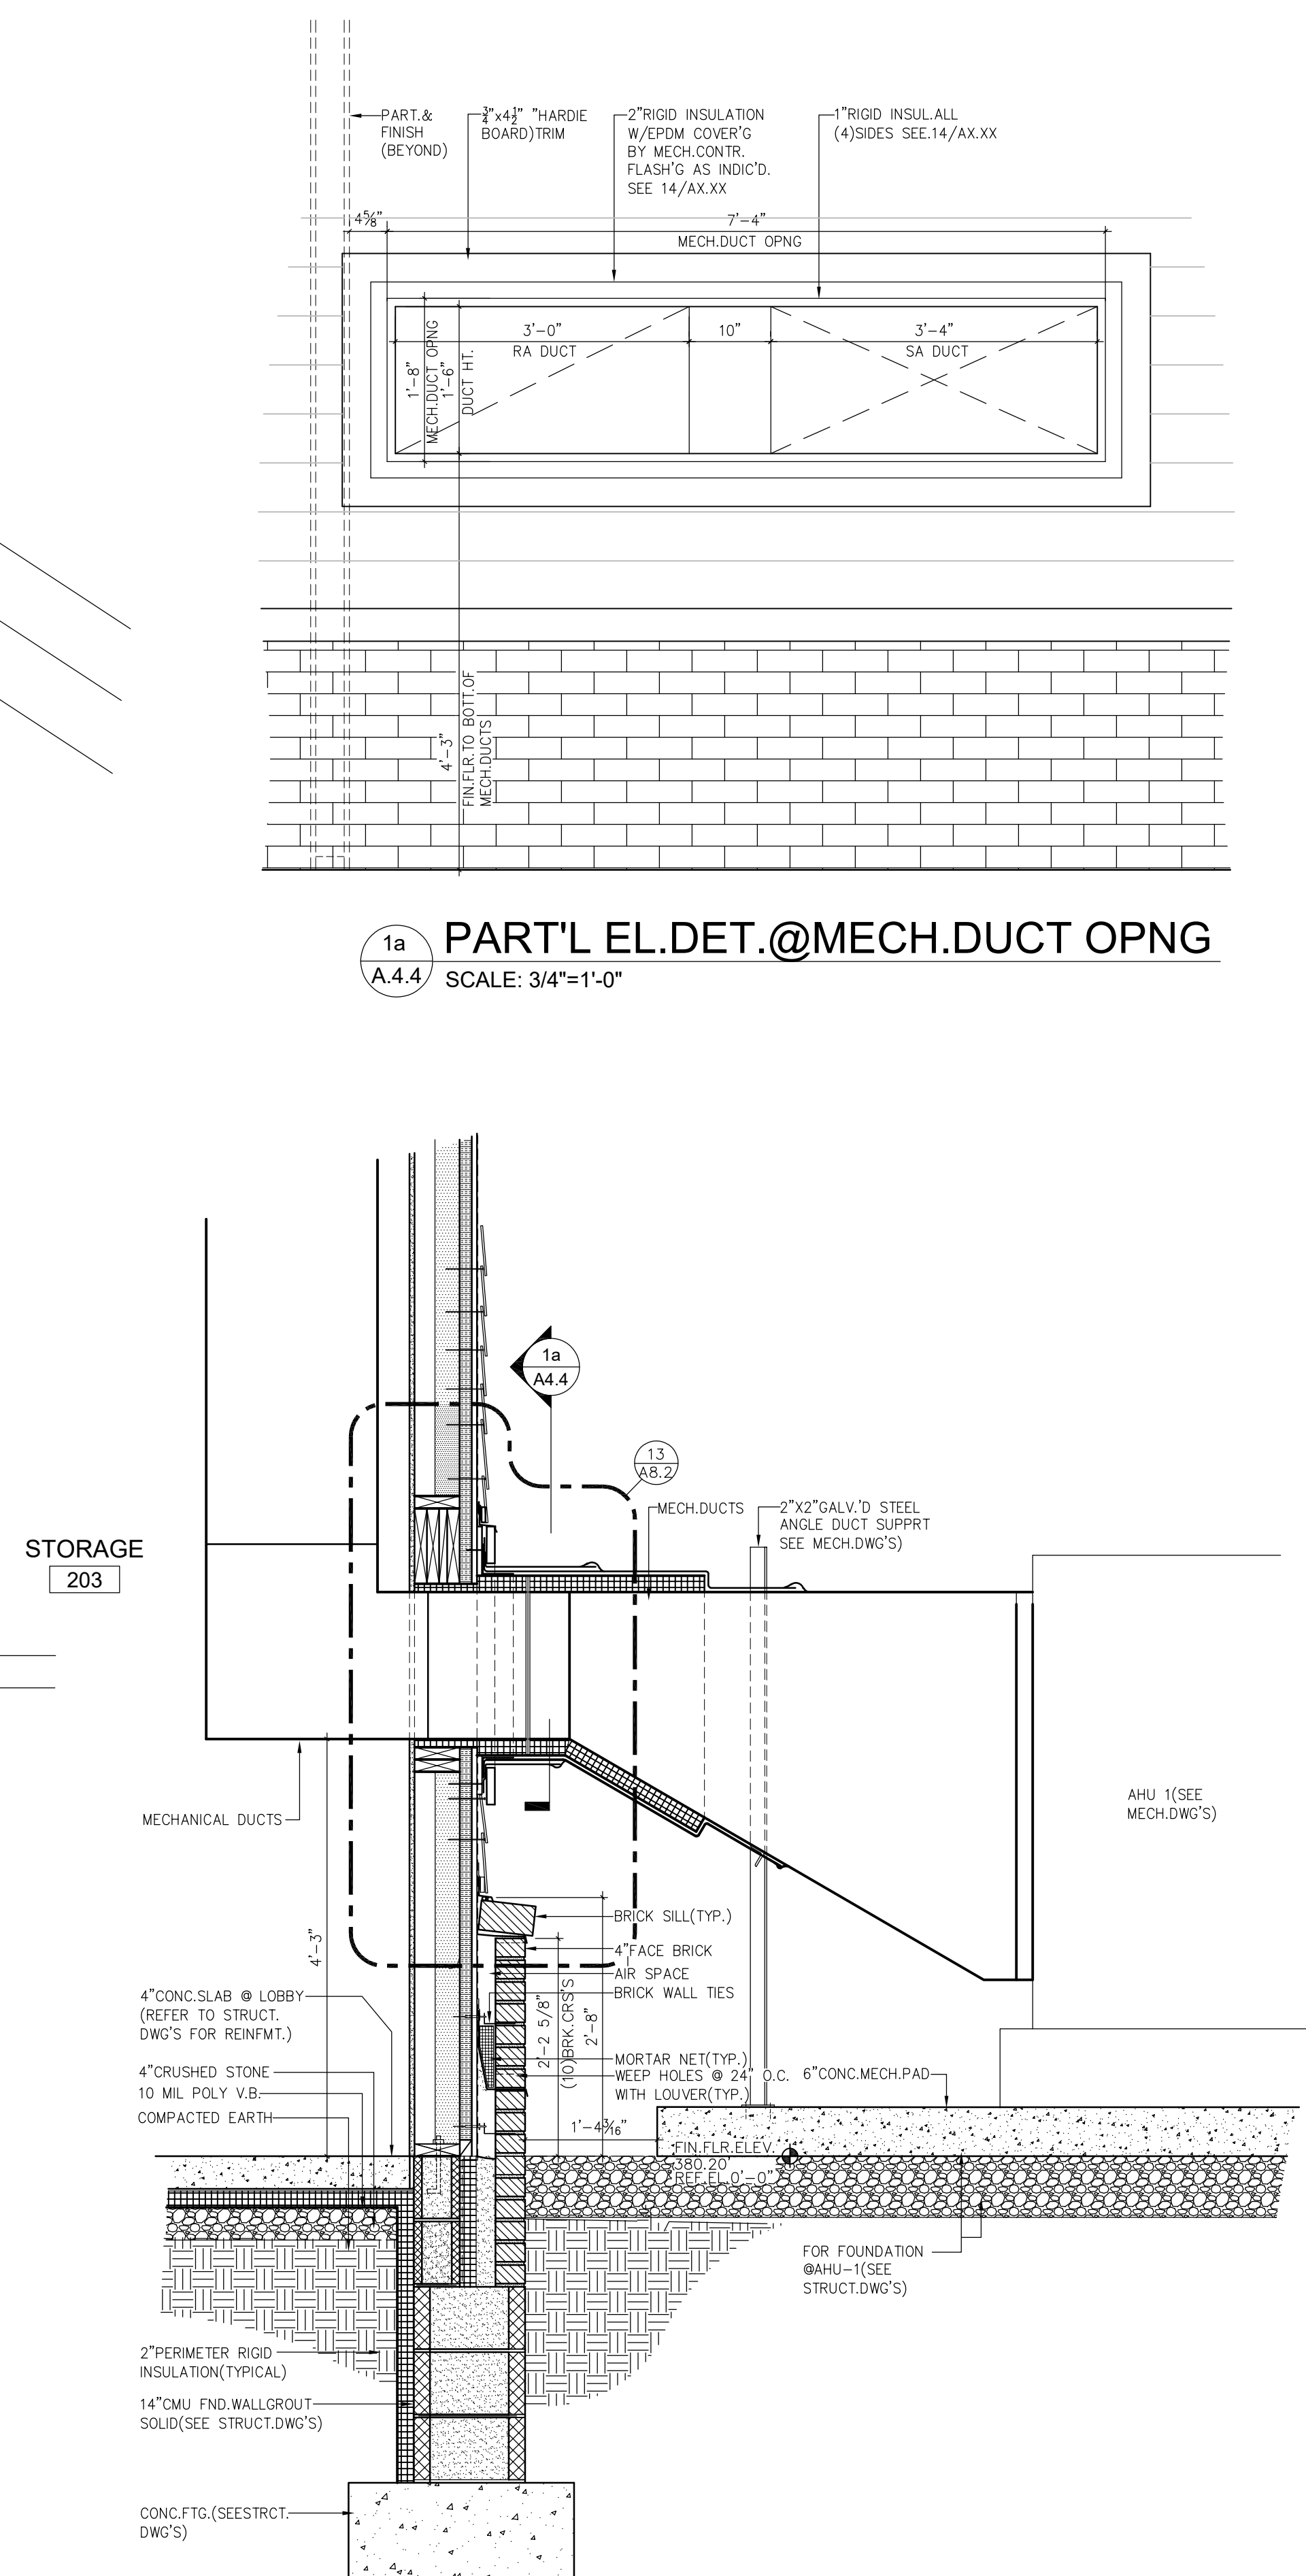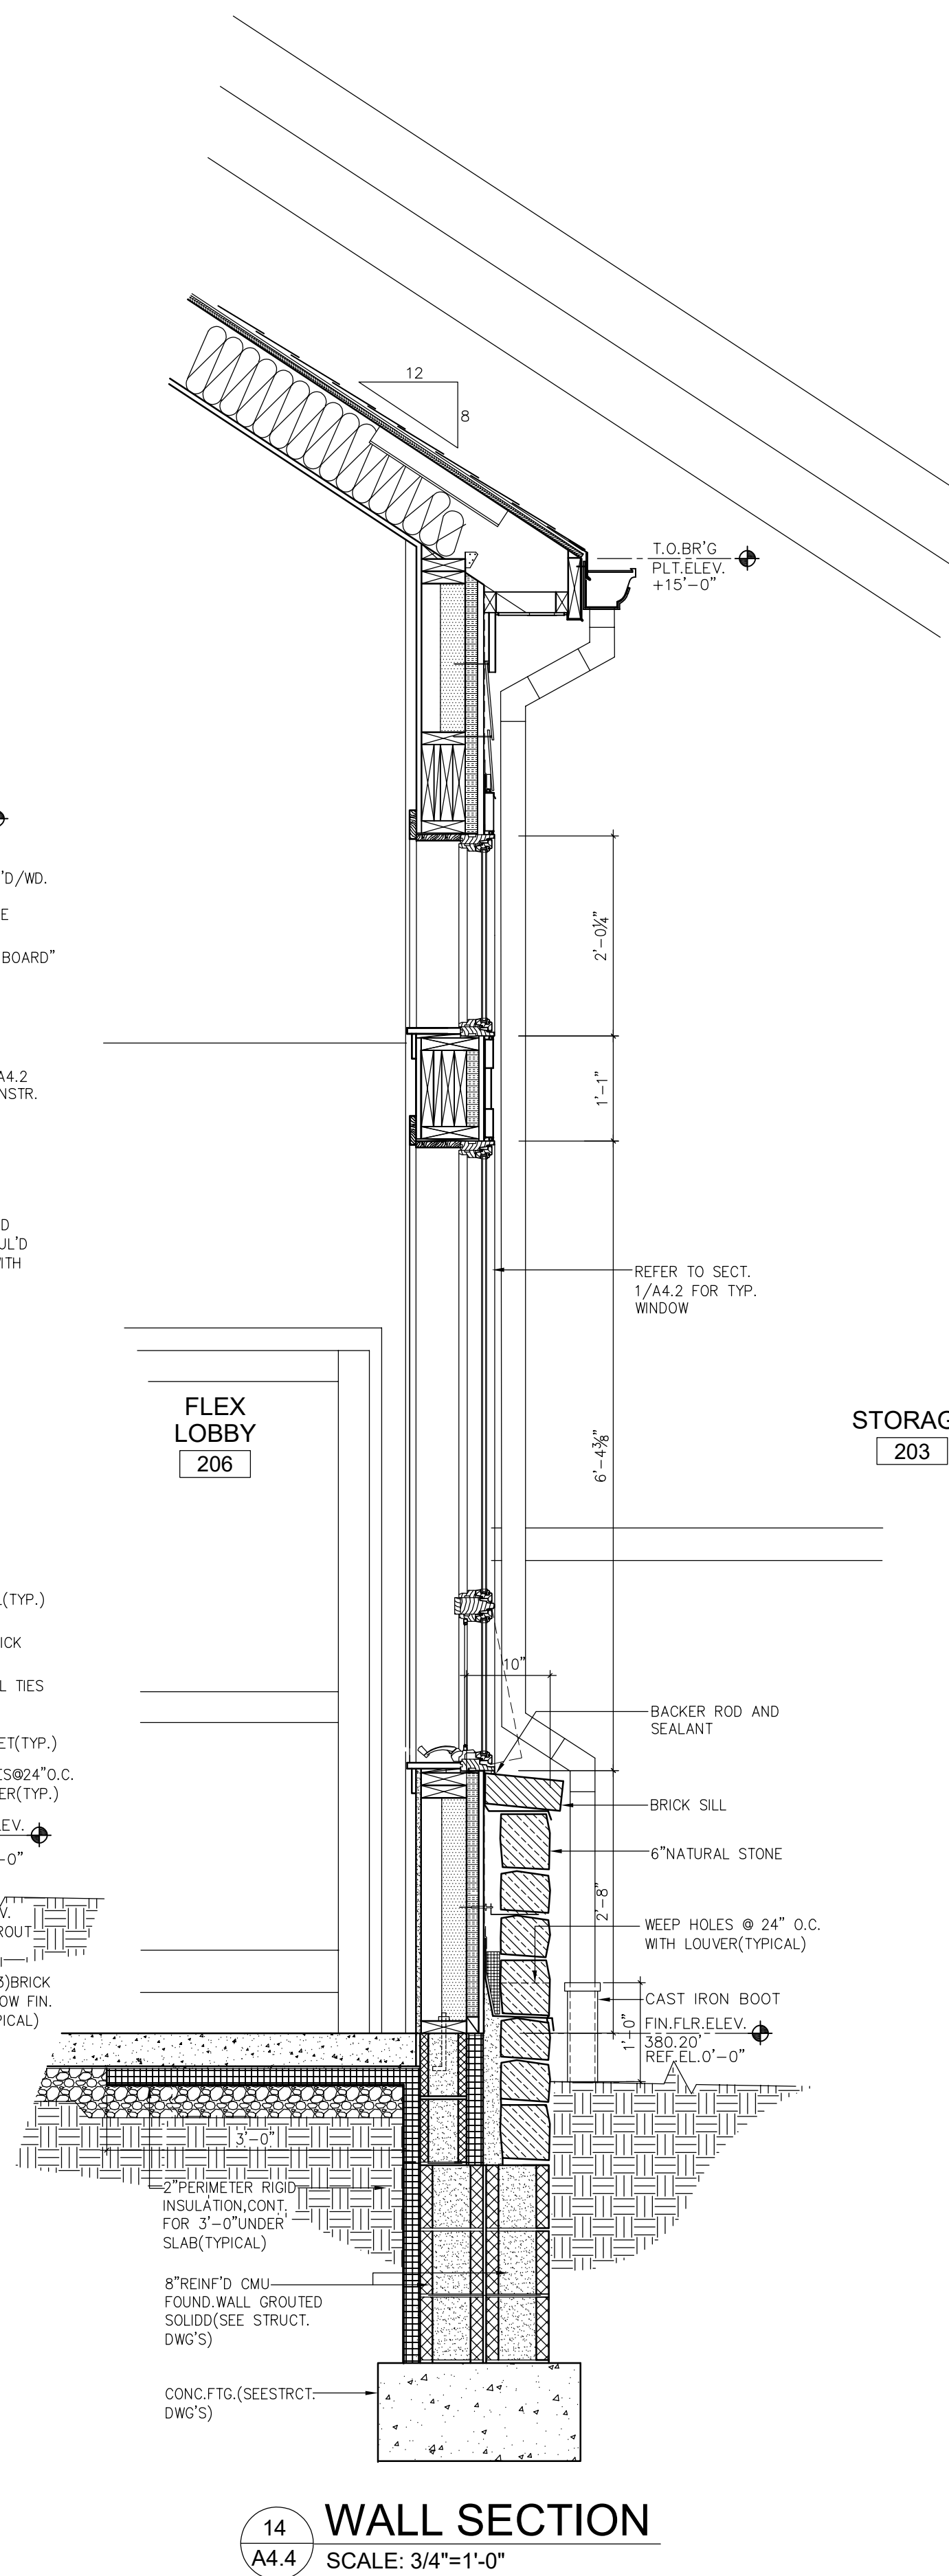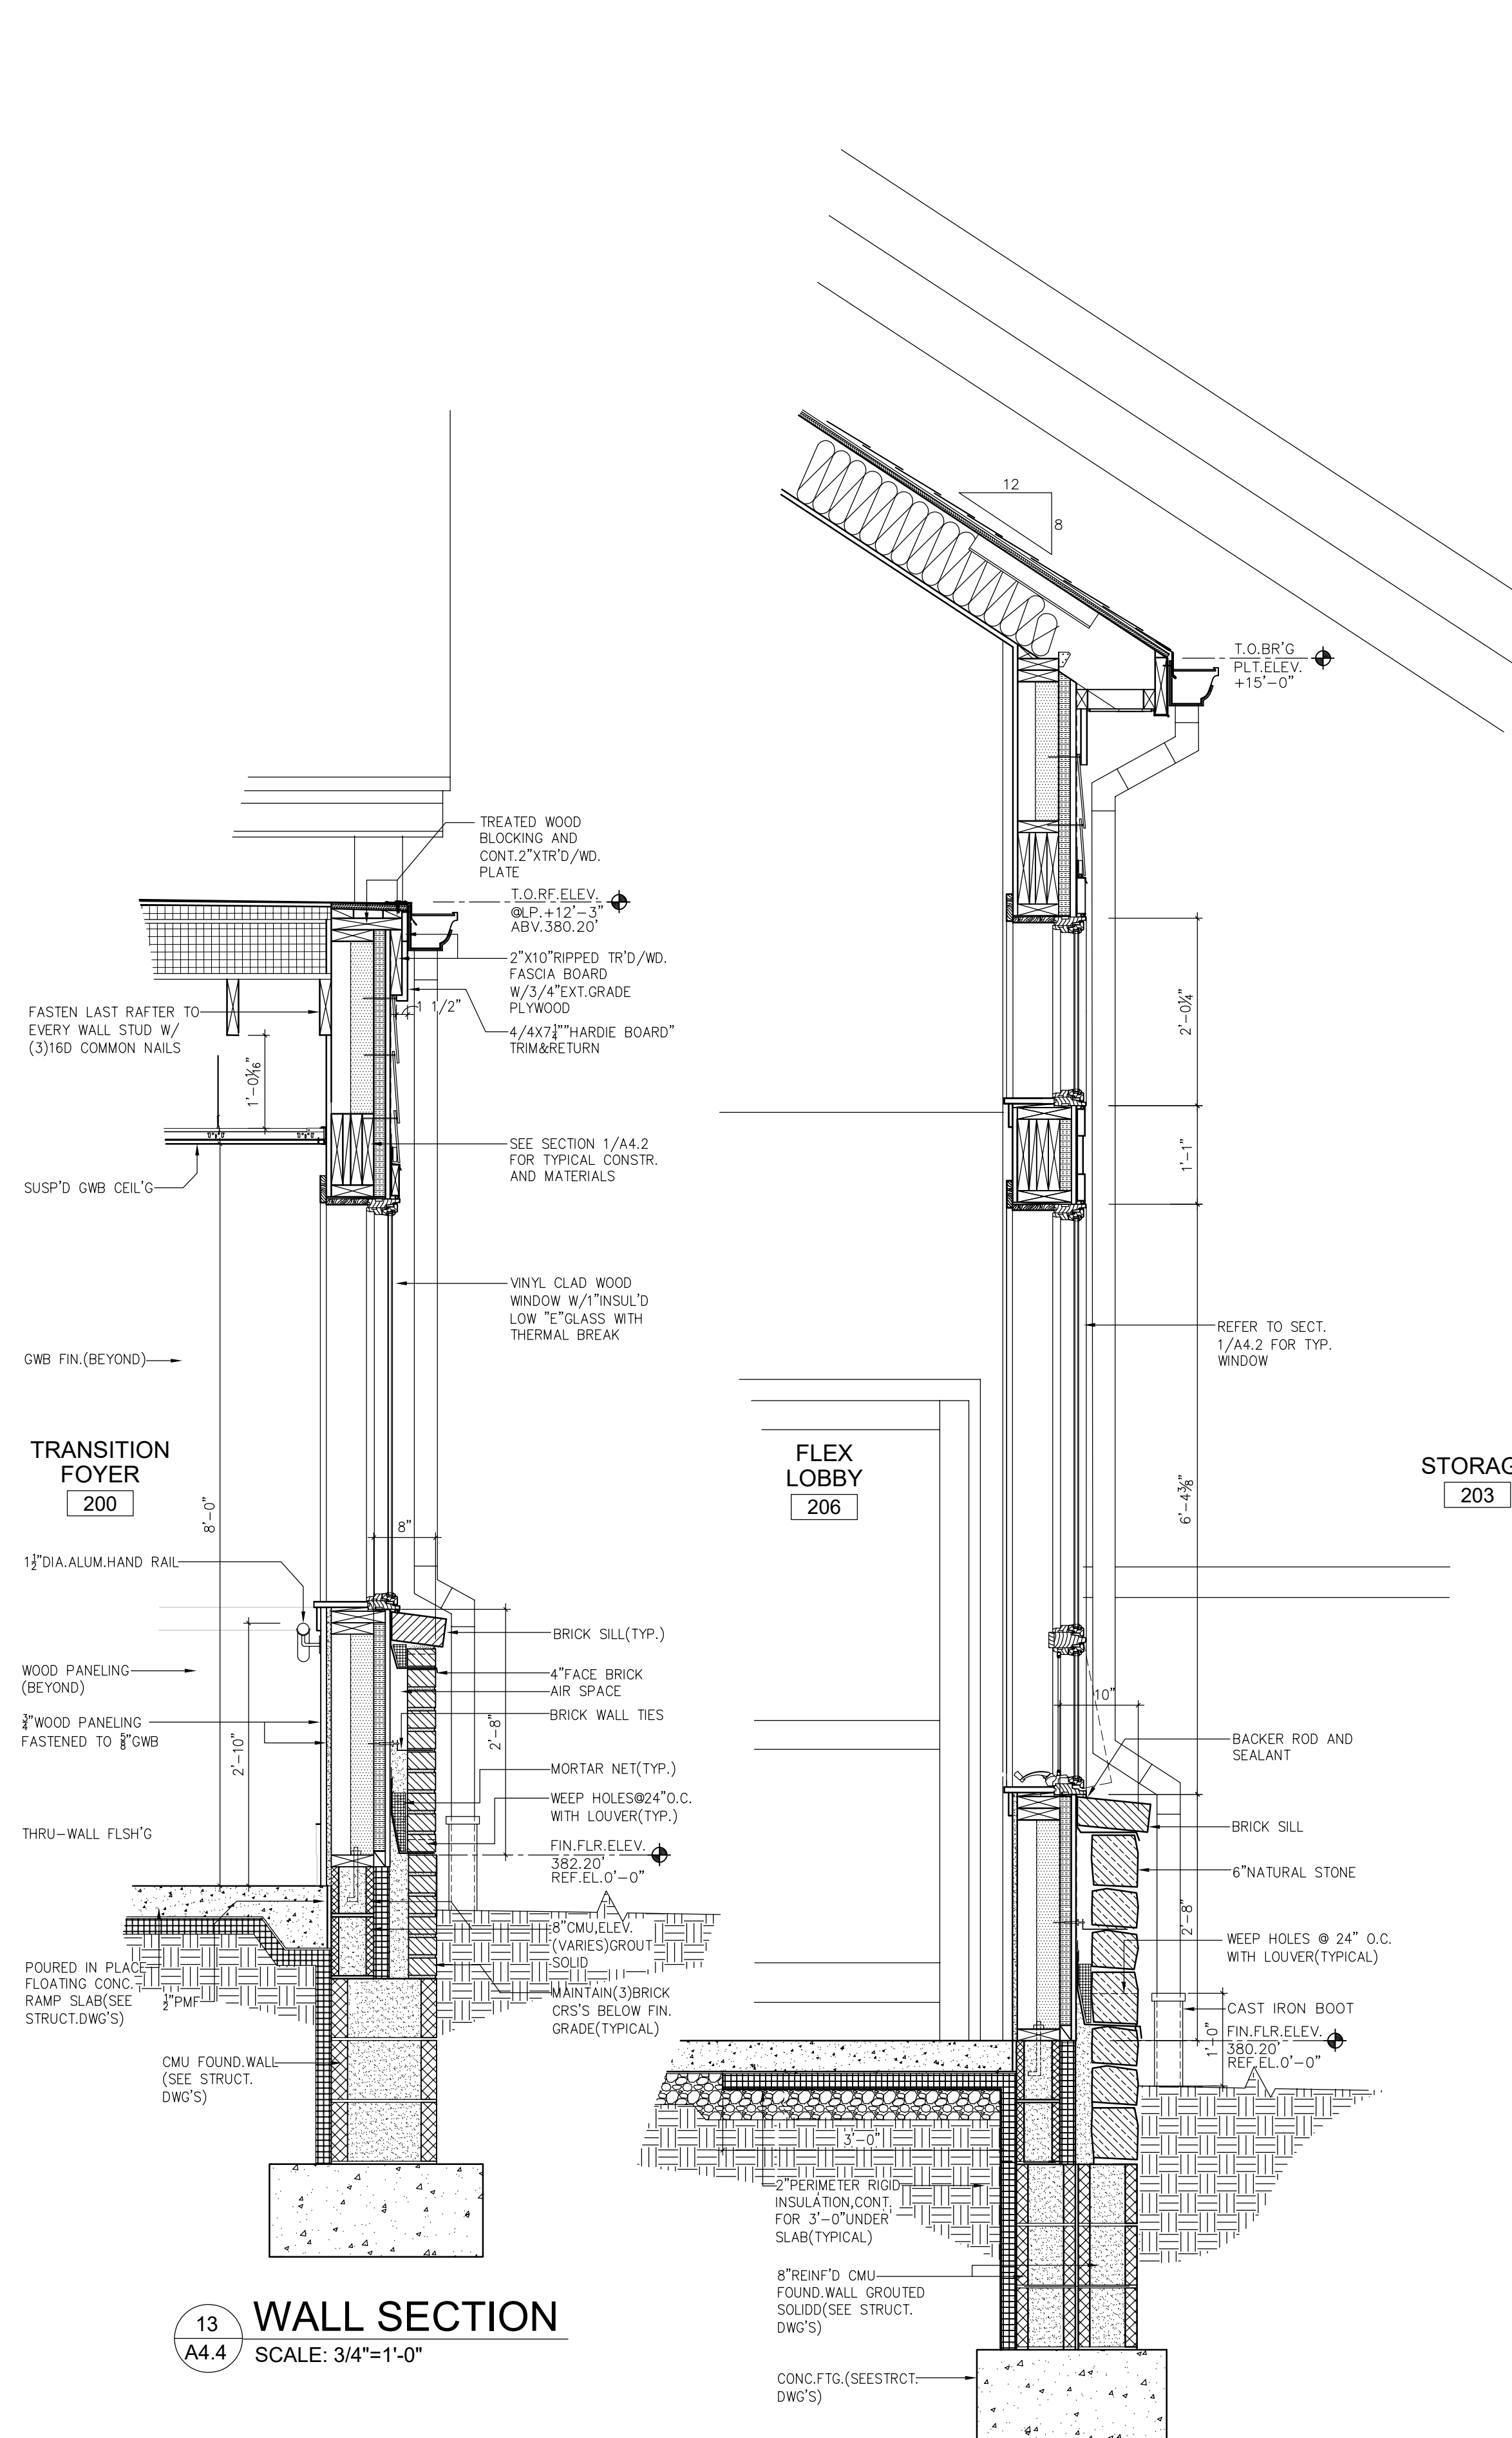


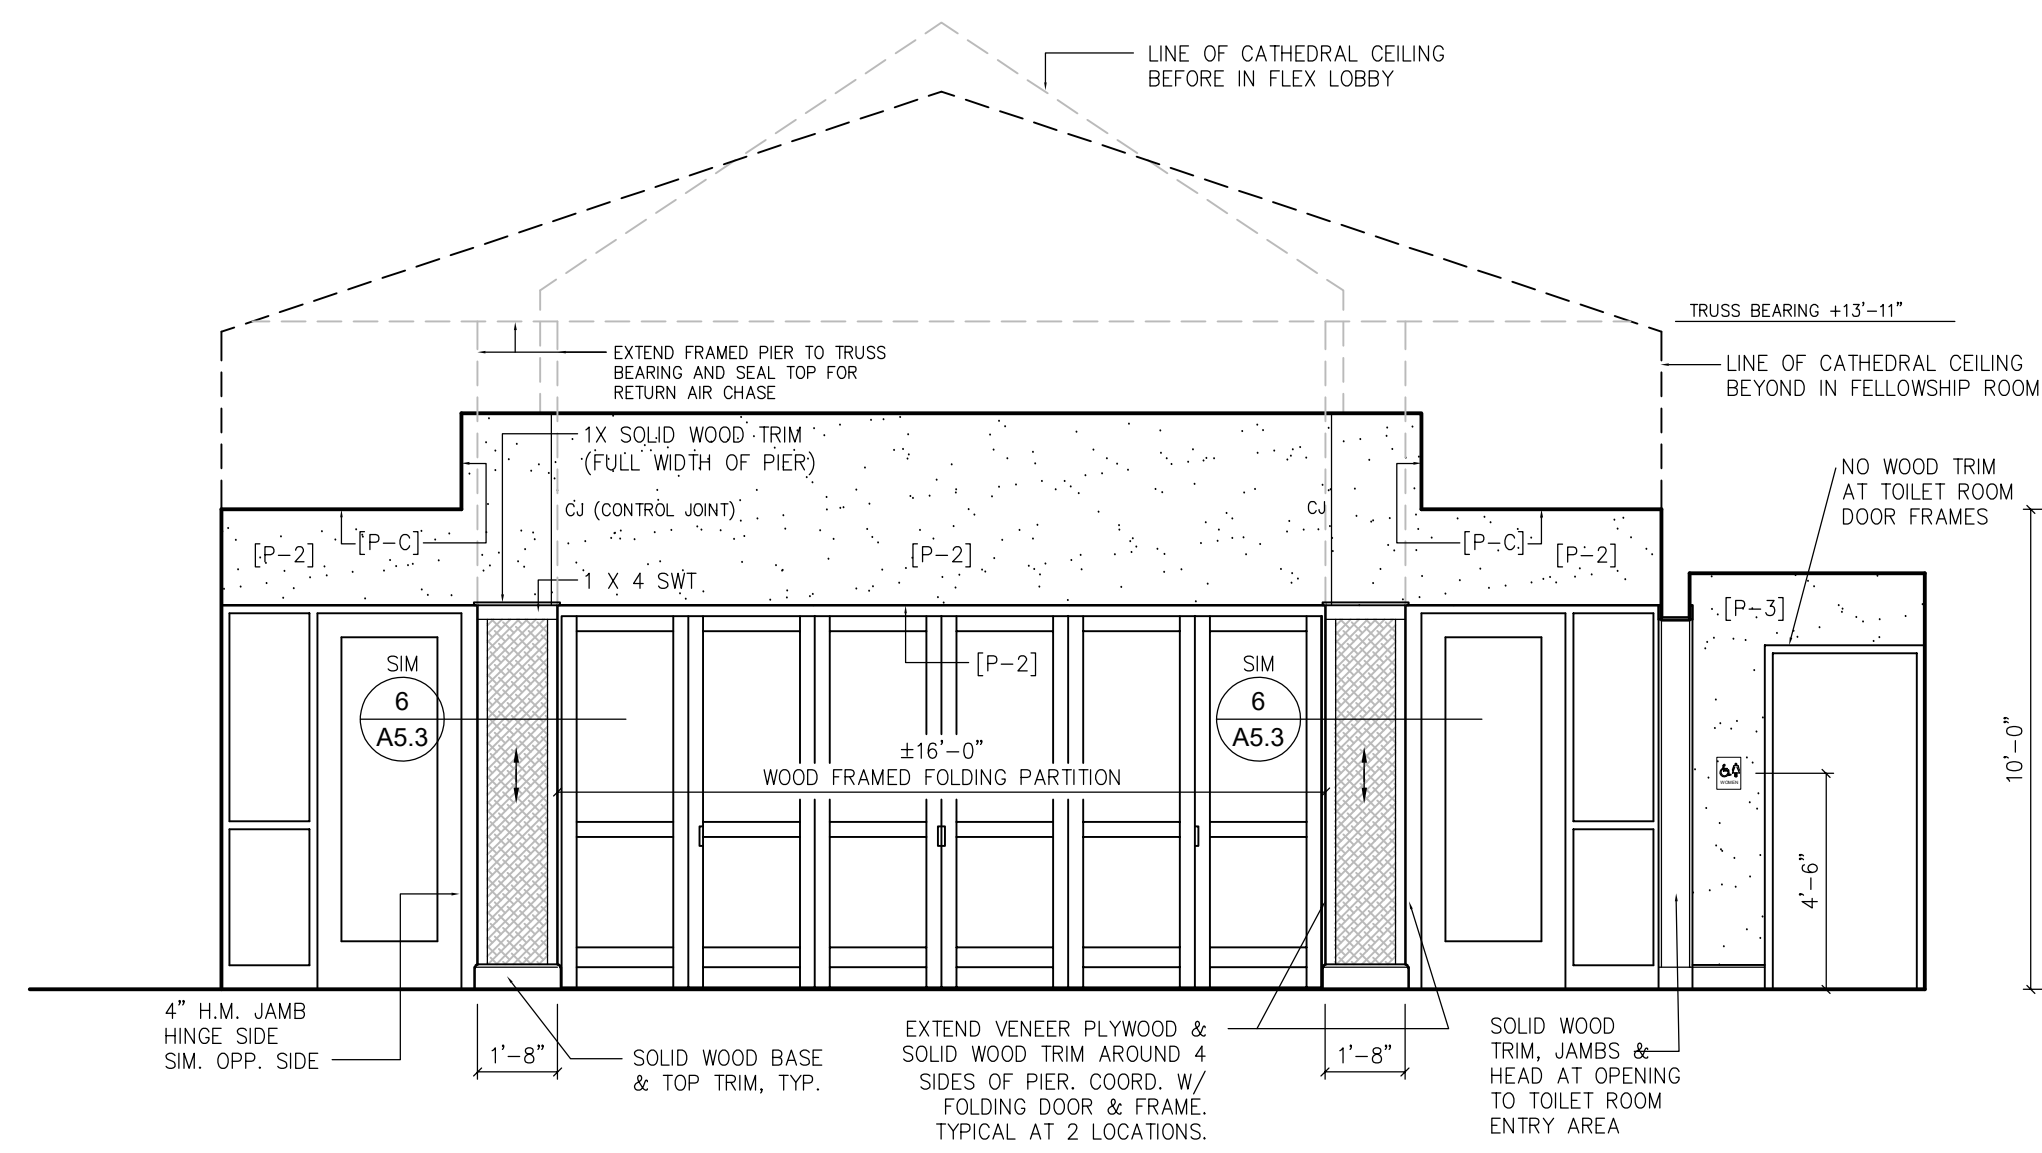


1 FLEX / LOBBY - RM. 206
A5.1 SCALE: 1/4" = 1'-0"

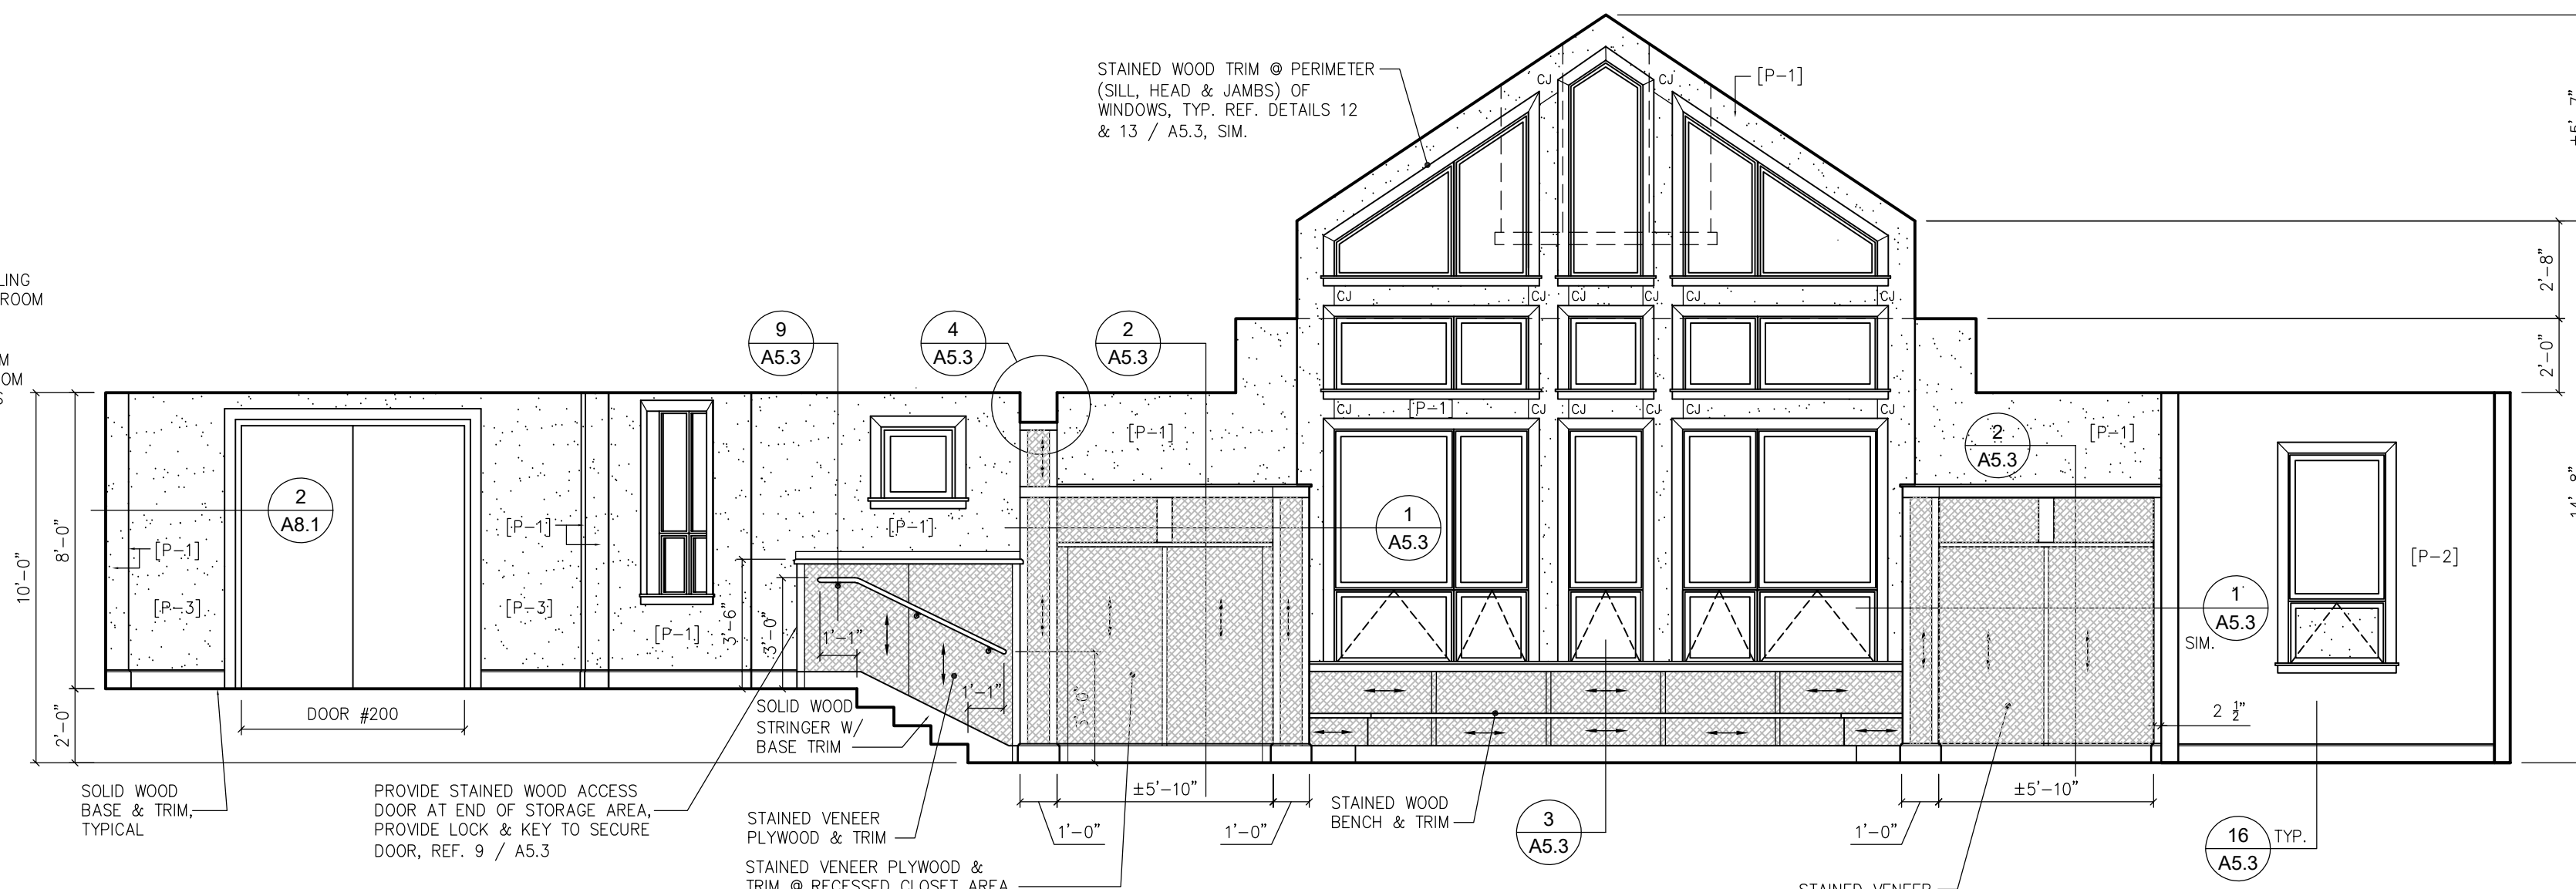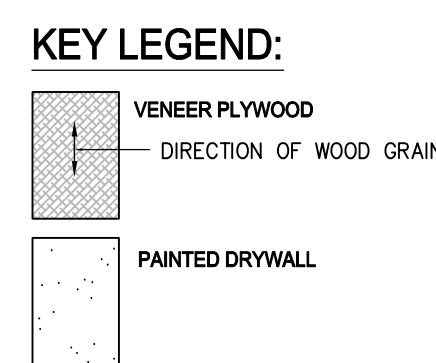


2 TRANSITION FOYER - RM. 200 & FLEX / LOBBY - RM. 206
A5.1 SCALE: 1/4" = 1'-0"

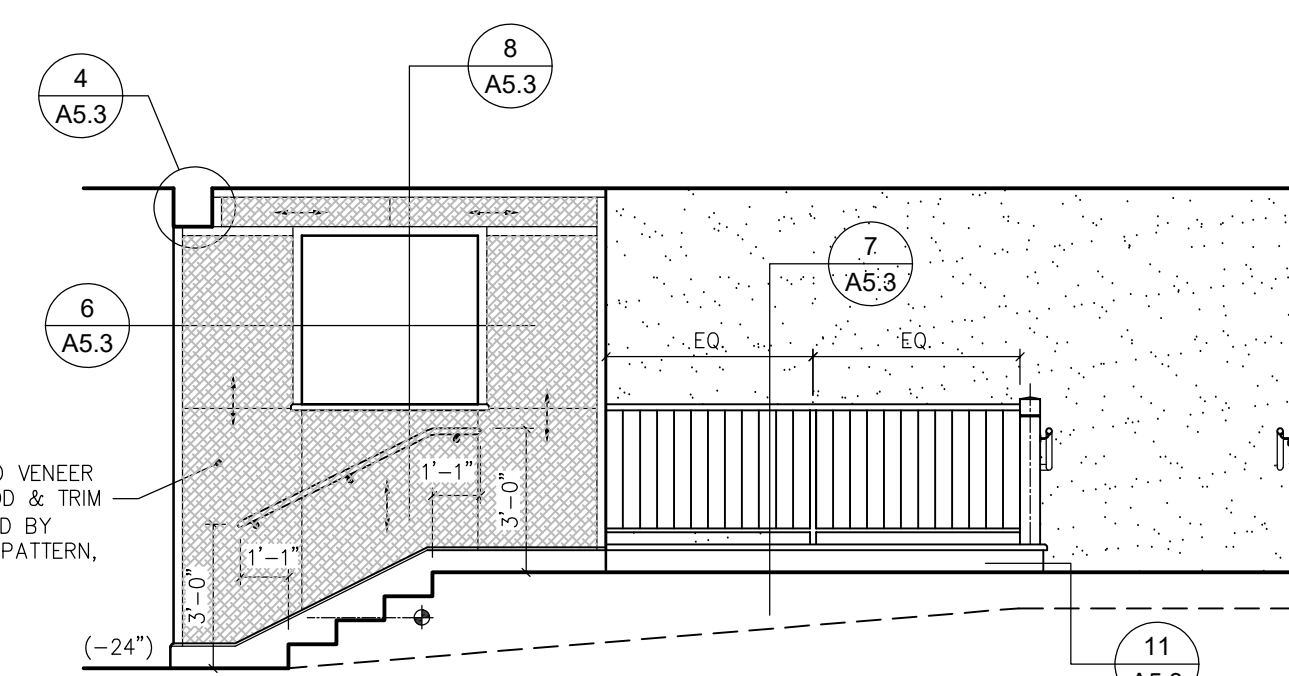


3 TRANSITION FOYER
A5.1 SCALE: 1/4" = 1'-0"

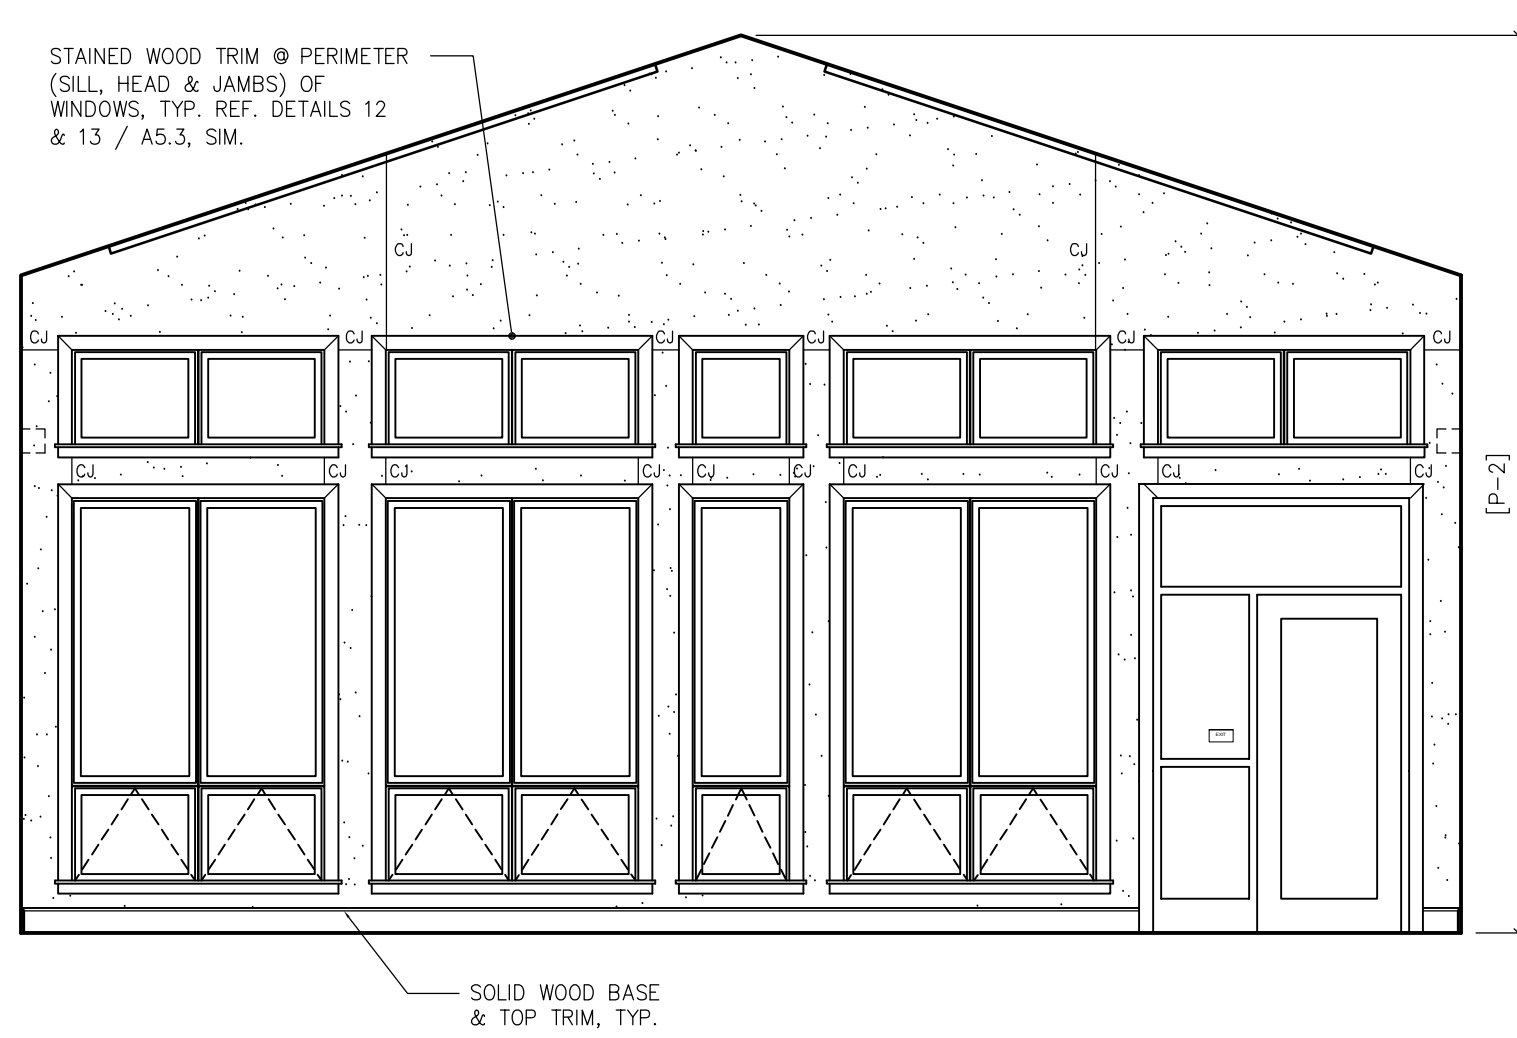


4 FELLOWSHIP - RM. 205
A5.1 SCALE: 1/4" = 1'-0"

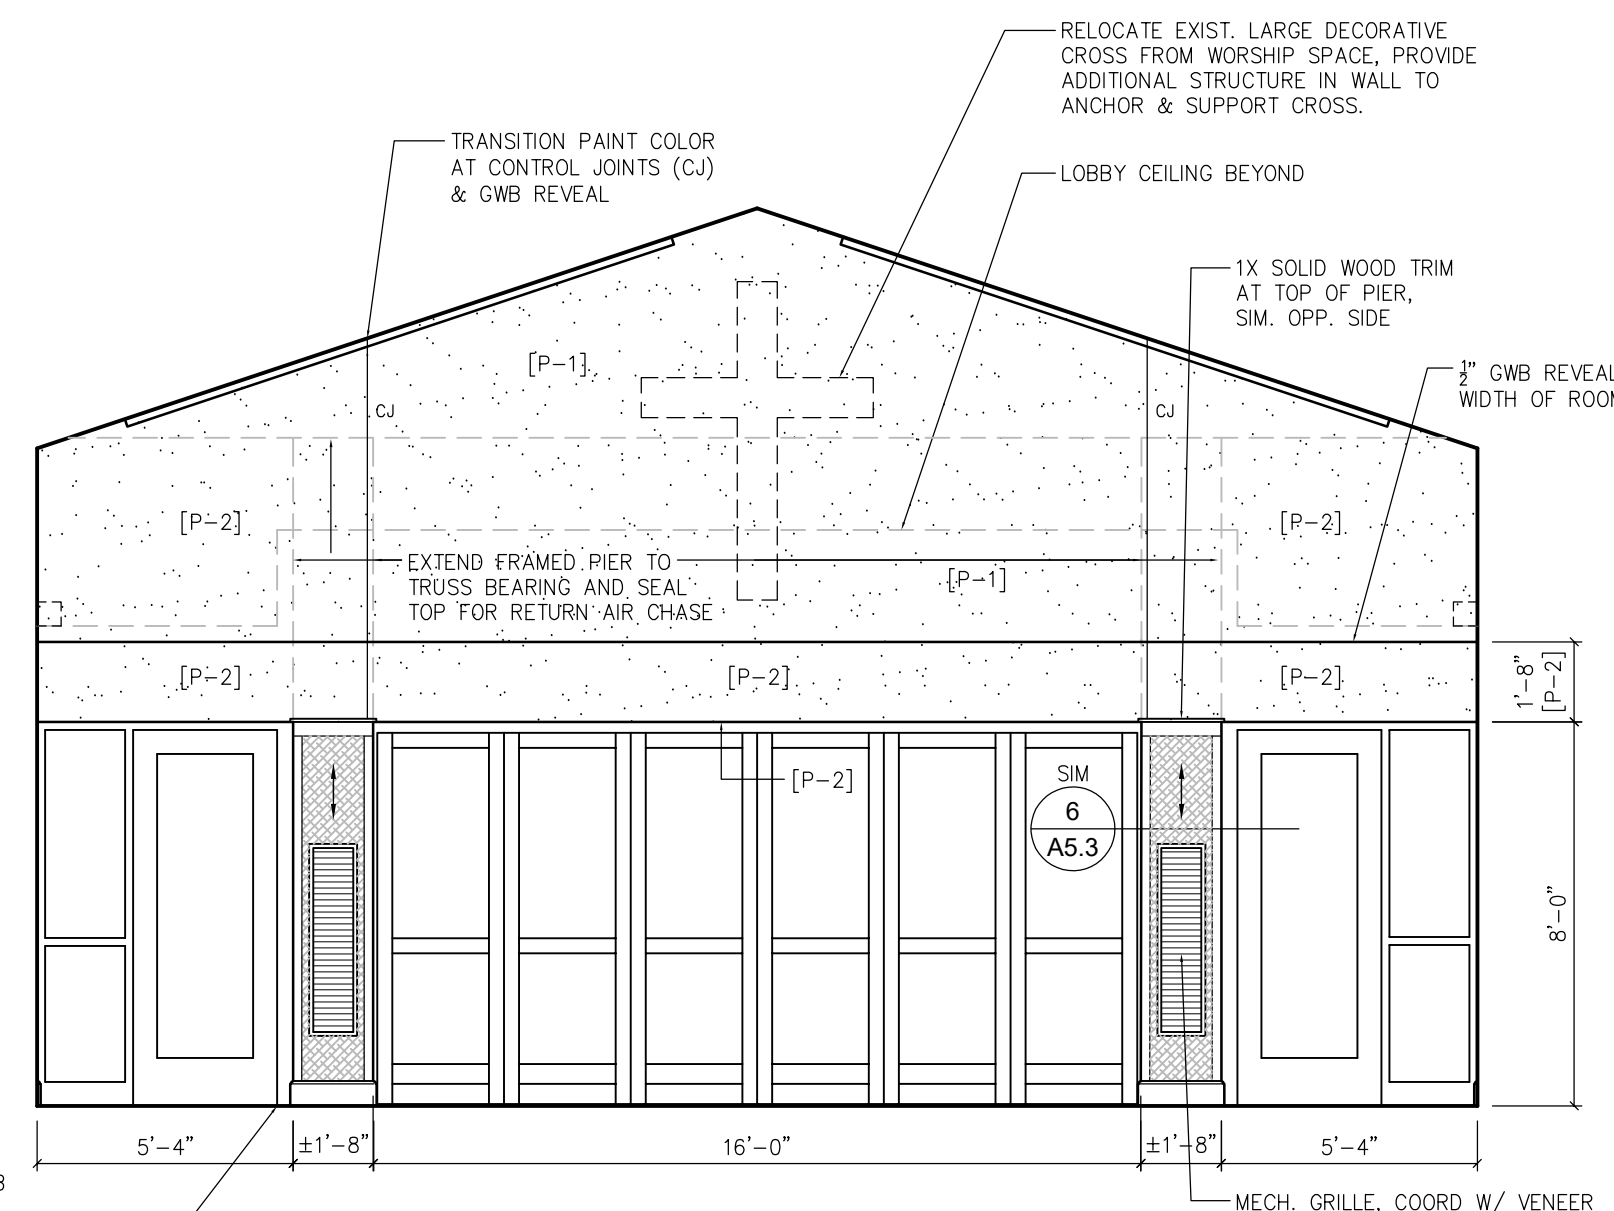


5 FELLOWSHIP - RM. 205
A5.1 SCALE: 1/4" = 1'-0"

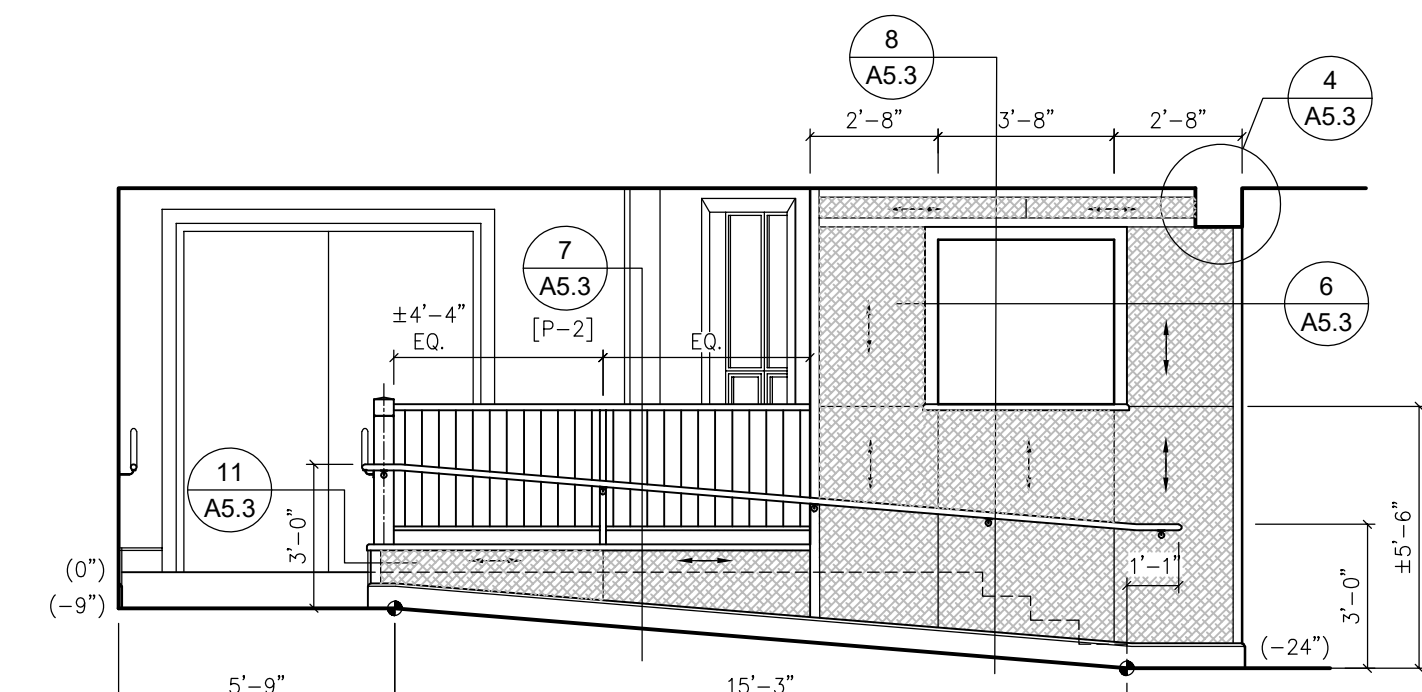


6 RAMP
A5.1 SCALE: 1/4" = 1'-0"

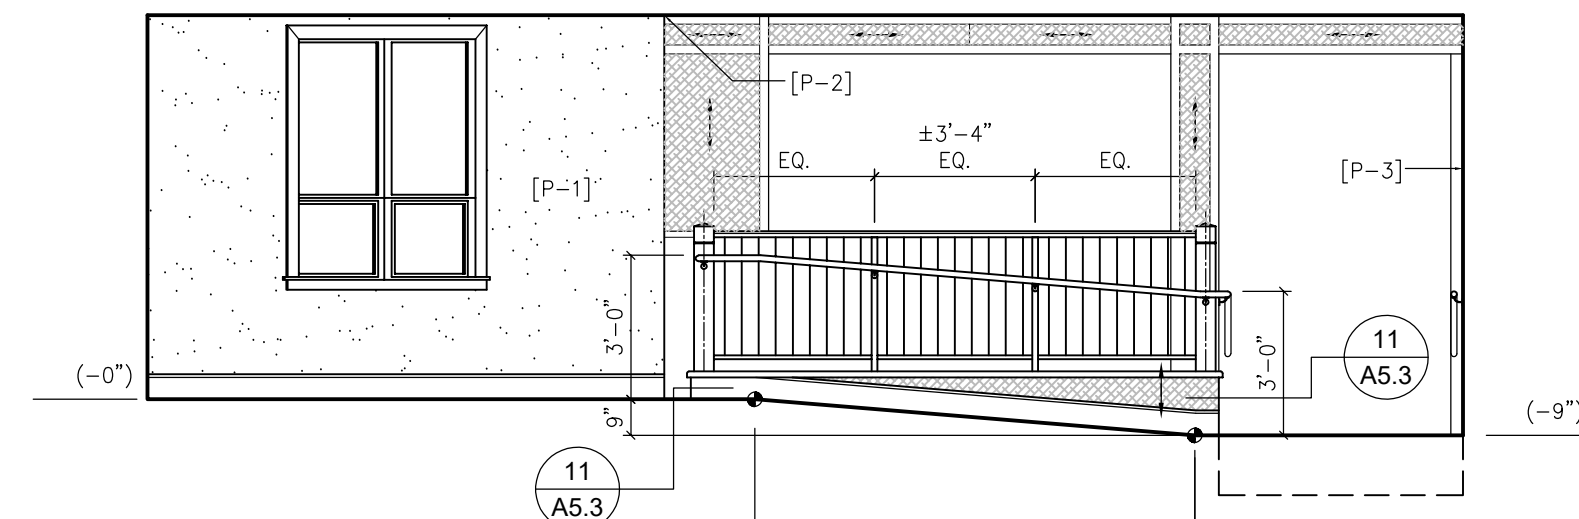


7 RAMP
A5.1 SCALE: 1/4" = 1'-0"

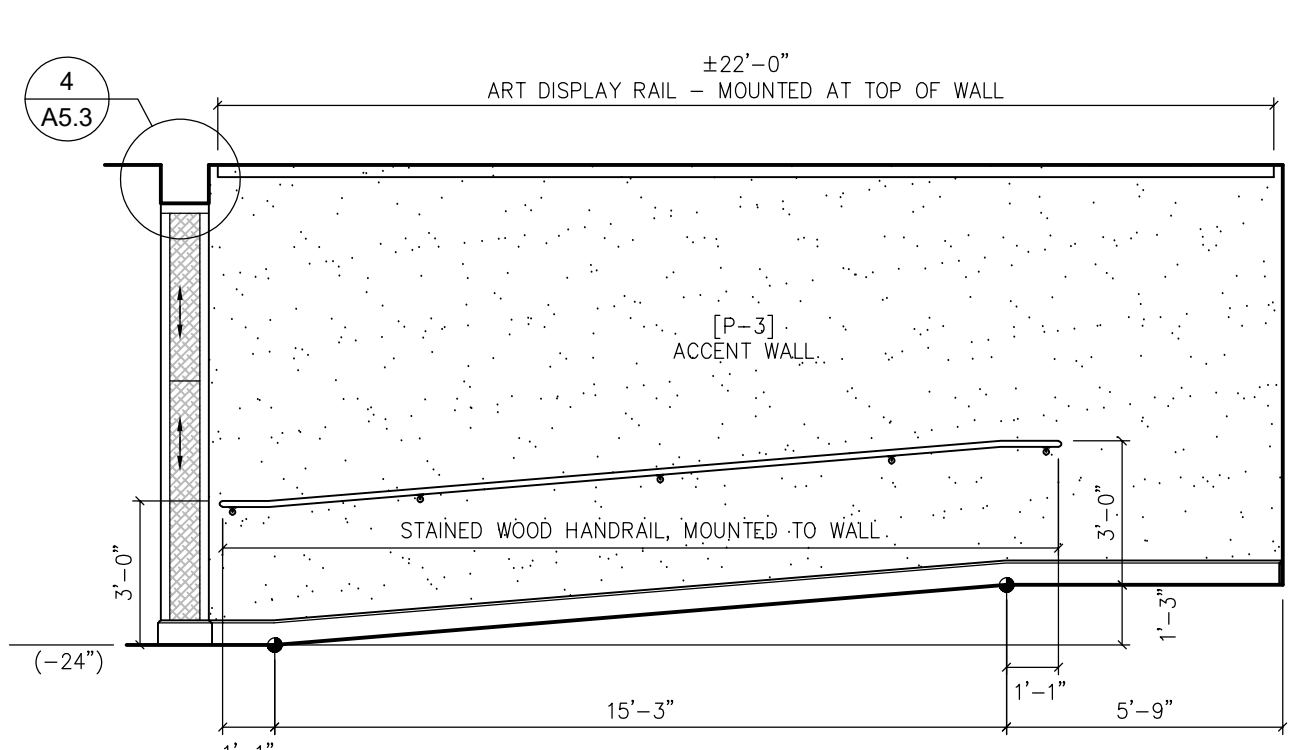


6A TRANSITION FOYER (RAMP) - RM. 200
A5.1 SCALE: 1/4" = 1'-0"

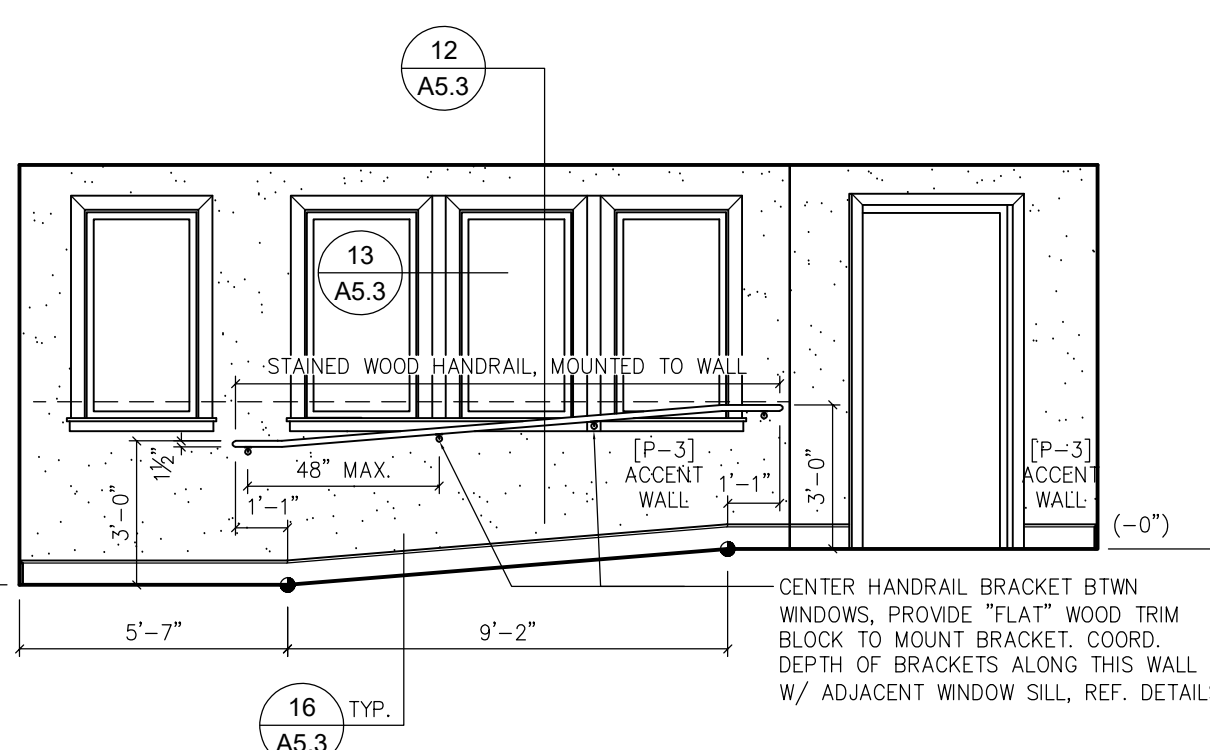


7A TRANSITION FOYER (RAMP) - RM. 200
A5.1 SCALE: 1/4" = 1'-0"

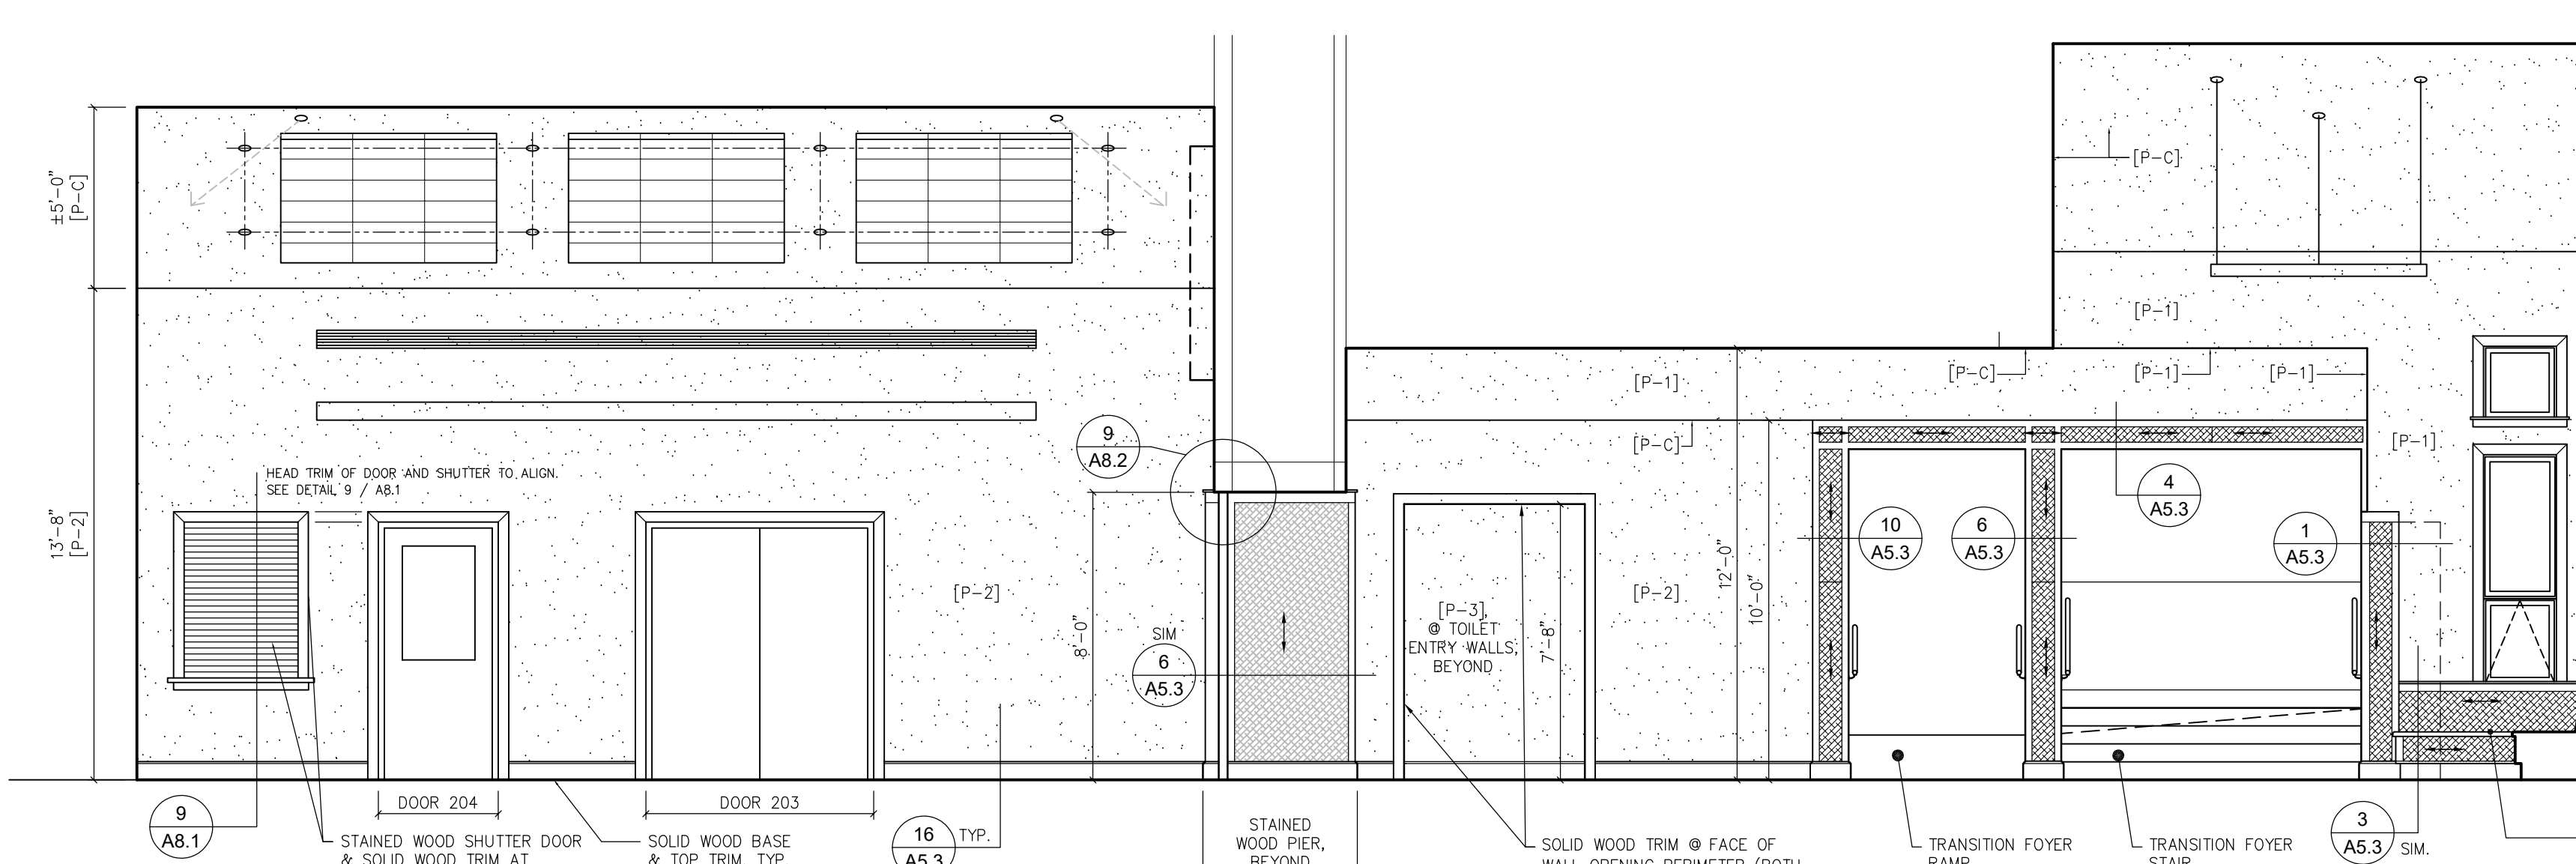

8 FELLOWSHIP - RM. 205 & FLEX/LOBBY - RM. 206
A5.1 SCALE: 1/4" = 1'-0"

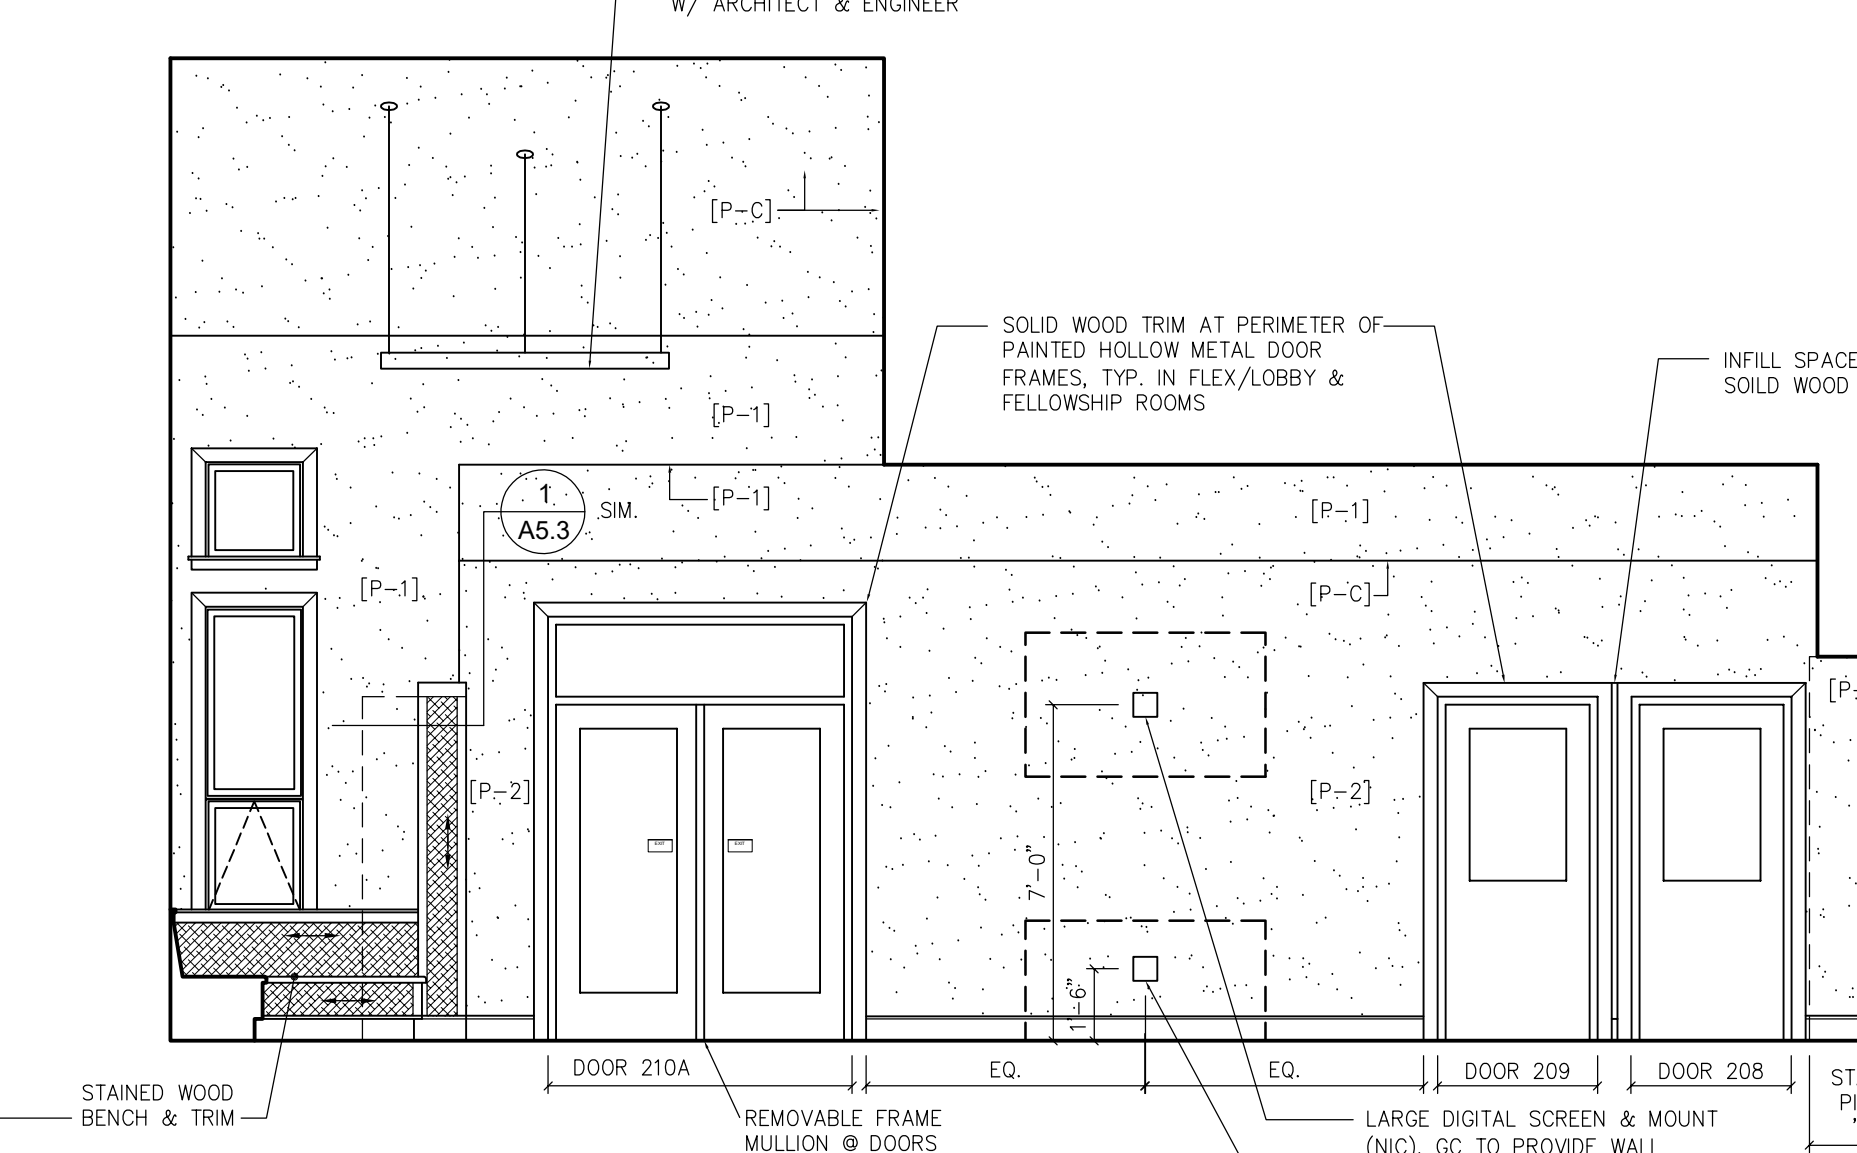

9 FLEX/LOBBY & FELLOWSHIP
A5.1 SCALE: 1/4" = 1'-0"

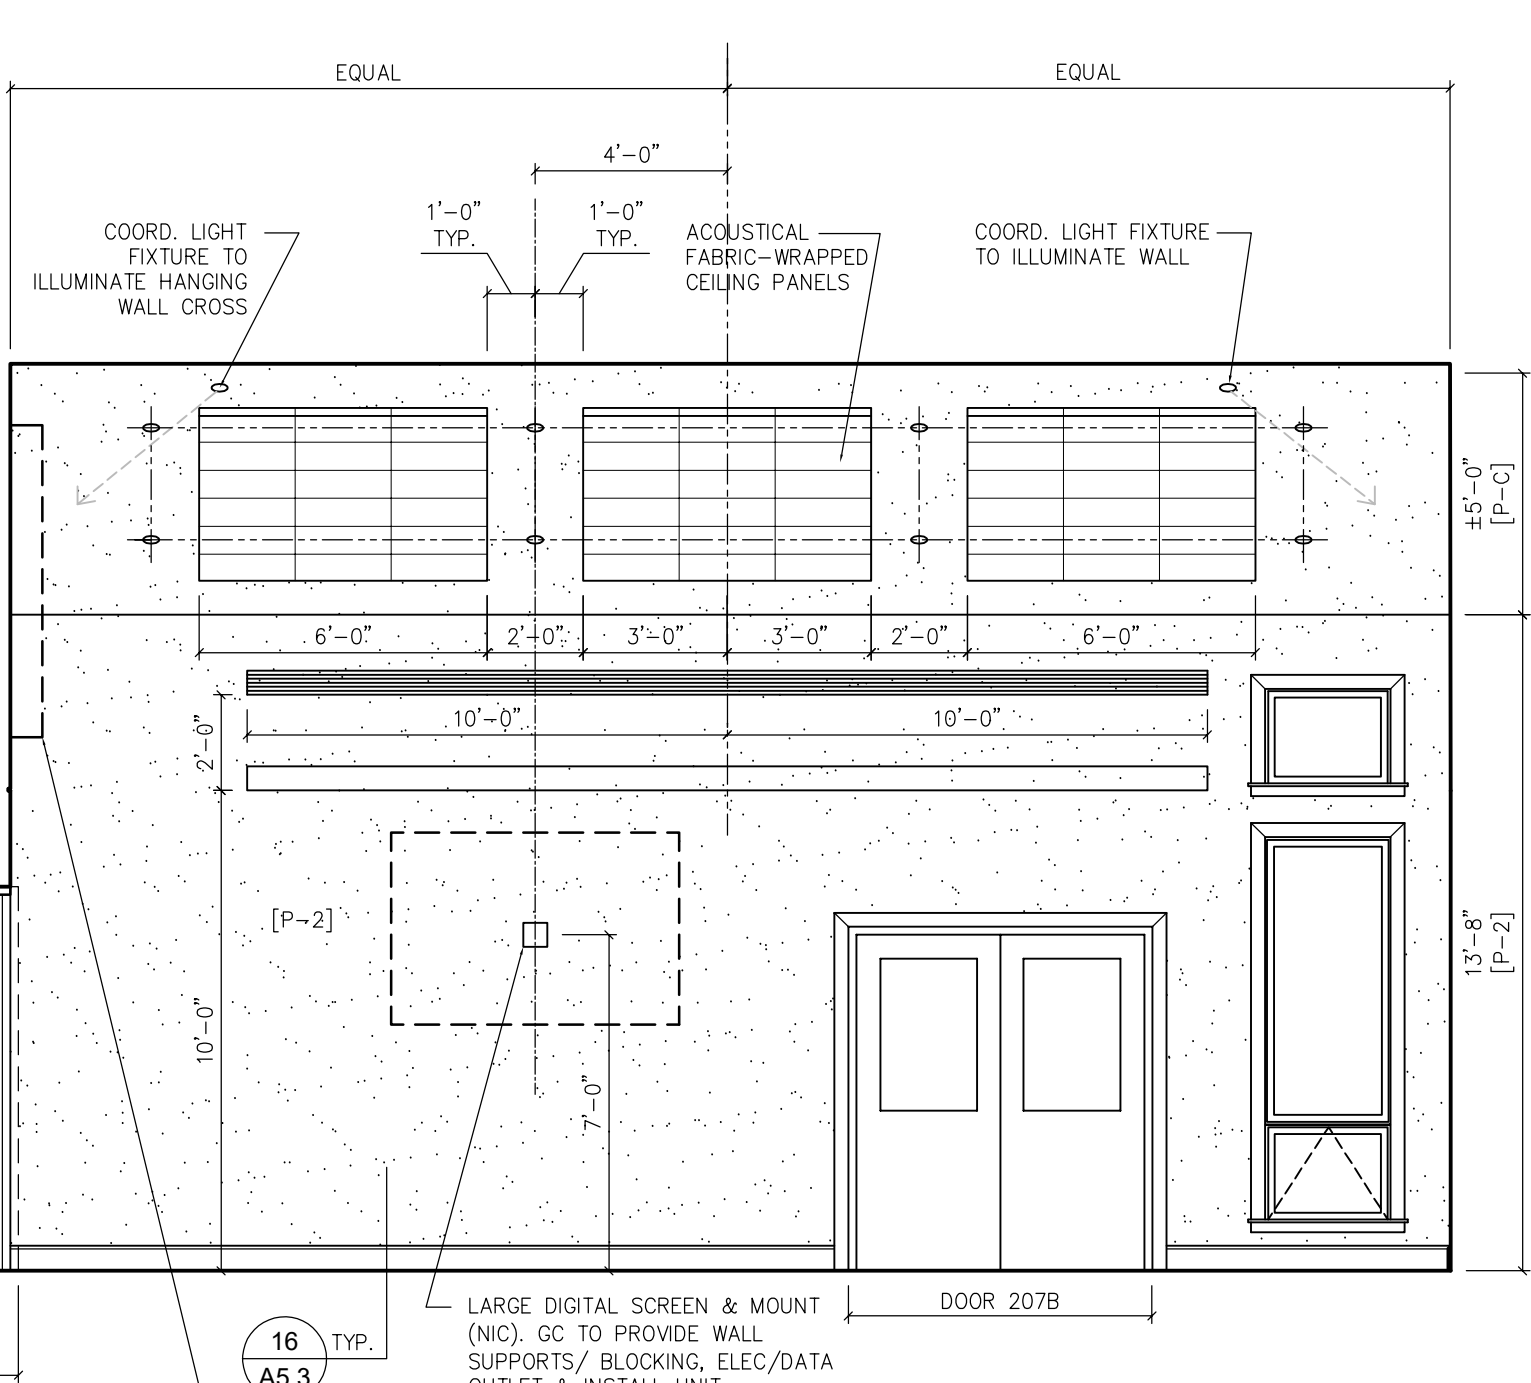

16 TYP. A5.3

STAMP

CONSULTANTS

GODSHALL KANE O'ROURKE ARCHITECTS, LLC
300 Brookside Avenue
Philadelphia, PA 19102
T: 215.646.5707 F: 215.646.5707 W: gkoarchitects.com



ADDITIONS AND RENOVATIONS FOR

CHURCH OF THE
HOLY SPIRIT

2871 BARNDT ROAD, HARLEYSVILLE, PA, 19438

REVISIONS

4-12-2021 BID SET

DRAWN BY

REVIEWED BY

JOB #

SHEET TITLE

INTERIOR
ELEVATIONS

SHEET #


A5.1

SCALE









DATE

AS NOTED
4-12-2021



BID SET - APRIL 12, 2021

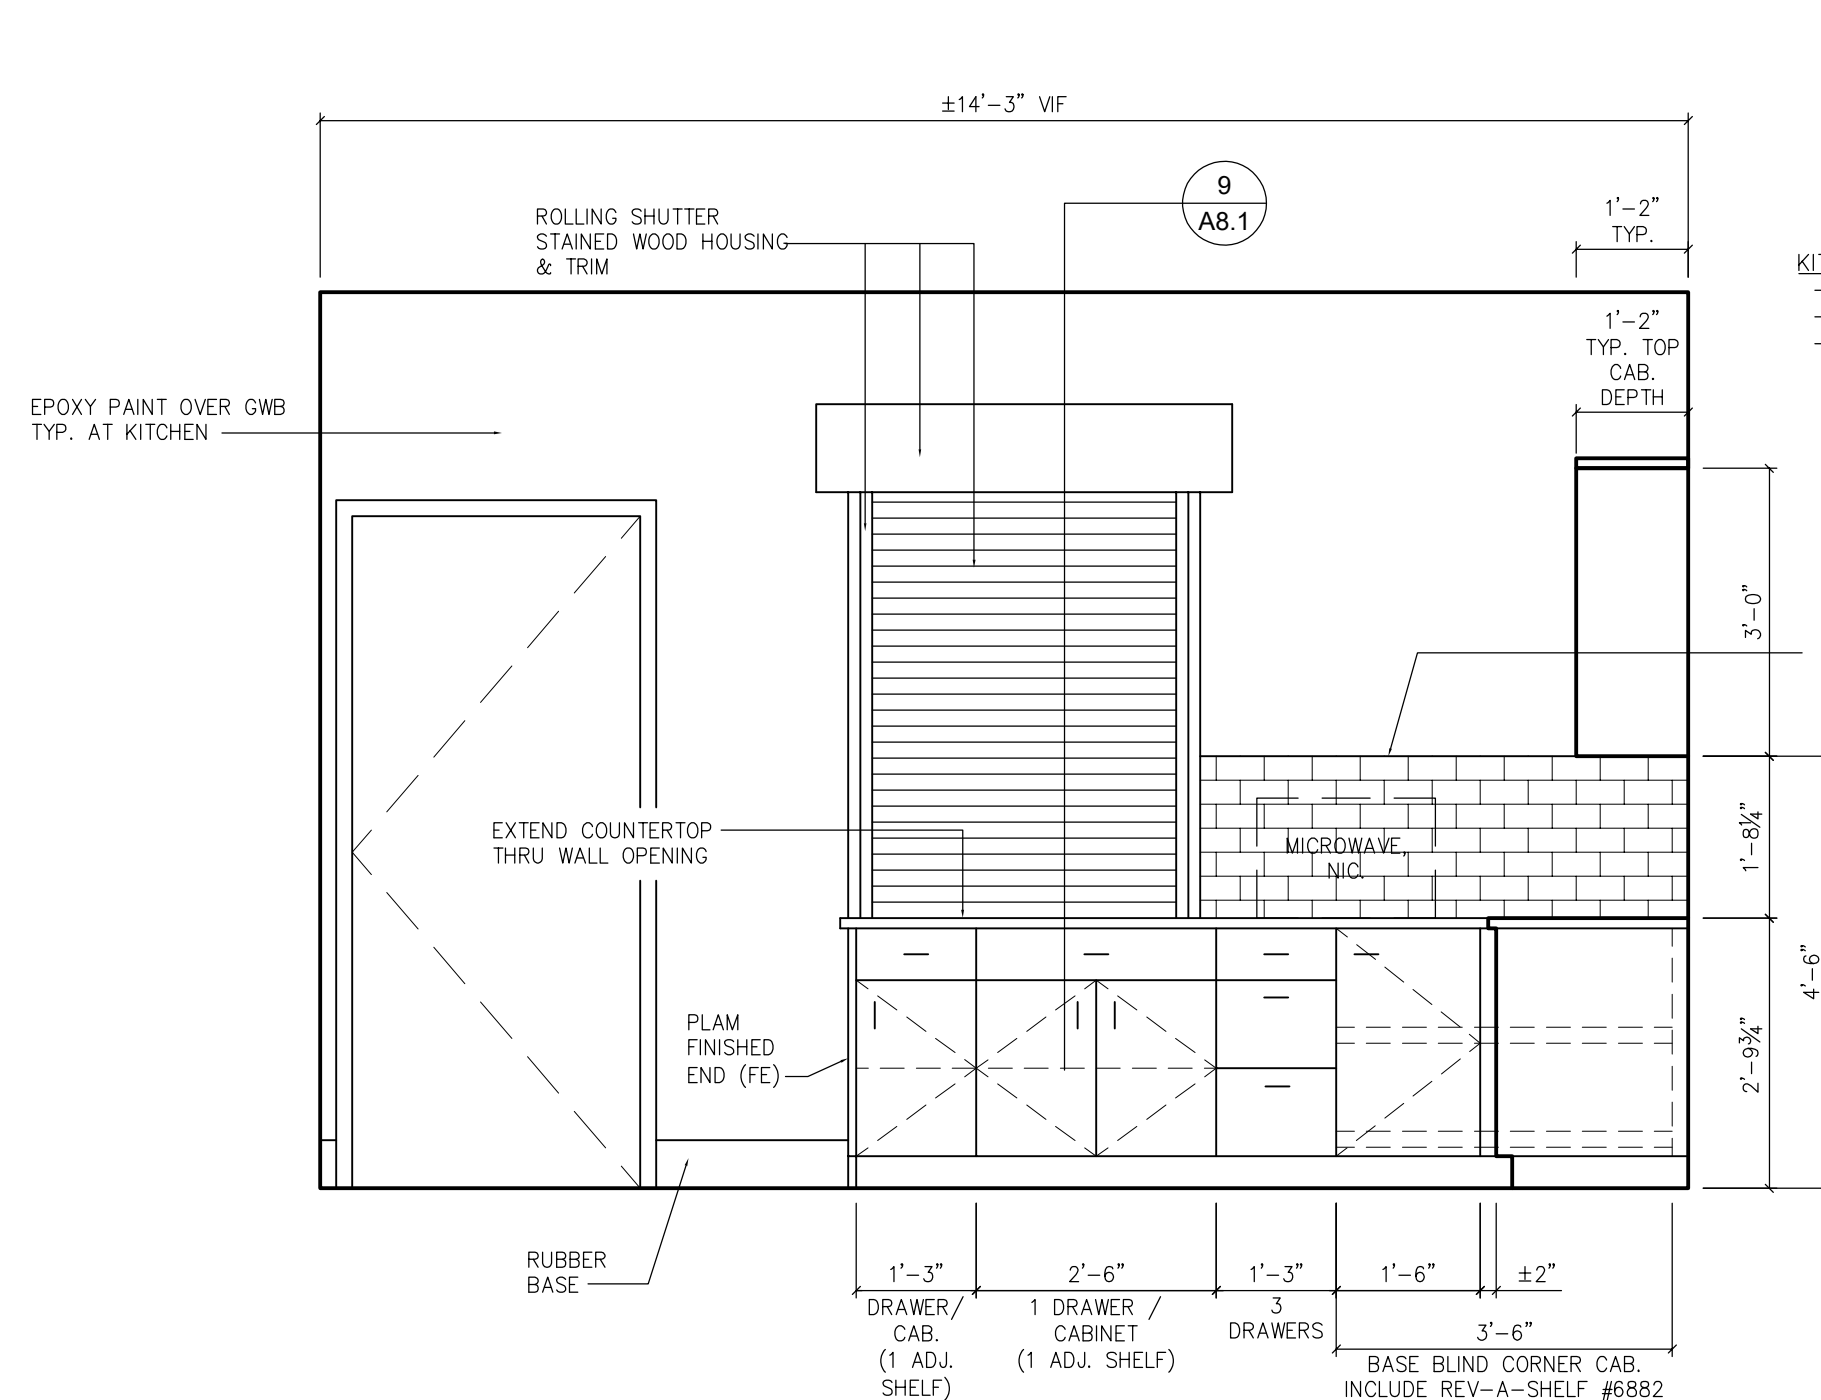

KITCHEN - RM. 204, TYP.
- CABINETRY = PLASTIC LAMINATE FINISH
- COUNTERTOP = PLASTIC LAMINATE FINISH
- REF. FINISH LEGEND ON A7 DWG SERIES FOR SELECTED FINISHES

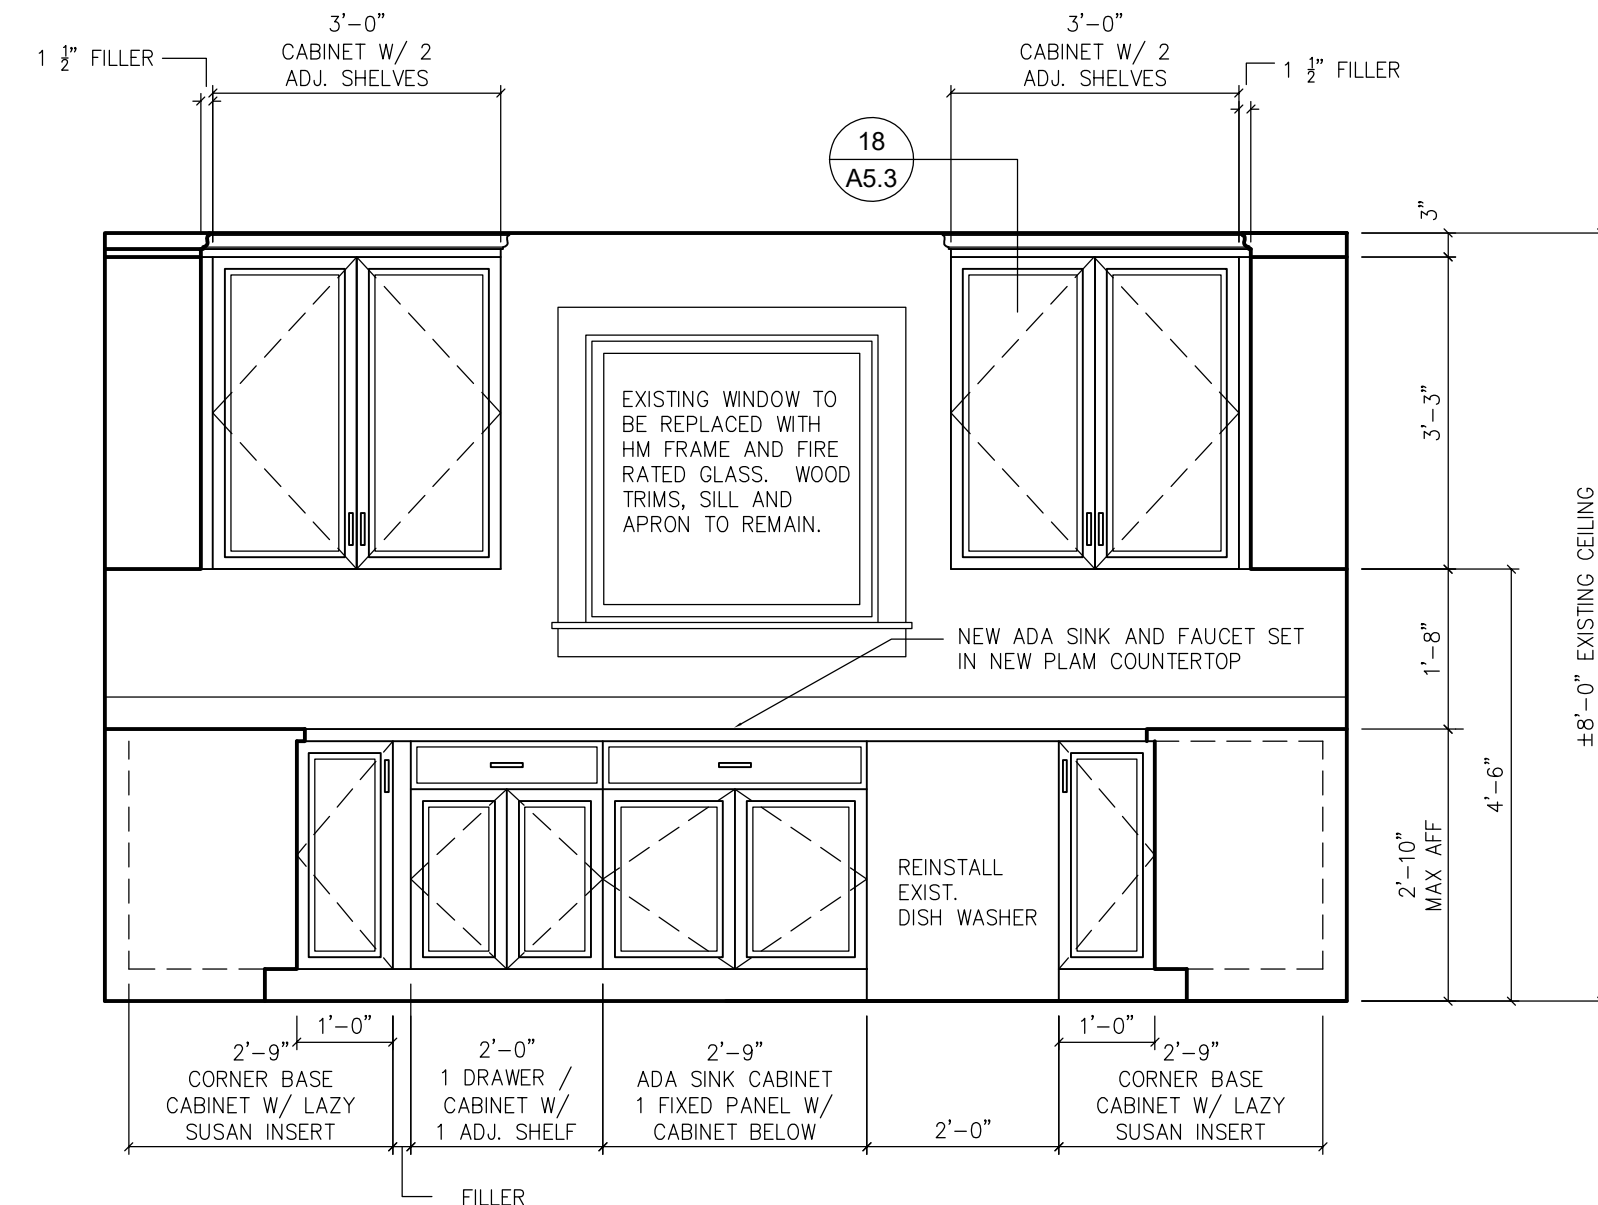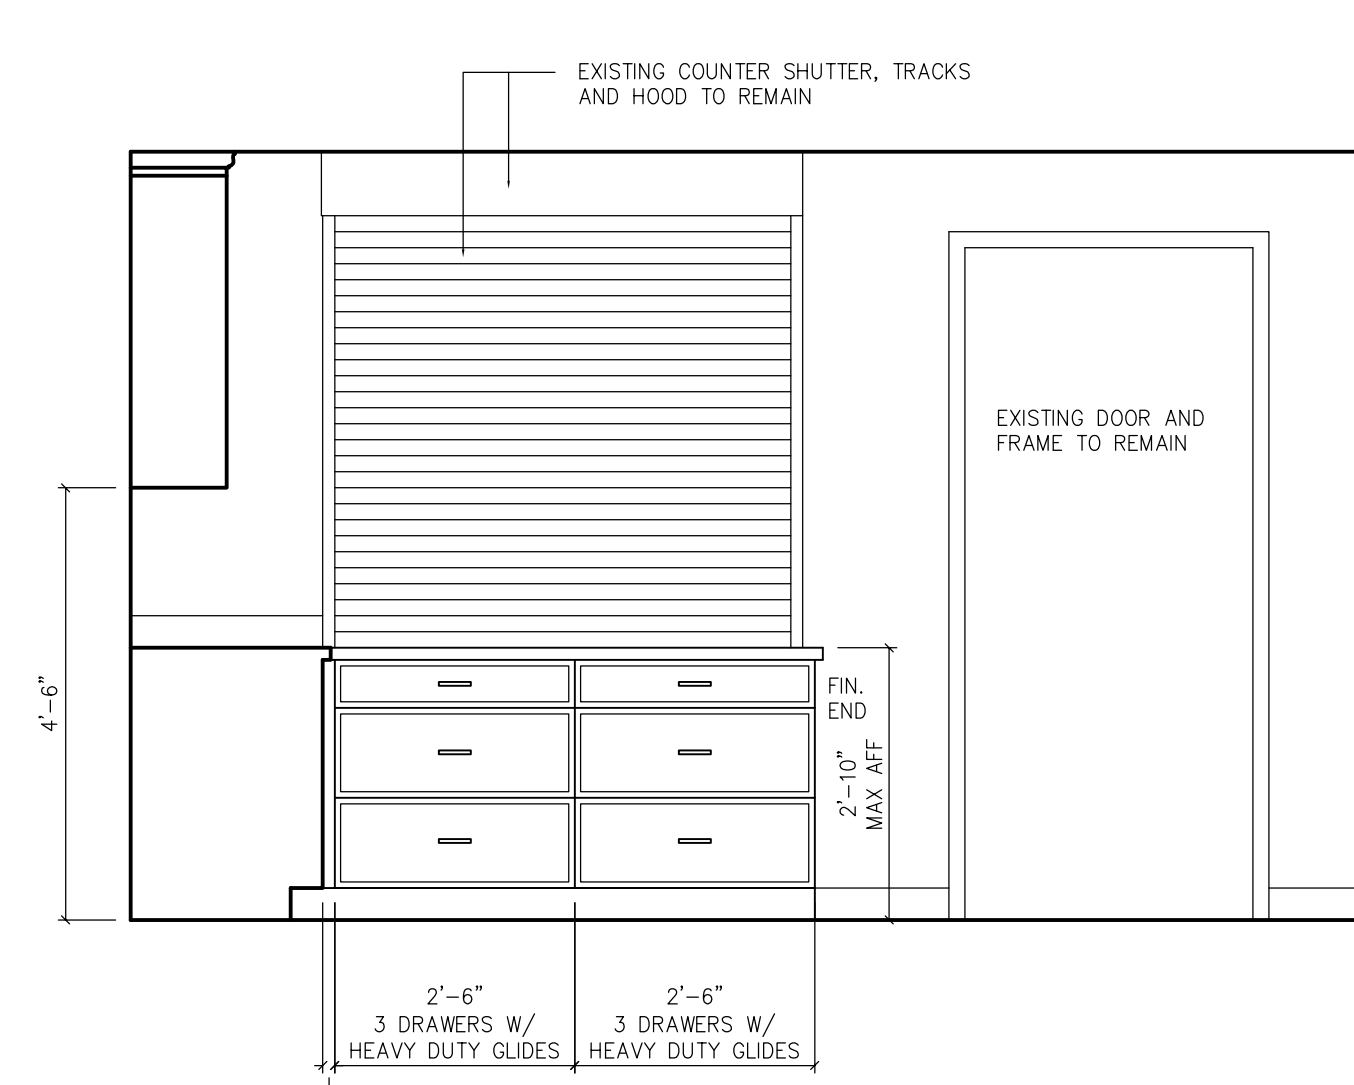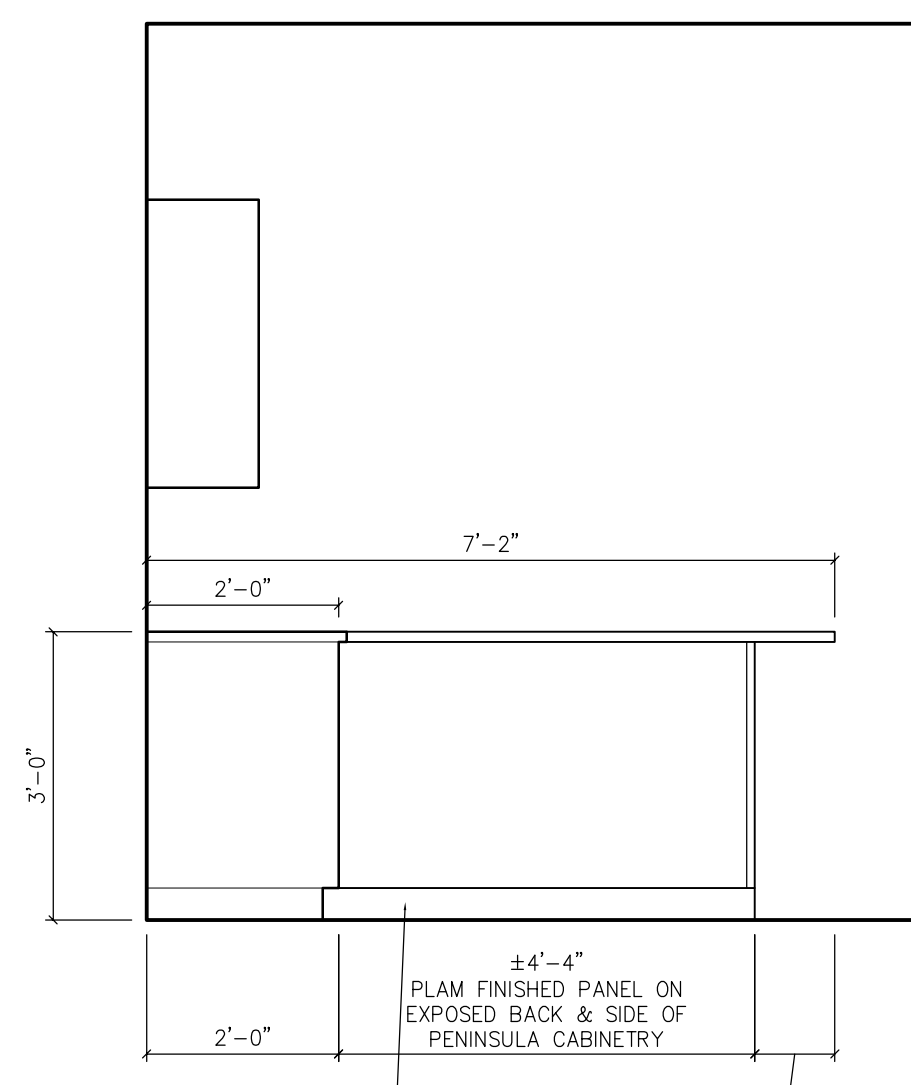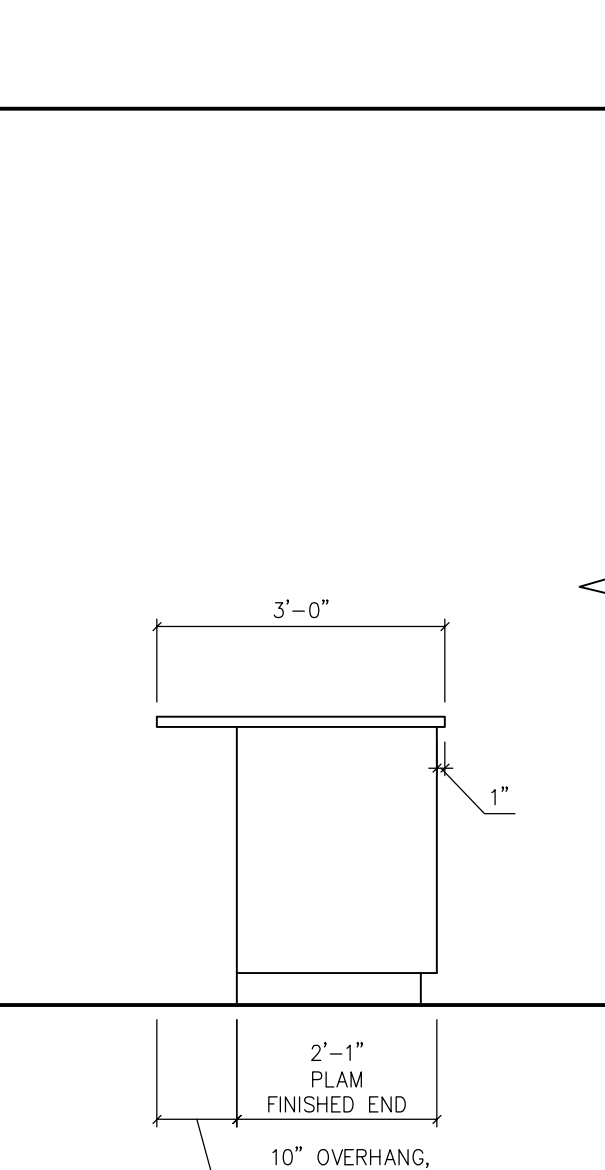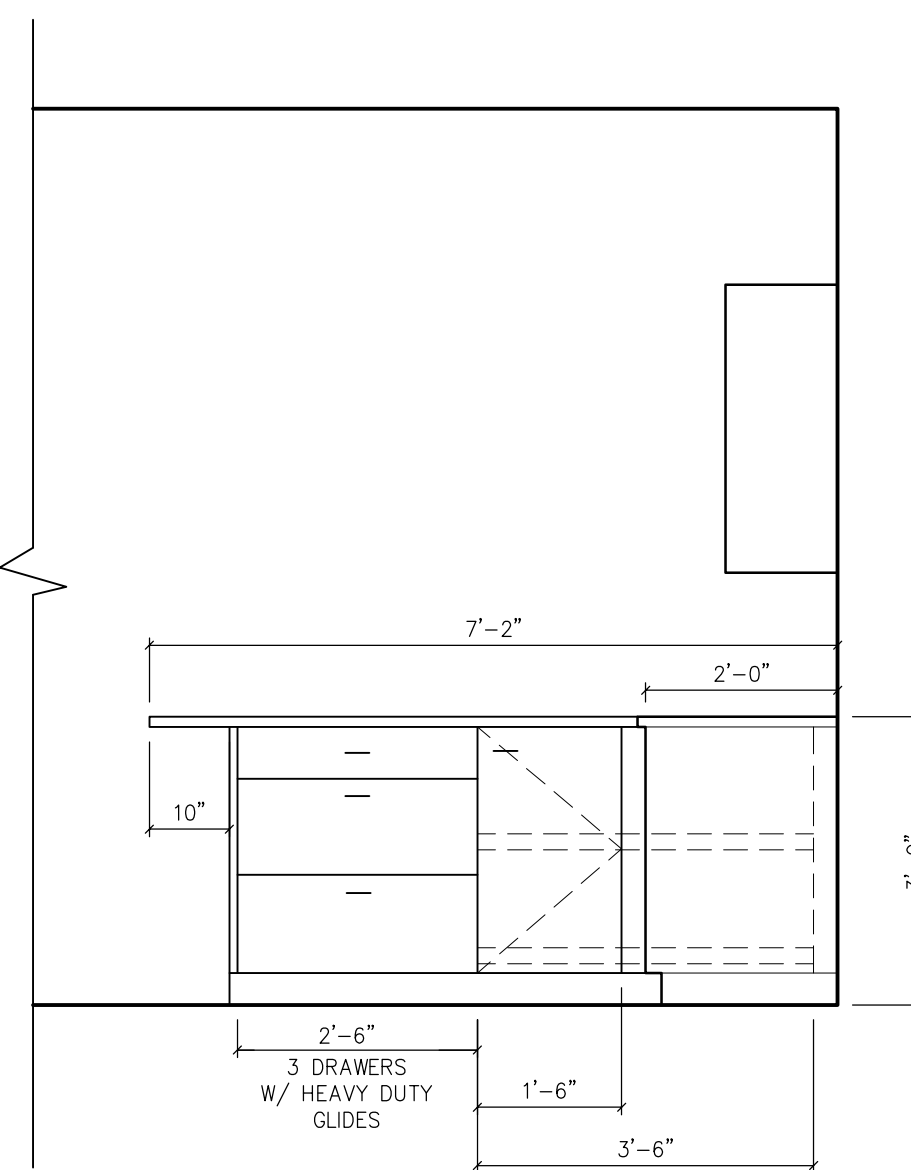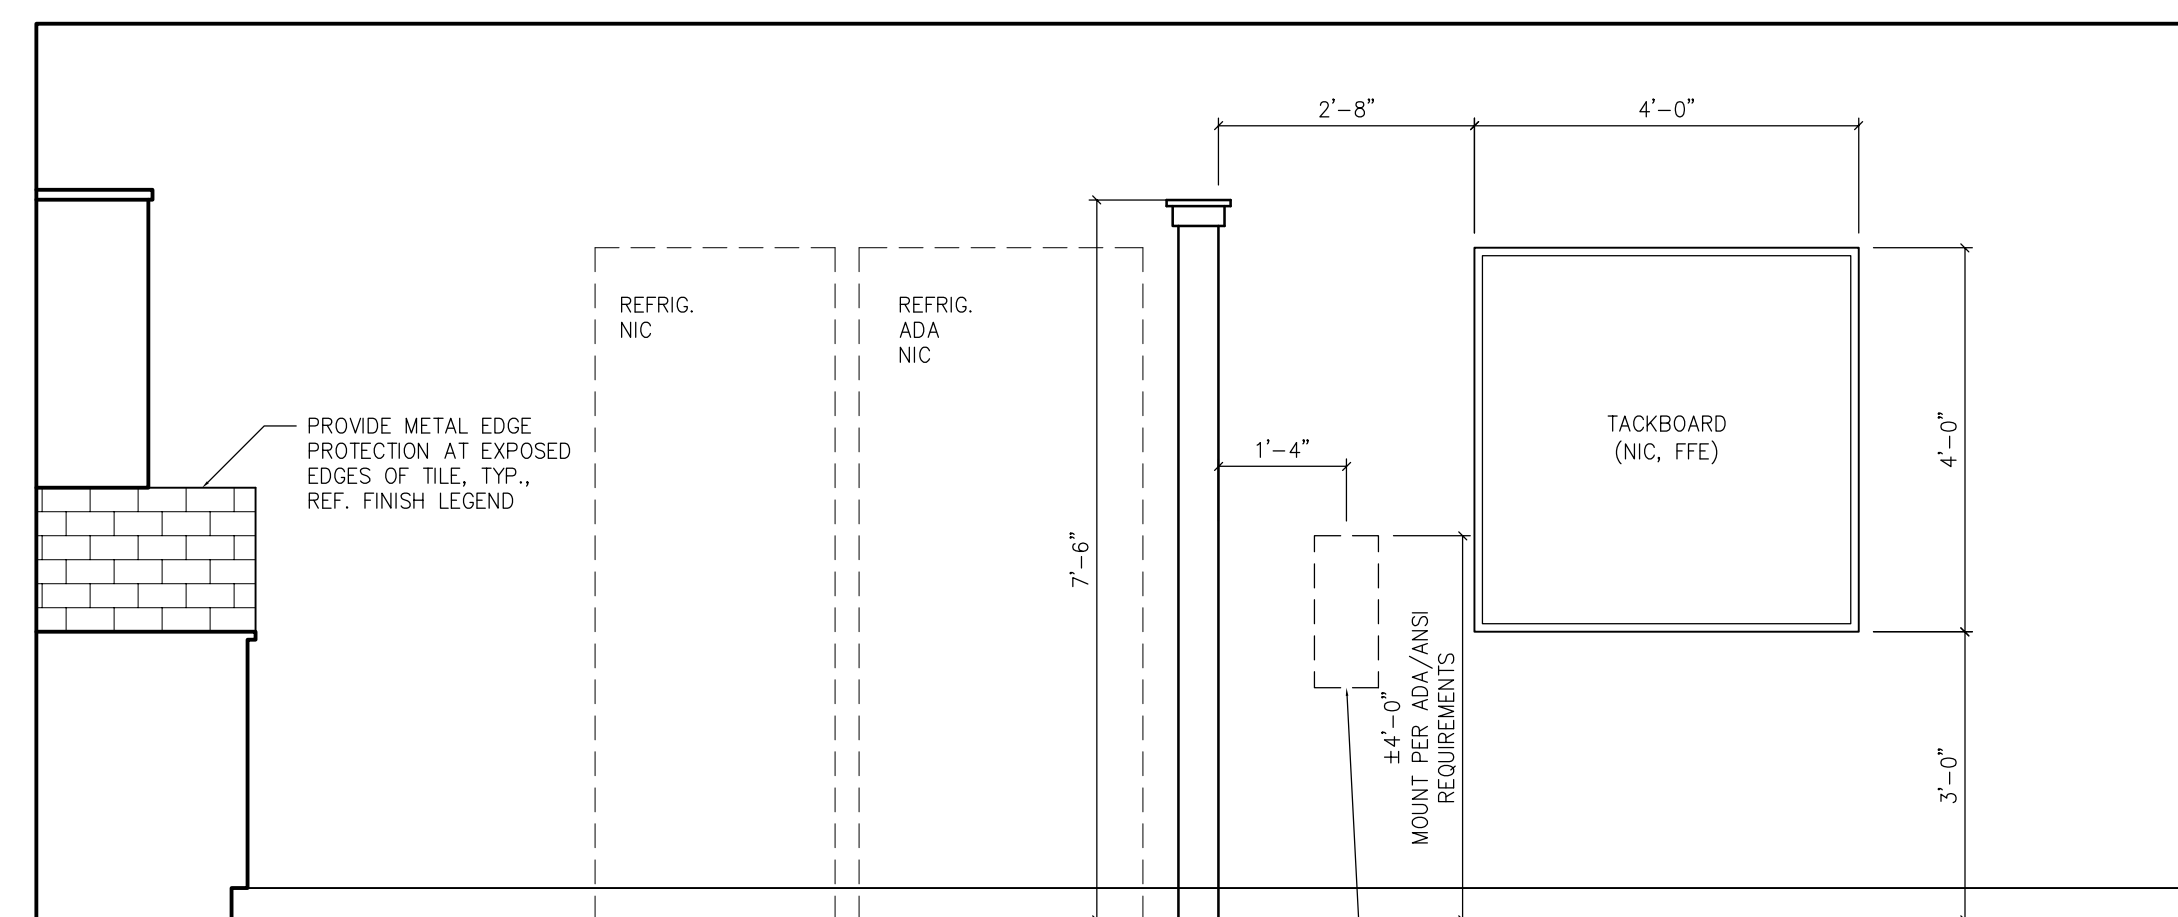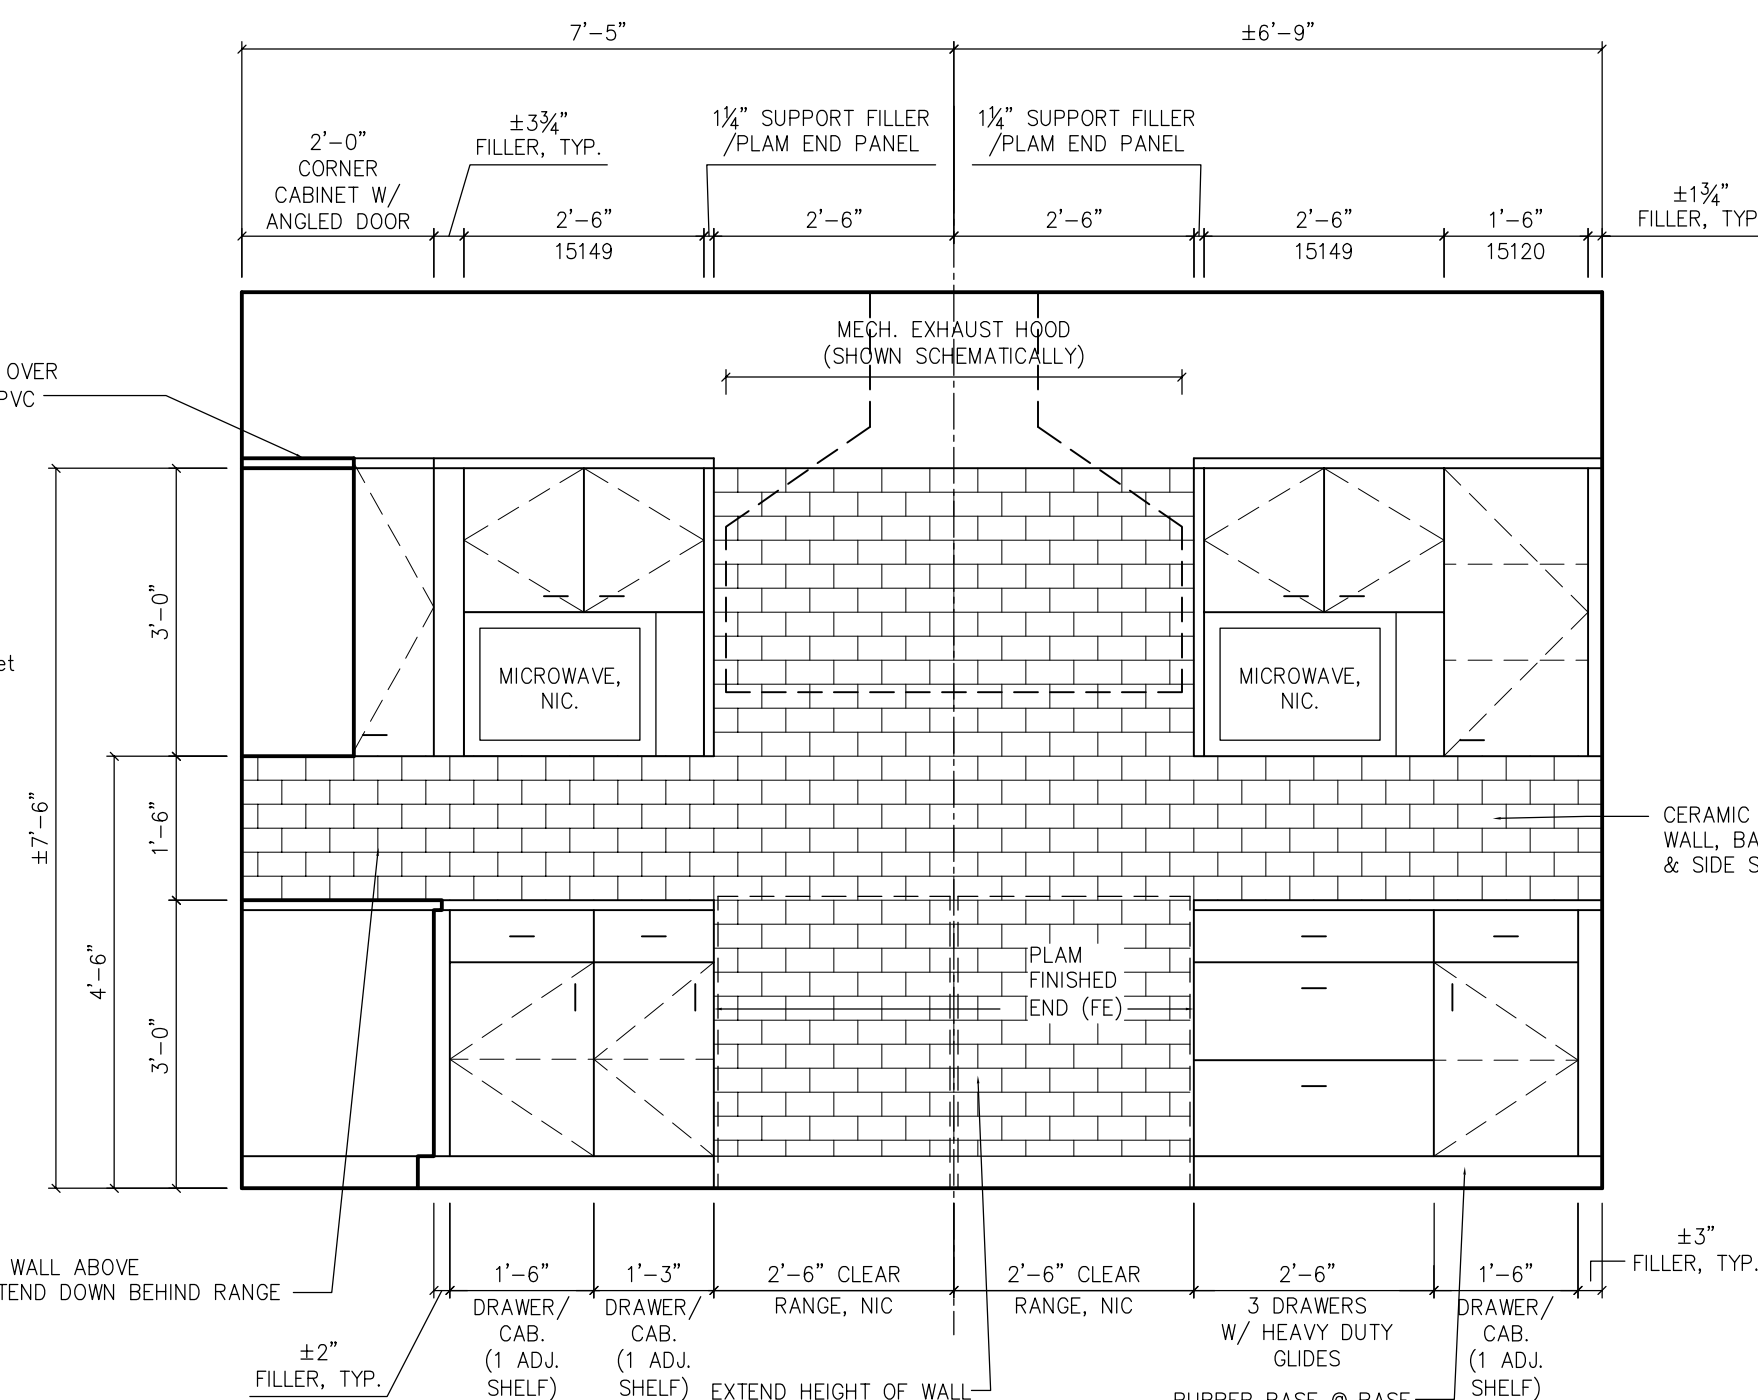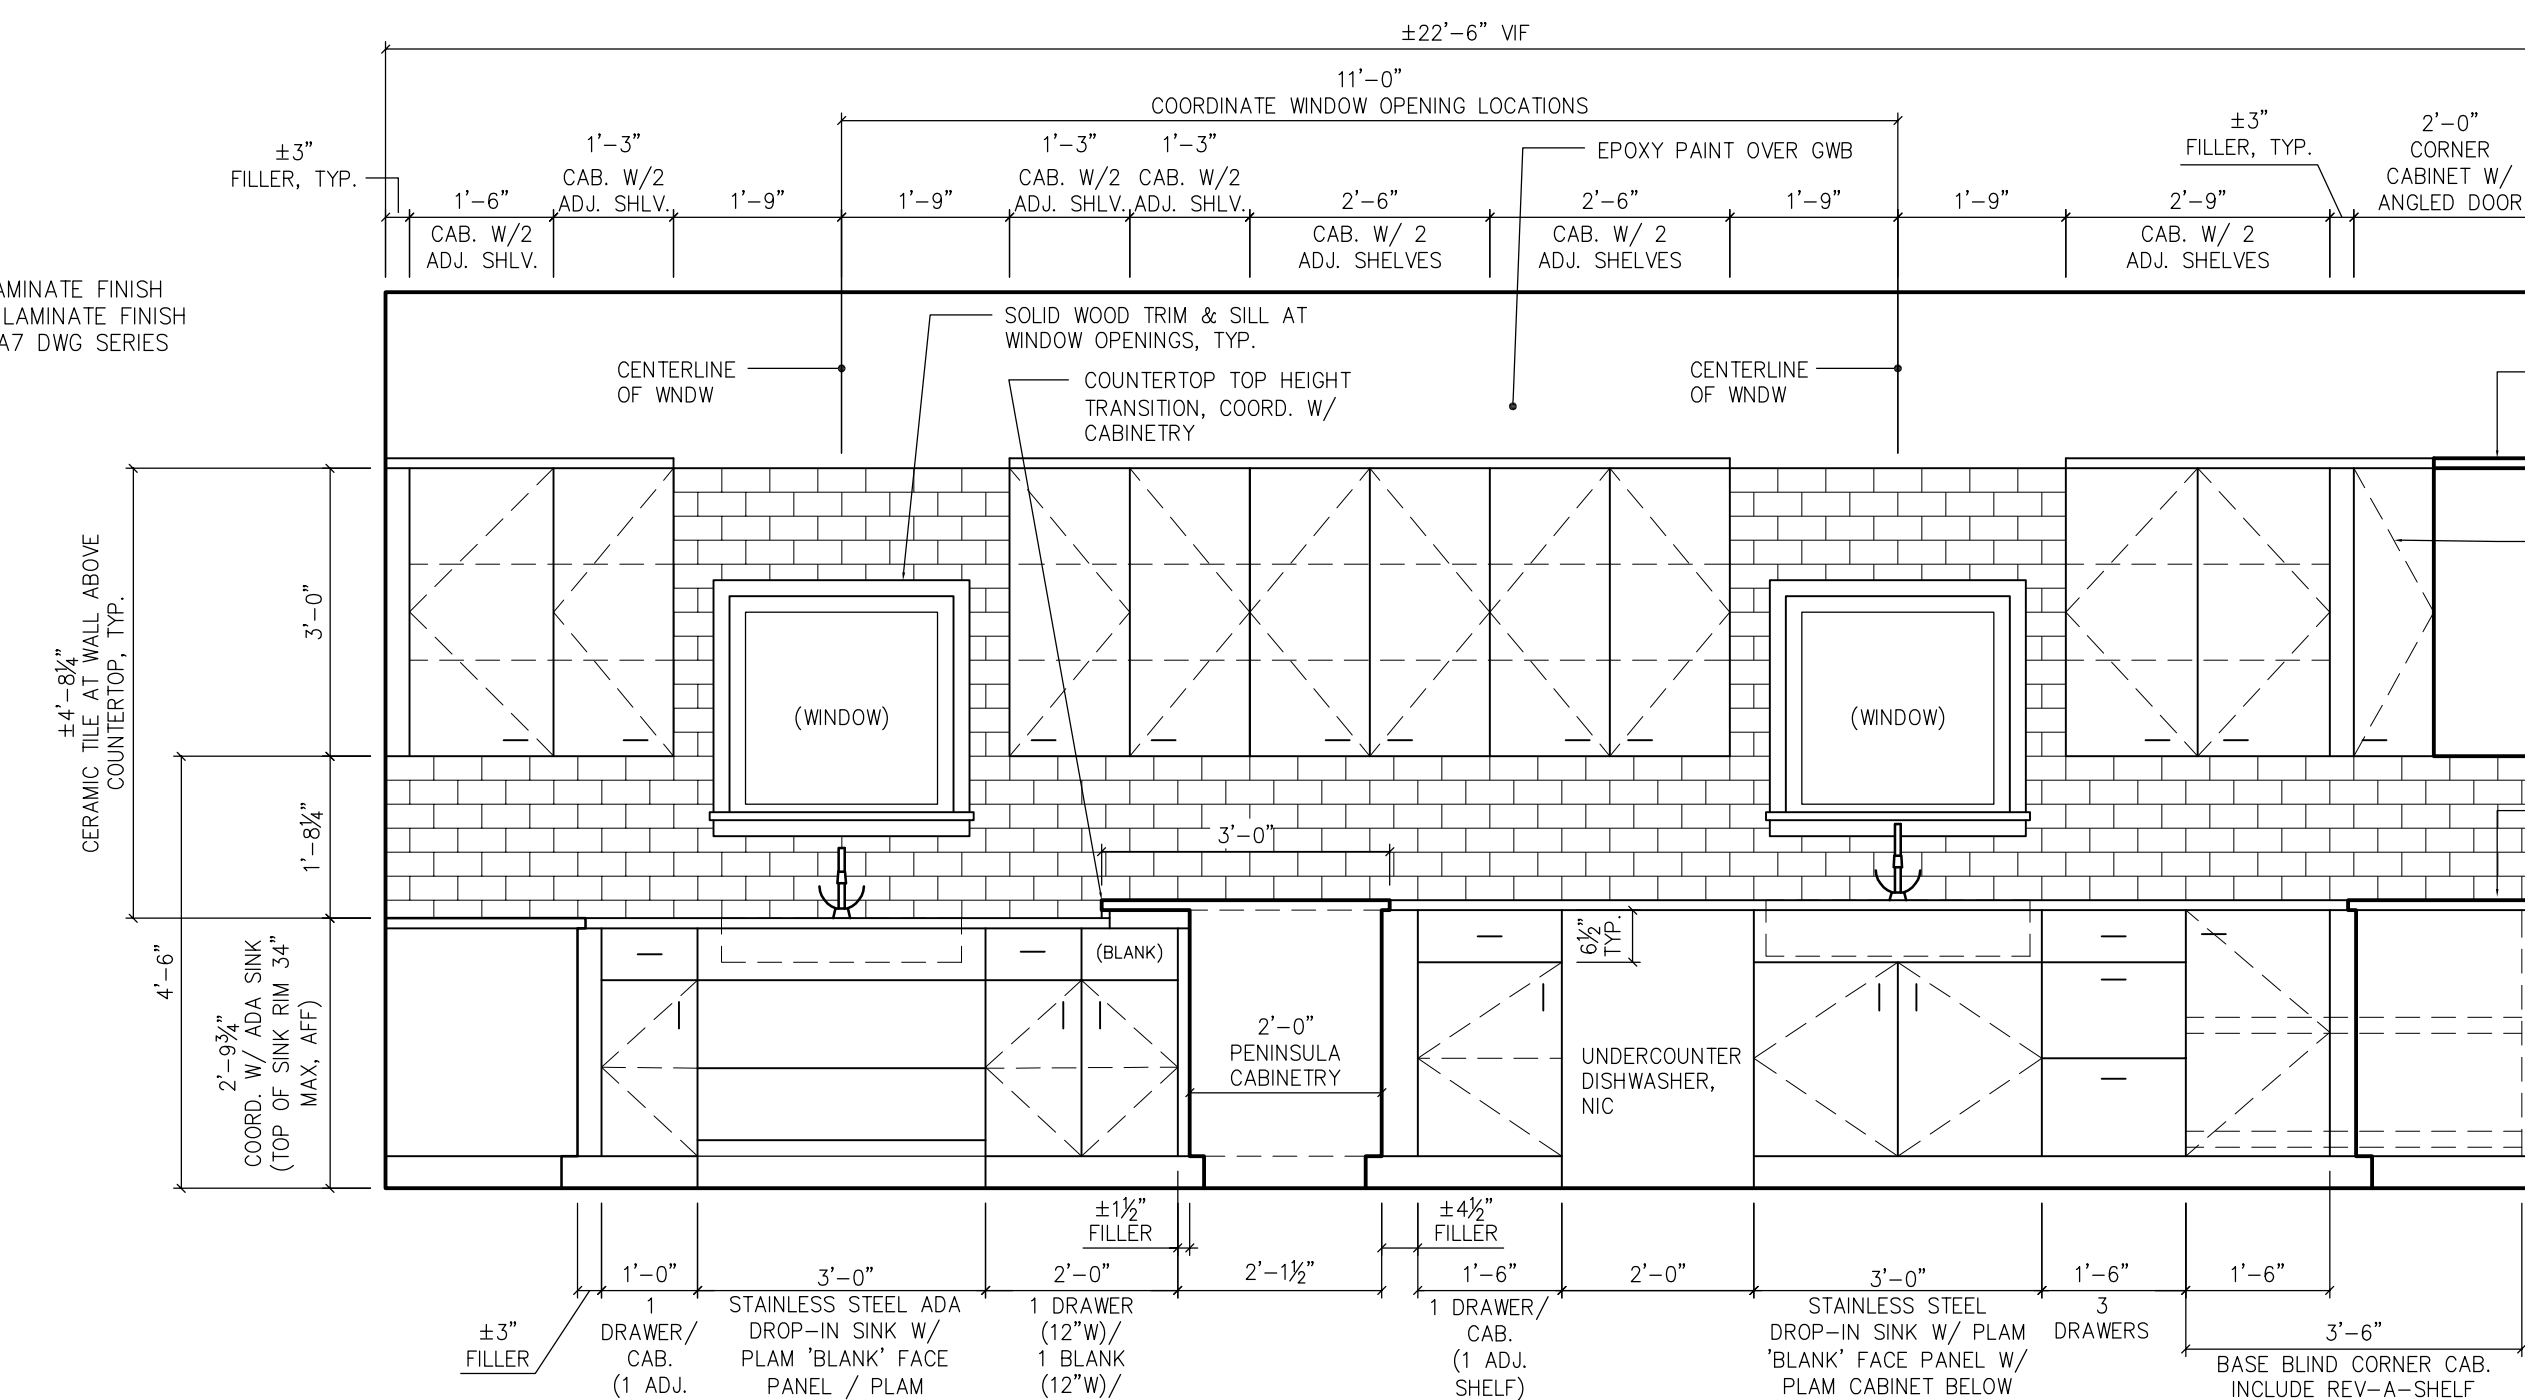

SACRISTY - RM. 105, TYP.
- CABINETRY = STAINED WOOD FINISH
- COUNTERTOP = PLASTIC LAMINATE FINISH
- REF. FINISH LEGEND ON A7 DWG SERIES FOR SELECTED FINISHES

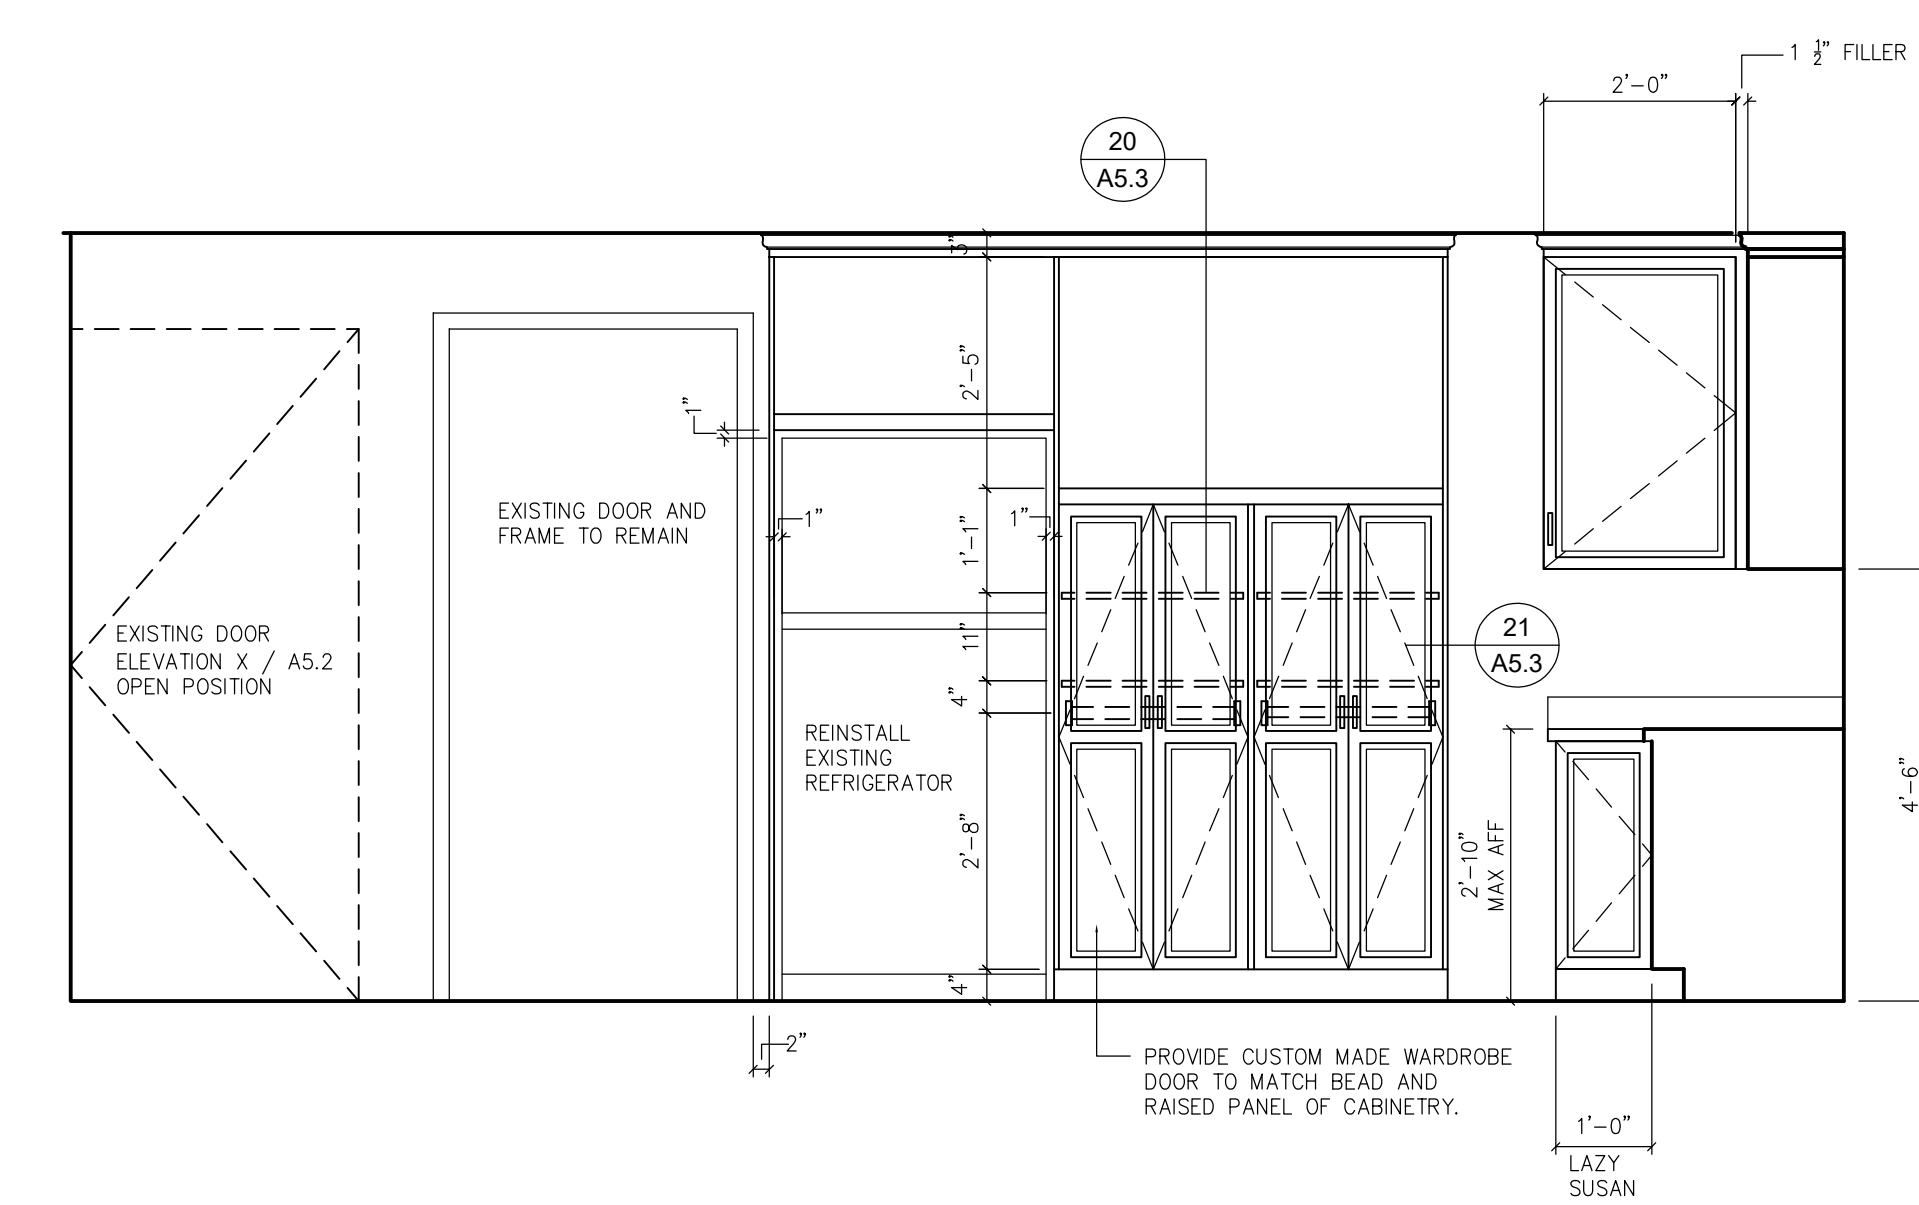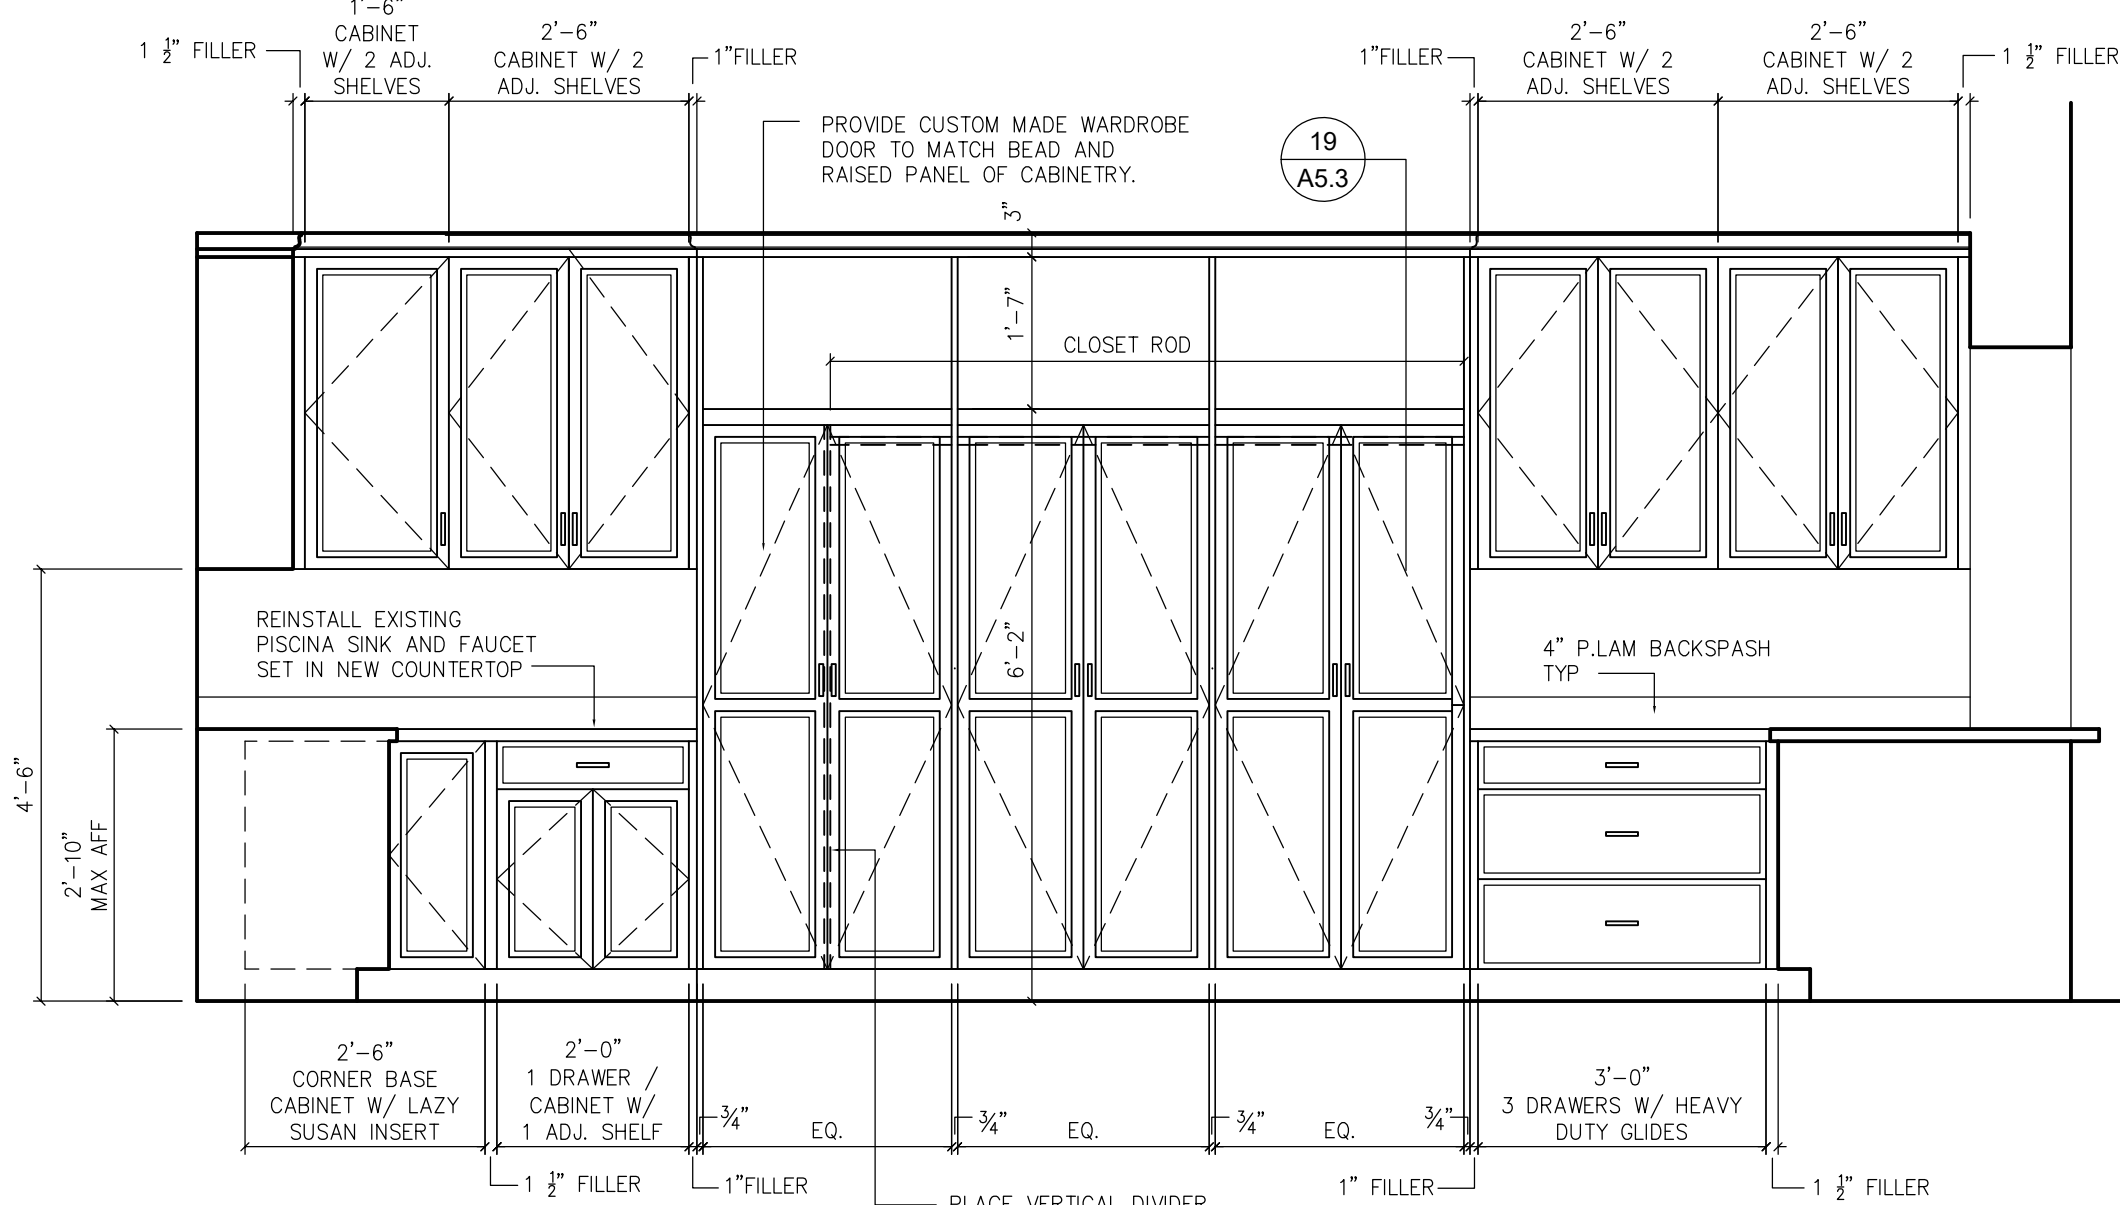

ADDITIONS AND RENOVATIONS FOR CHURCH OF THE HOLY SPIRIT

2871 BARNDT ROAD, HARLEYSVILLE, PA, 19438

REVISIONS	
4-12-2021	BID SET
DRAWN BY	PMO
REVIEWED BY	2416
JOB #	
SHEET TITLE	

INTERIOR ELEVATIONS

A5.2

SCALE	AS NOTED
DATE	4-12-2021

 






 



 



STAMP

CONSULTANTS

GODSHALL KANE O'ROURKE ARCHITECTS, LLC
300 Brookside Avenue
Harleysville, PA 17033
Amherst, PA 18802
T: 215.646.2003 F: 215.646.5707 W: gkarchitects.com



BID SET - APRIL 12, 2021

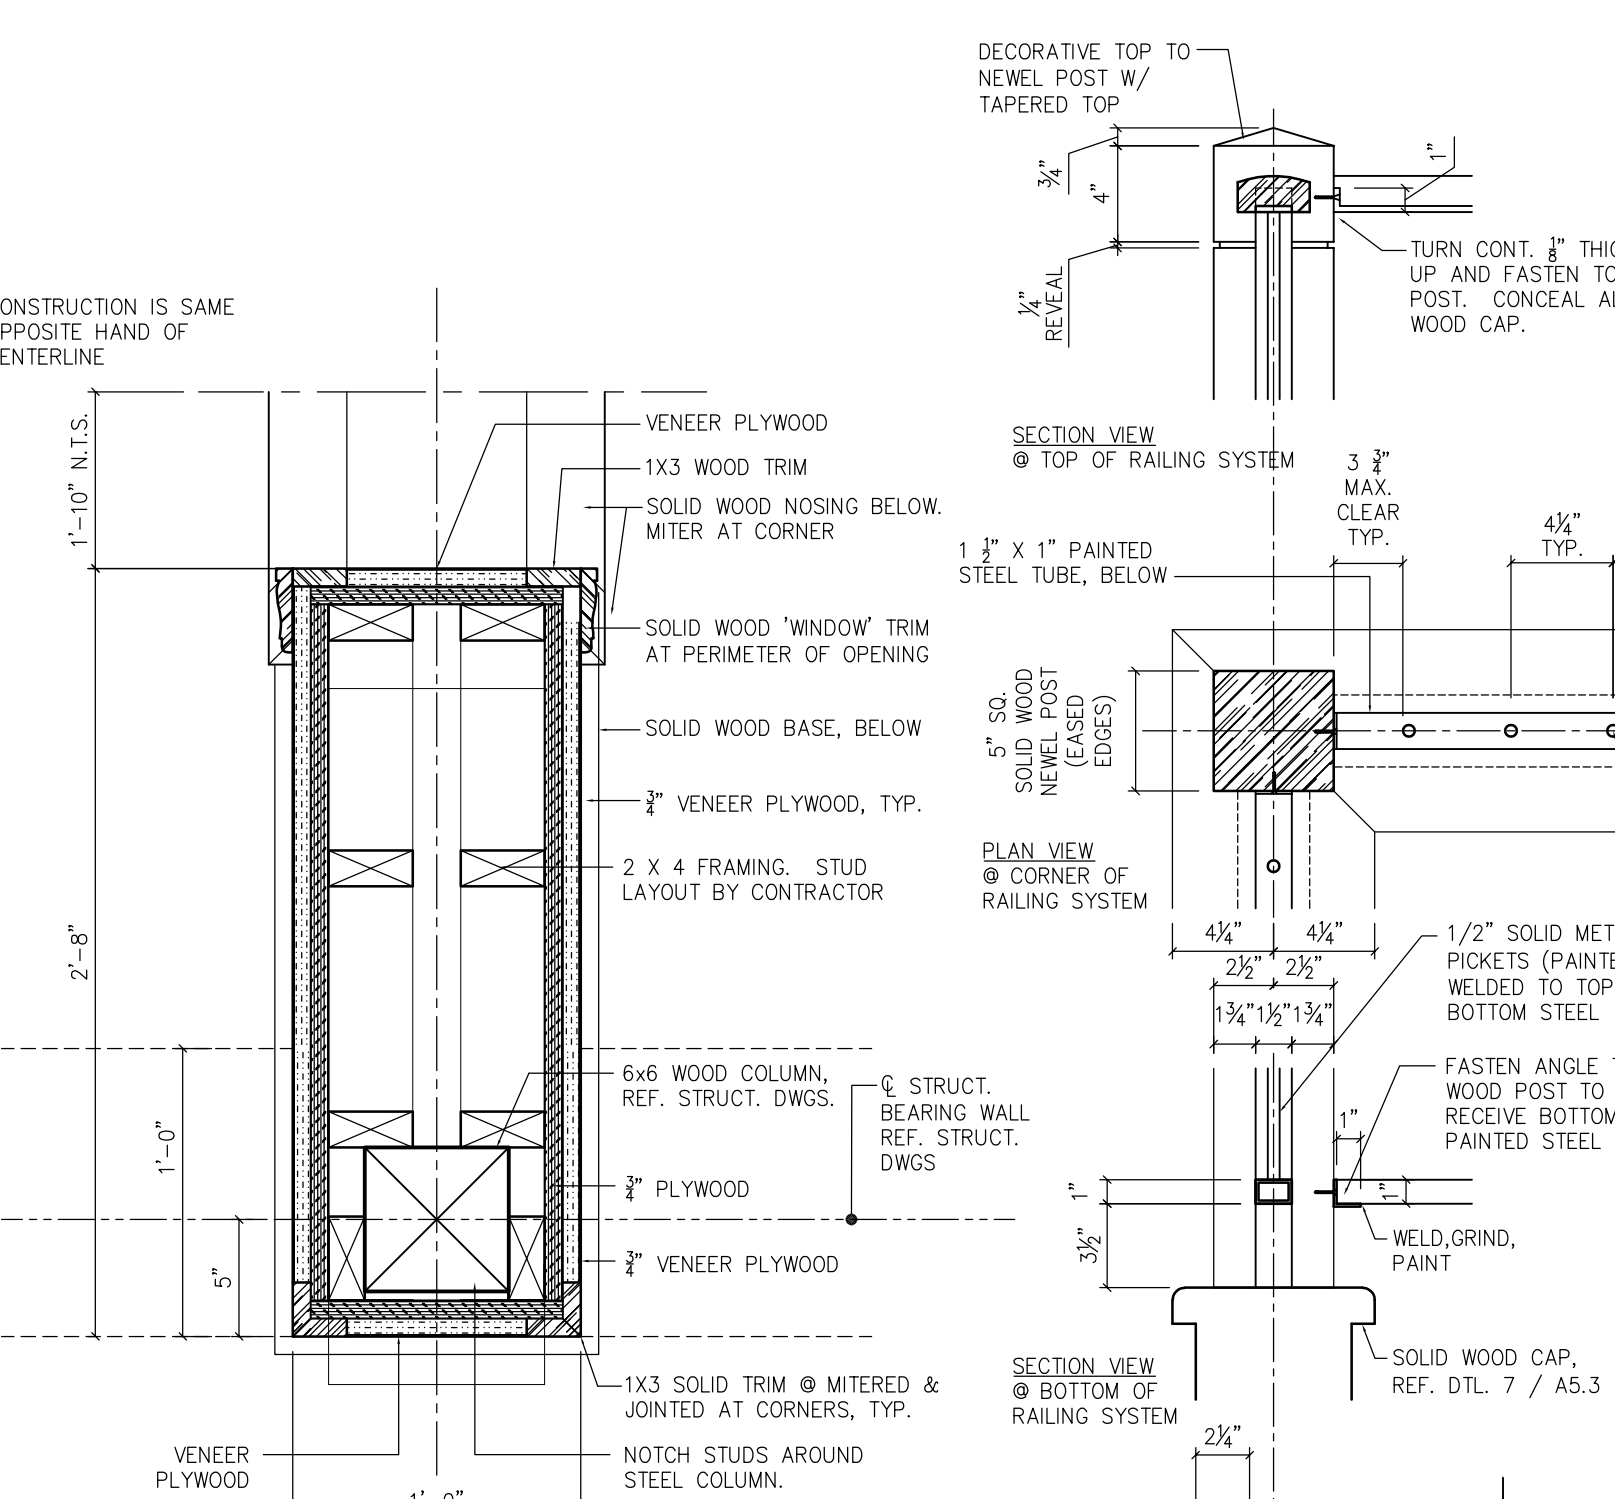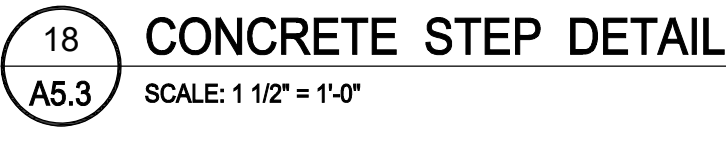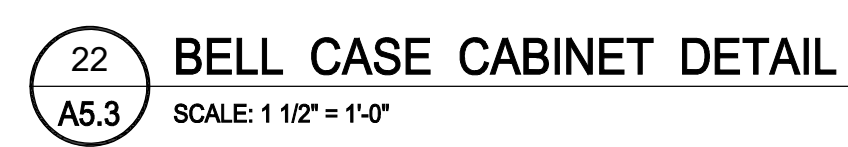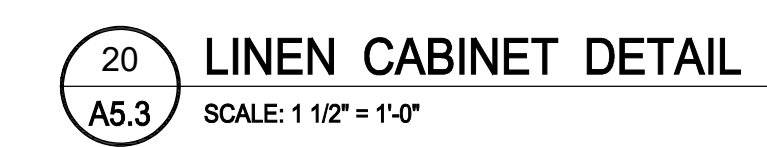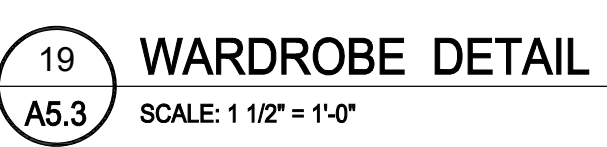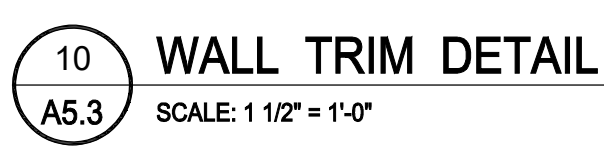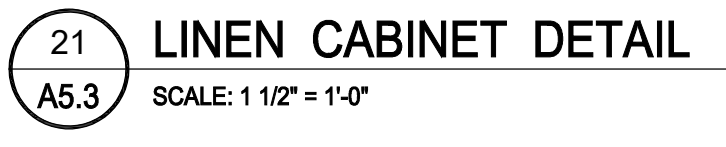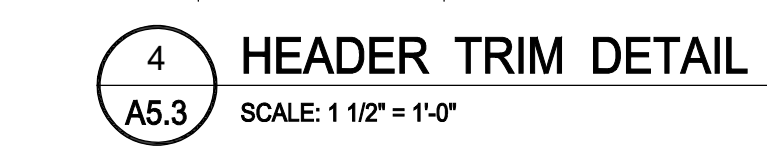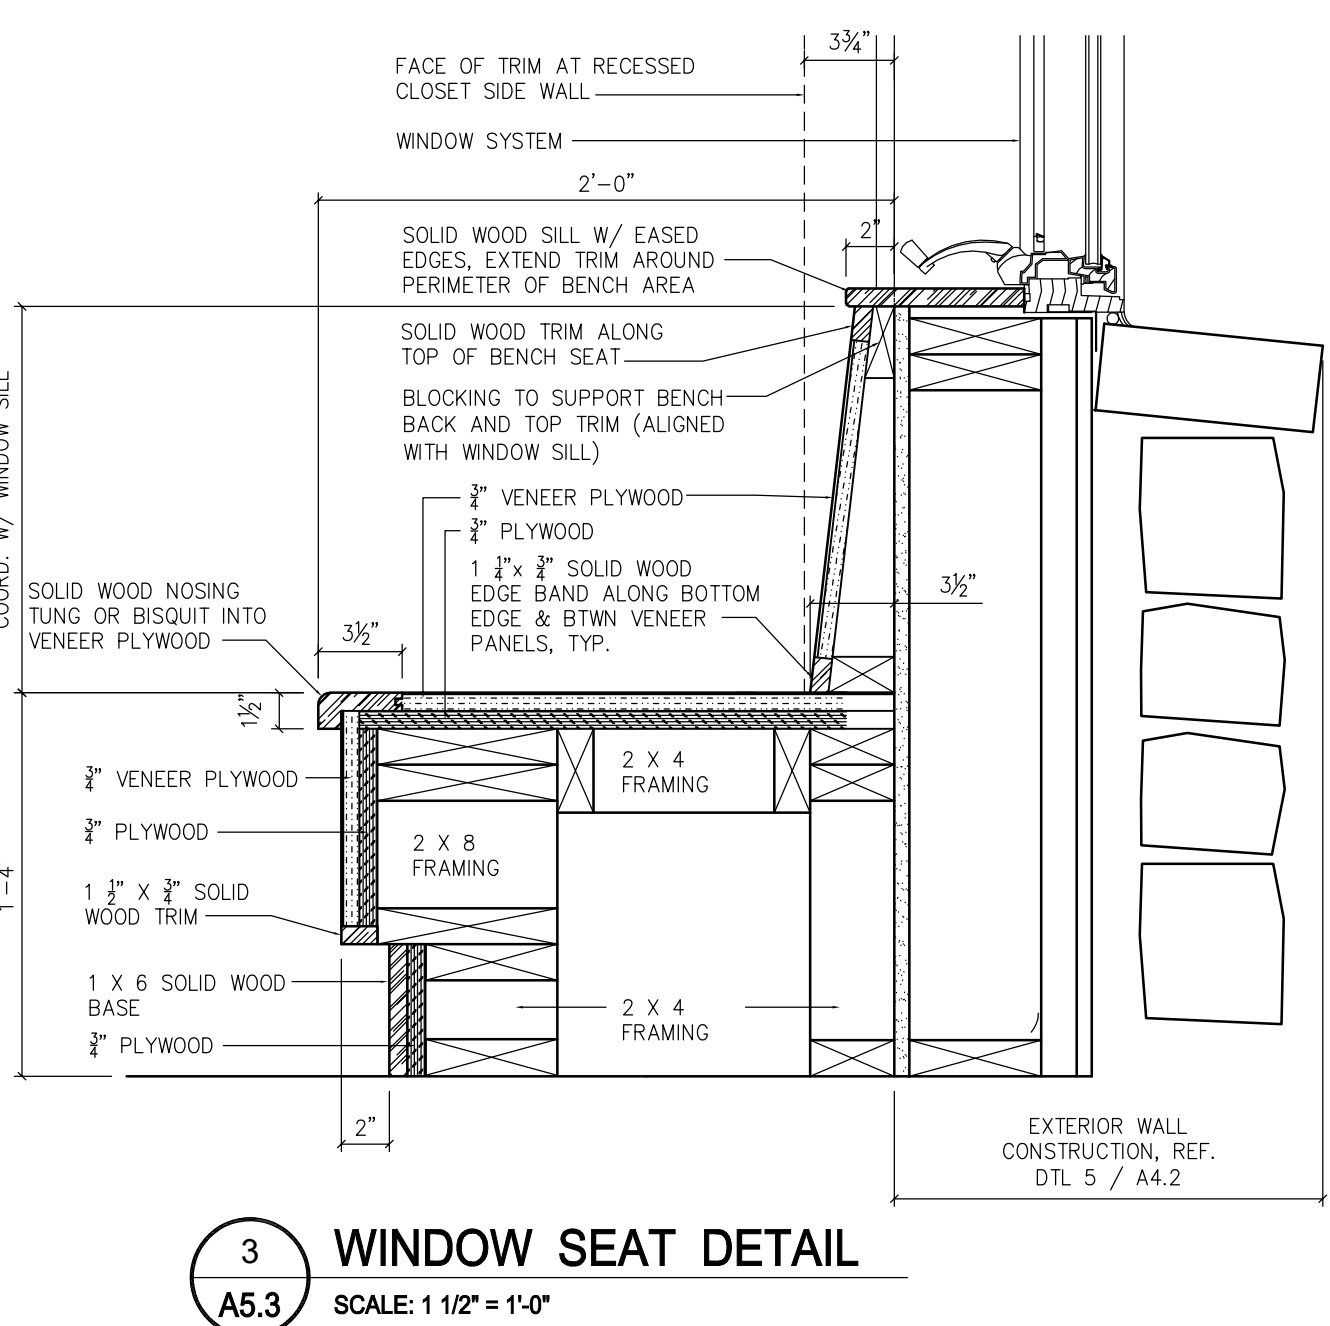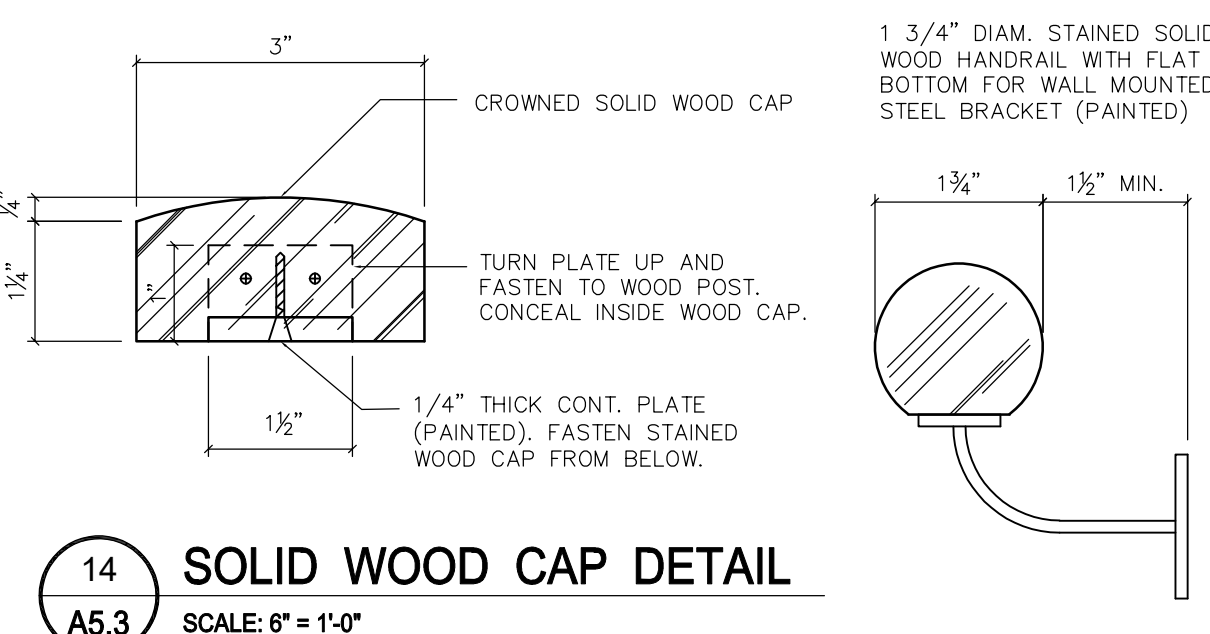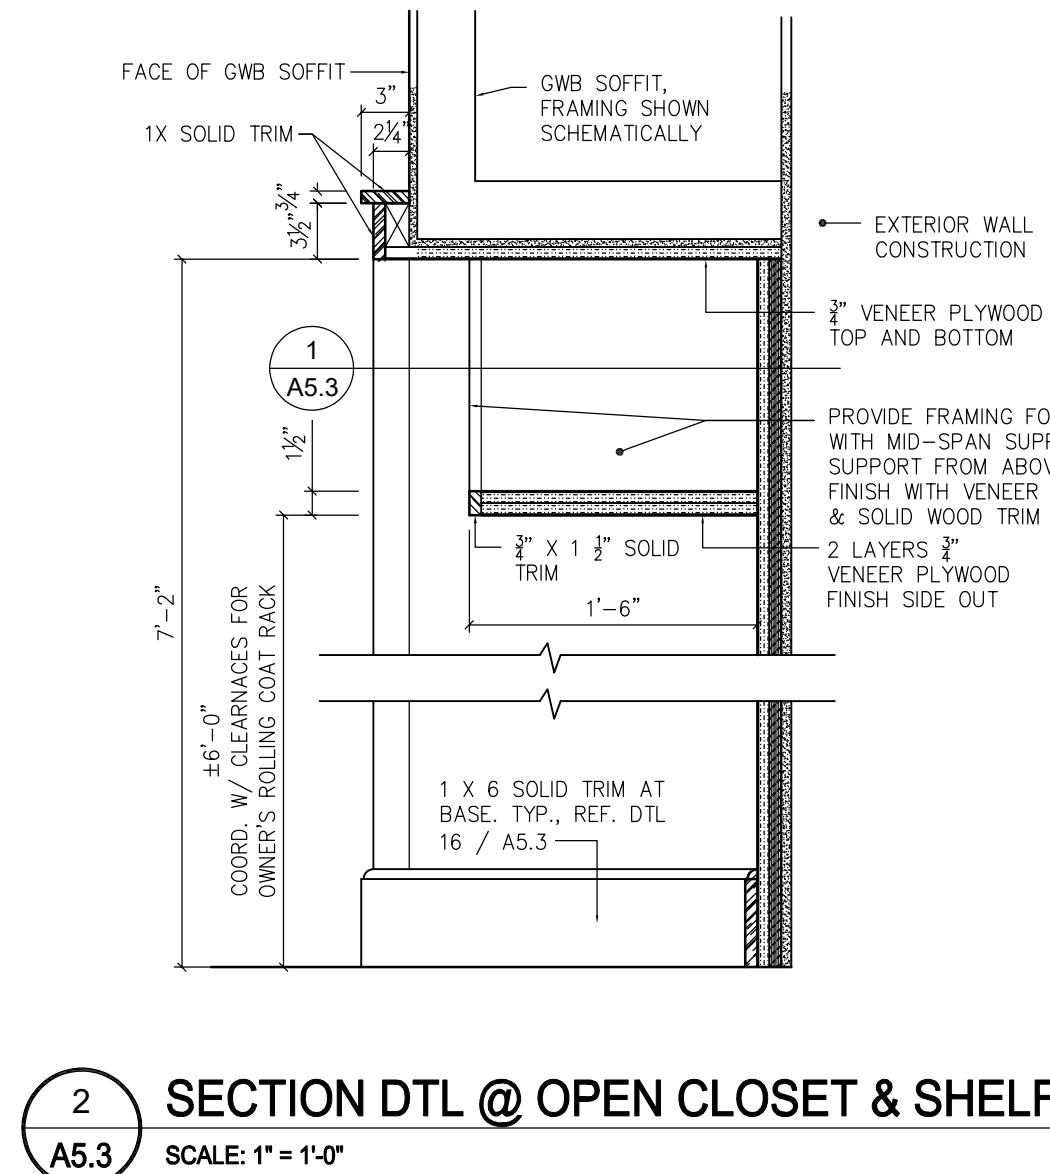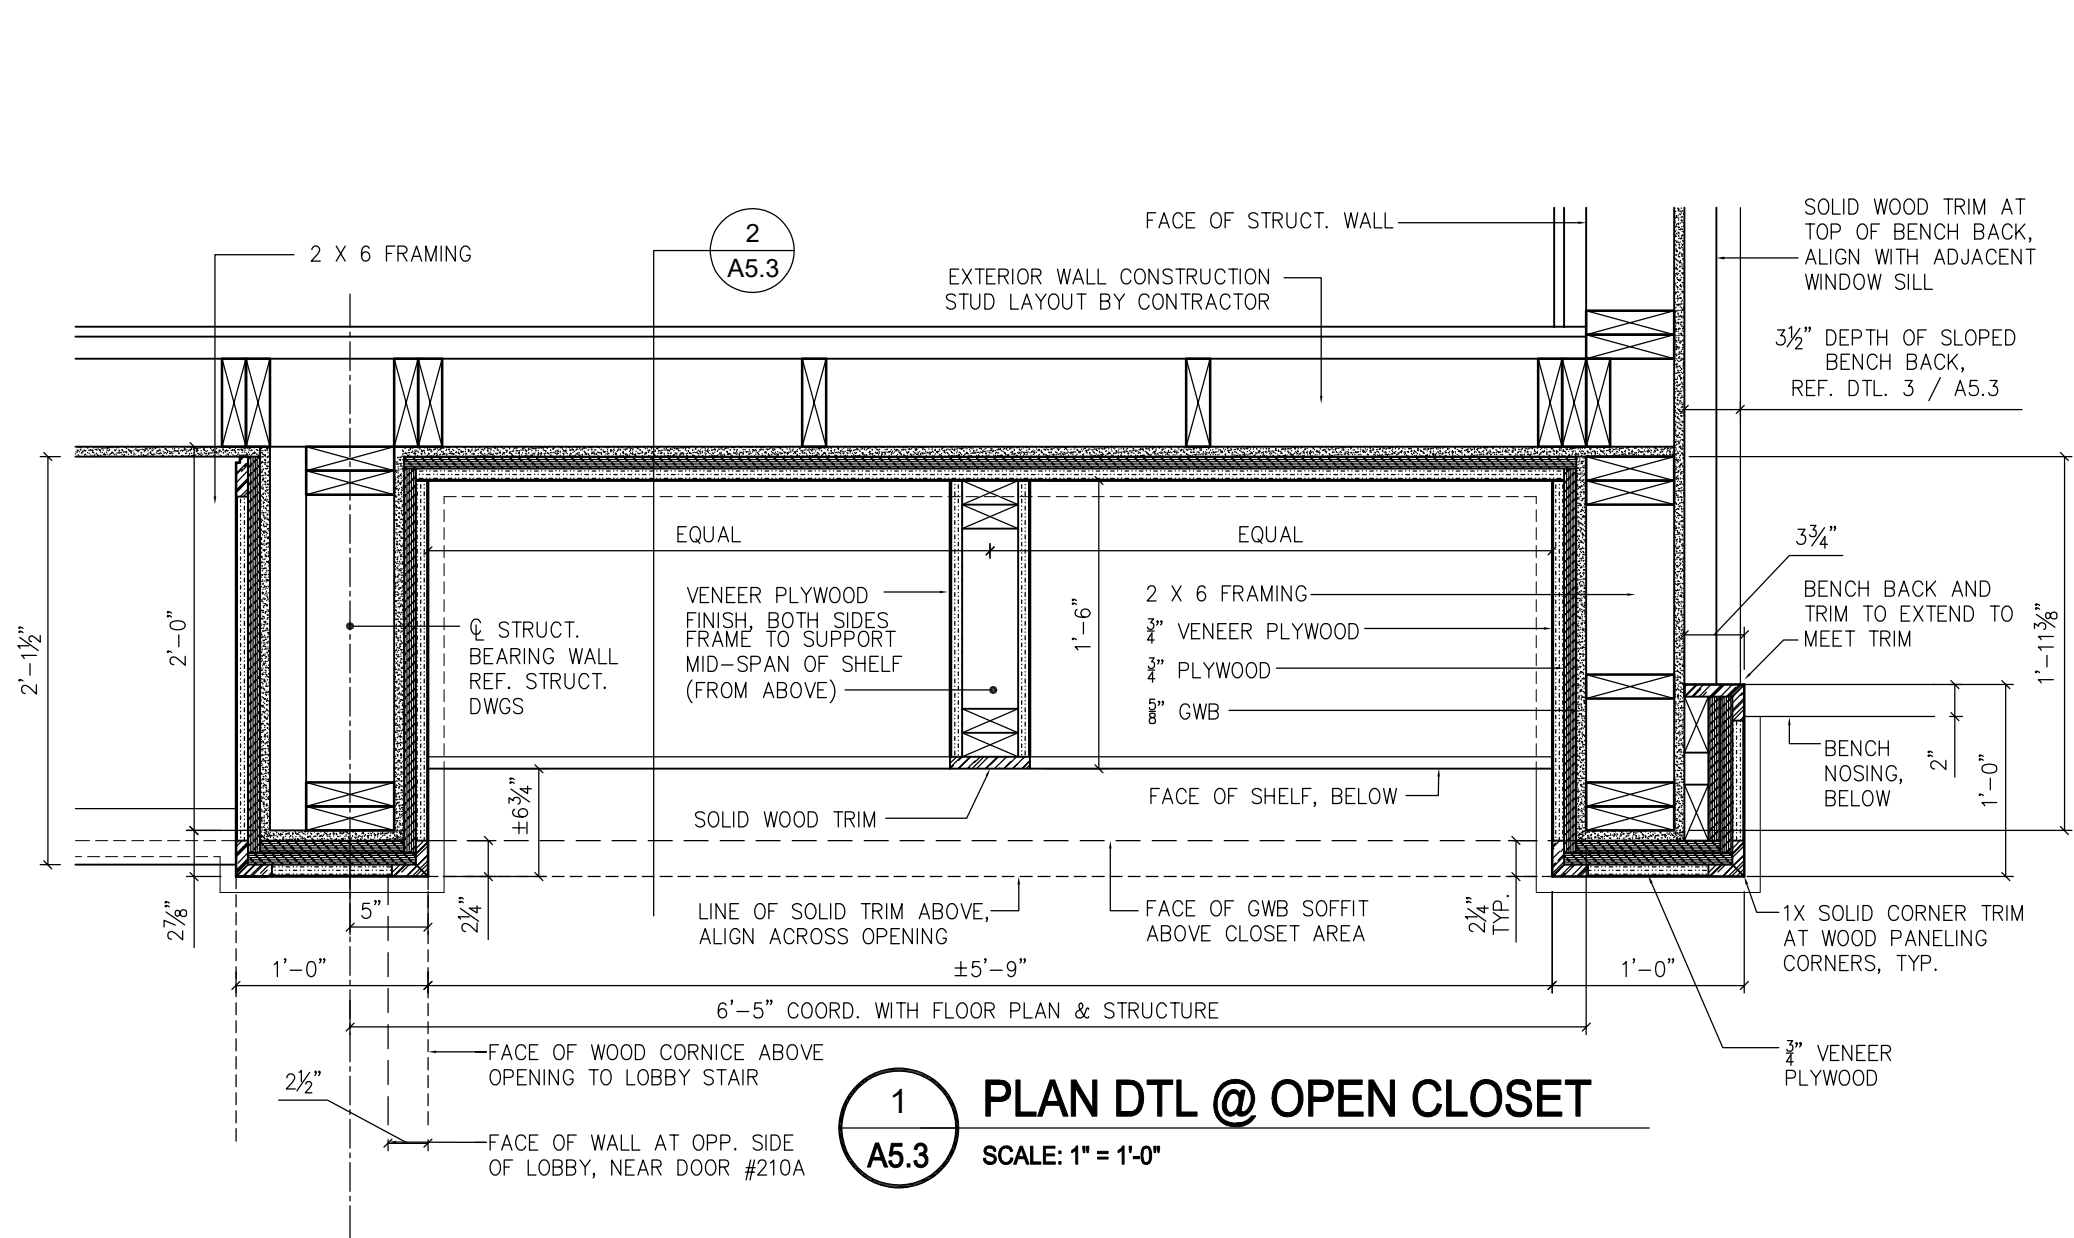

ADDITIONS AND RENOVATIONS FOR

CHURCH OF THE
HOLY SPIRIT

2871 BARNDT ROAD, HARLEYSVILLE, PA, 19438

REVISIONS

4-12-2021 BID SET

DRAWN BY

REVIEWED BY

JOB #

SHEET TITLE

INTERIOR
DETAILS

SHEET #

A5.3

SCALE

DATE

AS NOTED

4-12-2021

PMO

2416

2416


2416

FLOOR FINISH KEY:

- CARPET TILE
- CARPET TILE - WALK-OFF
- CERAMIC / PORCELAIN FLOOR TILE
- RESILIENT SHEET (VINYL)
- RESILIENT TILE (RUBBER - SLIP RESISTANT)


FLOORING TRANSITIONS:

- T1** METAL EDGE PROTECTION & TRANSITION @ TILE FLOOR: SCHLUTER RENO-TK (FINISH = SATIN ANODIZED ALUMINUM, TYPICAL). FLASH PATCH UNDER RESILIENT FLOOR TO MINIMIZE FLOORING TRANSITION HEIGHT.
- T2** METAL EDGE PROTECTION & TRANSITION @ TILE FLOOR: SCHLUTER RENO-V. ADHERE PER MANUF. RECOMMENDATIONS FOR ADJ. FLOORING FINISH. FLASH PATCH UNDER RESILIENT FLOOR TO MINIMIZE FLOORING TRANSITION HEIGHT.
- T3** ROPPE - RUBBER ROLLING TRAFFIC TRANSITION, OR SIMILAR - COORDINATE PROFILE/SIZE W/ ADJACENT FLOOR FINISHES, FLASH PATCH AS REQUIRED TO MINIMIZE TRANSITION.
- T4** (SIMILAR TO "T1", ABOVE)
- T5** ROPPE - RUBBER CARPET JOINER, OR SIMILAR
- T6** AT TILE STAIR TREADS & RISERS, PROVIDE METAL STAIR NOSING TRANSITIONS: SCHLUTER SYSTEMS "TREP-G" WITH SLIP RESISTANT WEAR SURFACE IN CONTRASTING COLOR FROM ADJACENT TILE.

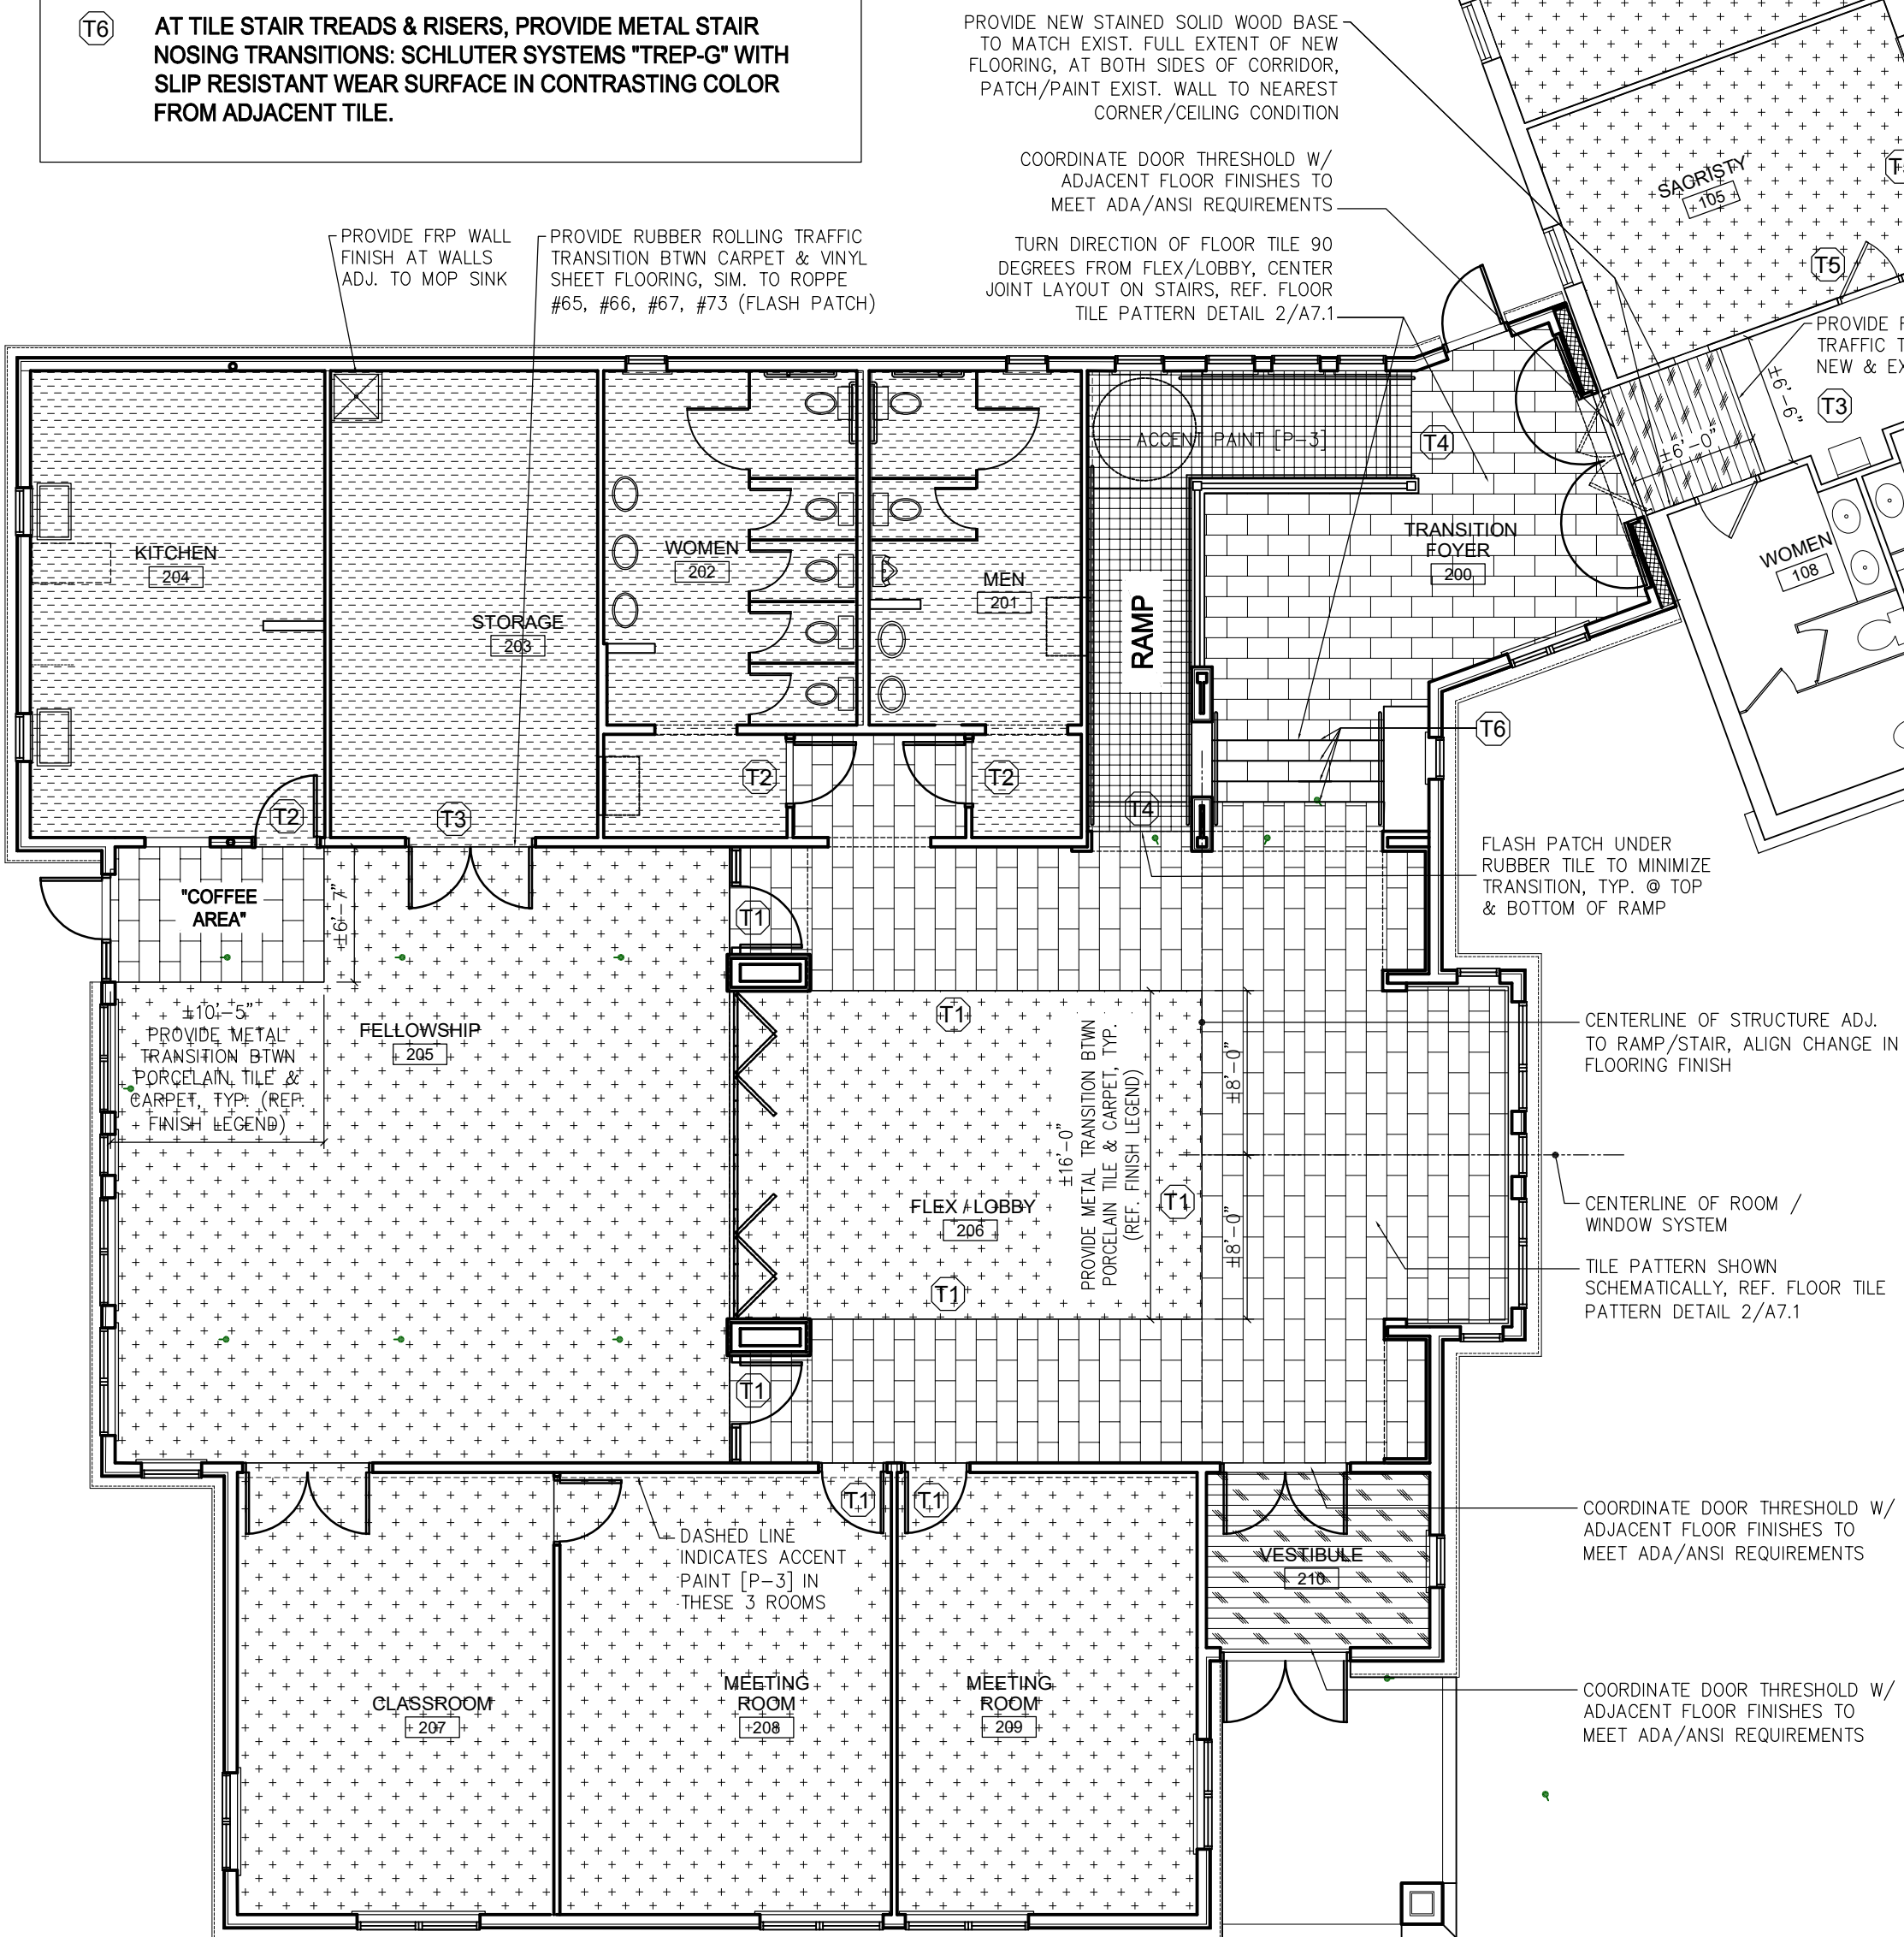

FINISH PLAN

SCALE: 1/8" = 1'-0"

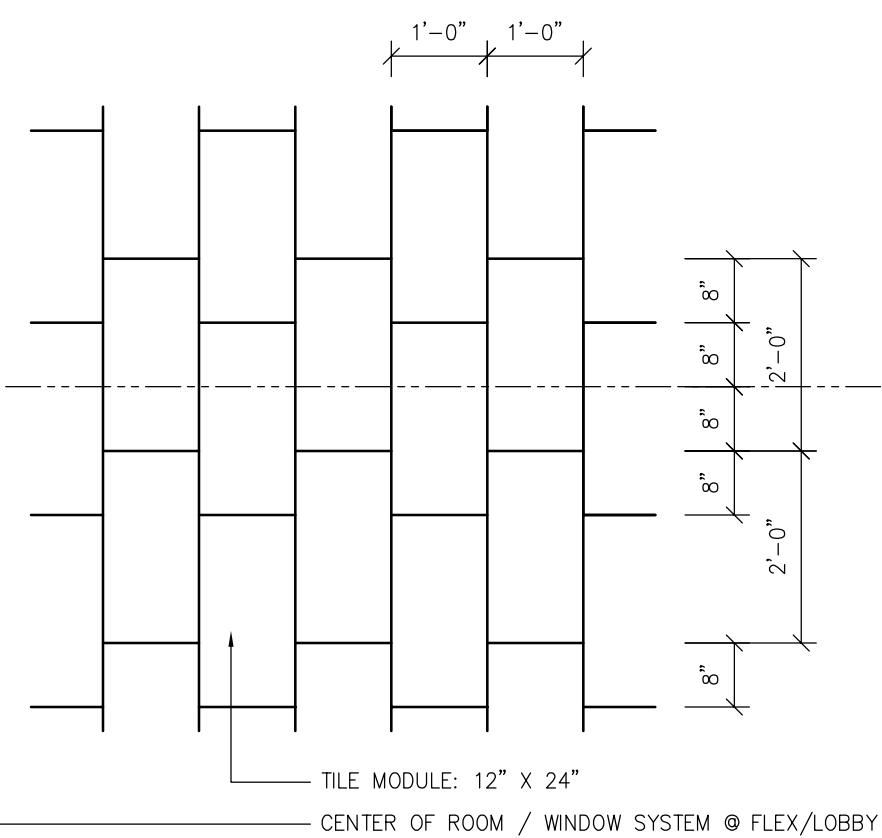

FLOOR TILE PATTERN DETAIL

SCALE: 1/2" = 1'-0"

INTERIOR FINISH - ROOM SCHEDULE

ROOM #	ROOM NAME	FINISH	BASE	N	E	S	W	REMARKS
EXISTING BUILDING:								
100	UTILITY ROOM	-	-	-	-	-	-	
101	CLASSROOM	-	-	-	-	-	-	
102	CLASSROOM	-	-	-	-	-	-	
103	CHOIR VESTMENTS MUSIC LIBRARY	CARP-1	RB			[P-1]		PROVIDE RUBBER TRANSITION STRIP BTWN NEW CARPET TILE & EXISTING BROADLOOM CARPETING
104	STORAGE	-	-	-	-	-	-	
105	SACRISTY	CARP-1	RB			[P-1]		PROVIDE RUBBER TRANSITION STRIP BTWN NEW CARPET TILE & EXISTING BROADLOOM CARPETING
106	FLEX MEETING ROOM	-	-	-	-	-	-	
107	CORRIDOR	-	-	-	-	-	-	
108	WOMEN'S RESTROOM	-	-	-	-	-	-	
109	MEN'S RESTROOM	-	-	-	-	-	-	
110	NURSERY	-	-	-	-	-	-	
111	ASSISTANT PASTOR	-	-	-	-	-	-	
112	FINANCE OFFICE	-	-	-	-	-	-	
113	VESTIBULE	-	-	-	-	-	-	
114	NARTHEX	-	-	-	-	-	-	
115	ADMIN OFFICE	-	-	-	-	-	-	
116	PASTOR OFFICE	-	-	-	-	-	-	
117	CORRIDOR	-	-	-	-	-	-	
118	MUSIC DIRECTOR OFFICE	-	-	-	-	-	-	
119	WORSHIP	-	-	-	-	-	-	
NEW ADDITION:								
200	TRANSITION FOYER	CT-F & RT @ RAMP	STAINED SOLID WOOD			[P-1] / [P-3] / [P-HM]		
201	MEN'S RESTROOM	RS-2	RB-2			[P-1] EPOXY / FRP / [P-HM]		
202	WOMEN'S RESTROOM	RS-2	RB-2			[P-1] EPOXY / FRP / [P-HM]		
203	STORAGE	RS-1	RB-2			[P-1] EPOXY / FRP / [P-HM]		
204	KITCHEN	RS-1	RB-2			[P-1] EPOXY / [P-HM] / CT-W		
205	FELLOWSHIP	CARP-1	STAINED SOLID WOOD			[P-1] / [P-3] / [P-HM] [P-C] @ GWB CEILING		
206	FLEX / LOBBY	CT-F & CARR-1	STAINED SOLID WOOD			[P-1] / [P-3] / [P-3] / [P-HM] [P-C] @ GWB CEILING		
207	CLASSROOM	CARP-1	RB-1			[P-1] / [P-3] / [P-HM]		
208	MEETING ROOM	CARP-1	RB-1			[P-1] / [P-3] / [P-HM]		
209	MEETING ROOM	CARP-1	RB-1			[P-1] / [P-3] / [P-HM]		

INTERIOR FINISH - LEGEND OF MATERIALS

FINISHES - CERAMIC TILE:			
ABBREVIATION	MATERIAL / DESCRIPTION	MANUFACTURE / STYLE / COLOR / MISC.	REMARKS
CT-F	CERAMIC TILE (PORCELAIN TILE) - FLOOR	GARDEN STATE TILE (GST) STYLE: RENOVATION COLOR: GOLDEN GREY SIZE: 12 INCH X 24 INCH	- TILE PATTERN: 33% OFFSET, REF. 2/A7.1 - REFERENCE FLOORING TRANSITIONS [T#] LEGEND ON SHEET A7.1.
CT-W#	CERAMIC TILE - WALL	MANUF: DALTILE STYLE: COLORWHEEL CLASSICS SUBWAY - 3 INCH X 6 INCH W/ BEVELED EDGE COLOR: #790 MATTE ARCTIC WHITE (OR SIMILAR PRODUCT BY GST - ONDA TILE)	- TILE PATTERN: 50% OFFSET - PROVIDE METAL TRANSITION AT EXPOSED EDGES OF WALL TILE: SCHLUTER SYSTEMS - JOLLY - ANODIZED ALUMINUM FINISH
FINISHES - FLOORING:			
CARP-1	CARPET TILE	SHAW - STYLE: KNIT TILE #9492 - COLOR: SERENE SKY #91595	INSTALLATION METHOD: ASHLAR
CARP-WO	CARPET TILE - WALK-OFF	SHAW - STYLE: WELCOME II TILE #57031 - COLOR: (TO BE SELECTED FROM FULL RANGE)	INSTALLATION METHOD: MONOLITHIC
RB-1	RUBBER BASE (VULCANIZED)	ROPPE - PINNACLE - RUBBER BASE - 6 INCHES HIGH - COLOR: (TO BE SELECTED FROM FULL RANGE)	GC OPTION TO PROVIDE SIMILAR PRODUCT BY TARKETT-JOHNSONITE.
RB-2	RUBBER BASE (VULCANIZED)	ROPPE - PINNACLE - RUBBER BASE - 6 INCHES HIGH - COLOR: (TO BE SELECTED FROM FULL RANGE)	
RS-1	RESILIENT SHEET (HETEROGENEOUS PVC)	OWNER'S OPTION TO CHOOSE TWO OF THE FOLLOWING: 1) ALTRO OPERETTA / STYLE-COLOR: (TO BE SELECTED FROM FULL RANGE) 2) TARKETT ACCENT FLOURISH / STYLE: PROSPER / COLOR: (TO BE SELECTED FROM FULL RANGE)	PRODUCT(S) MUST HAVE: - THICKNESS: 2.0 MM MINIMUM - SLIP RESISTANCE / STATIC COEFFICIENT OF FRICTION: 0.80 COF MINIMUM - WEAR LAYER THICKNESS: 0.7 MM MINIMUM GC/PC NOTE: PLUMBING FLOOR DRAINS TO BE SURFACE MEMBRANE CLAMPING MODELS. FIXTURES TO MECHANICALLY FASTEN, CLAMP AND SEAL FLOORING EDGE TO PREVENT MOISTURE FROM PENETRATING UNDERNEATH FLOORING MEMBRANE. COORDINATE INSTALLATION WITH FLOORING MANUFACTURER'S WARRANTY REQUIREMENTS.
RS-2	RESILIENT SHEET (HETEROGENEOUS PVC)		GC OPTION TO PROVIDE SIMILAR PRODUCT BY TARKETT-JOHNSONITE.
RT	RESILIENT TILE (RUBBER TILE (VULCANIZED W/ ANTI-SLIP CORK ADDITIVE)	ROPPE - RENEW - COLOR: (TO BE SELECTED FROM FULL RANGE)	PRODUCT(S) HAVE SLIP RESISTANCE - STATIC COEFFICIENT OF FRICTION > 0.80 COF MINIMUM
FINISHES - PAINT			
ABBREVIATION	MATERIAL / DESCRIPTION	MANUFACTURE / STYLE / COLOR / MISC.	REMARKS
P-1	PAINT #1 (WHITE)	SW 7021 - SIMPLE WHITE (260-C7)	
P-2	PAINT #2 (LT. TONE)	SW 6085 - SIMPLIFY BEIGE (197-C1)	
P-3	PAINT #3 (MED. TONE)	SW 7642 - PAVESTONE (283-C5)	
P-C	PAINT - CEILING	SW 7021 - SIMPLE WHITE (260-C7)	
P-HM	PAINT - HOLLOW METAL	SW 2848 - ROYCROFT PEWTER	
P-X-WHITE	EXISTING PAINT - "WHITE"	SW ### (SIMILAR TO P-1)	PROVIDE PAINT OPTION TO MATCH "WHITE" PAINT AT EXISTING WALLS ADJACENT TO RENOVATIONS
P-X-GREEN	EXISTING PAINT - "GREEN"	SW ###	PROVIDE PAINT OPTION TO MATCH "DARK GREEN" AS NEEDED FOR TOUCH-UP AT EXISTING HOLLOW METAL FRAMES ADJACENT TO RENOVATIONS
FINISHES - PLASTIC LAMINATE			
ABBREVIATION	MATERIAL / DESCRIPTION	MANUFACTURE / STYLE / COLOR / MISC.	REMARKS
PLAM-K1	PLASTIC LAMINATE @ KITCHEN COUNTERTOP	(TO BE SELECTED)	
PLAM-K2	PLASTIC LAMINATE @ KITCHEN BASE CABINETS	(TO BE SELECTED)	PLASTIC LAMINATES TO BE SELECTED FROM THE FOLLOWING MANUF. & PRODUCT LINES: - COUNTERTOPS: WILSONART HD SURFACES (W/ ANTIMICROBIAL PROTECTION AND ENHANCED SCRATCH-RESISTANT AEON TECHNOLOGY) / PATTERN TO BE SELECTED FROM FULL LINE OF MANUF. OPTIONS - CABINETRY: WILSONART PREMIUM LAMINATE DESIGNS (W/ AEON ENHANCED PERFORMANCE TECHNOLOGY) / PATTERN TO BE SELECTED FROM FULL LINE OF MANUF. OPTIONS
PLAM-K3	PLASTIC LAMINATE @ KITCHEN WALL CABINETS	(TO BE SELECTED)	
PLAM-K4	PLASTIC LAMINATE @ SACRISTY COUNTERTOP	(TO BE SELECTED)	
PLAM-T1	PLASTIC LAMINATE @ TOILET ROOM COUNTERTOP	(TO BE SELECTED)	
PLAM-T2	PLASTIC LAMINATE @ TOILET ROOM CABINETS	(TO BE SELECTED)	
FINISHES - CEILING			
ABBREVIATION	MATERIAL / DESCRIPTION	MANUFACTURE / STYLE / COLOR / MISC.	REMARKS
APC-2X2	ACOUSTICAL PANEL CEILING - 2X2	CERTANTEED - SYMPHONY M #12228B-75-1 SIZE: 24 IN X 24 IN X 3/4 IN / 1/8 IN GRID / "REVEAL" EDGE / NRC 0.75	REF. REFLECTED CEILING PLAN (RCP) FOR INSTALLATION LOCATIONS. (COORD. W/ OWNER IF PRODUCT SHOULD MATCH SIMILAR SIZED TILE IN EXISTING BUILDING)
APC-2X4	ACOUSTICAL PANEL CEILING - 2X4	CERTANTEED - SYMPHONY M #12208B-75-1 SIZE: 24 IN X 48 IN X 3/4 IN / 1/8 IN GRID / "REVEAL" EDGE / NRC 0.75	REF. REFLECTED CEILING PLAN (RCP) FOR INSTALLATION LOCATIONS.
APC-K	ACOUSTICAL PANEL CEILING - KITCHEN	CERTANTEED - VINYLROCK #1142-CRF-1 SIZE: 24 IN X 24 IN X 1/2 IN / 1/8 IN GRID / "TRIM" EDGE	REF. REFLECTED CEILING PLAN (RCP) FOR INSTALLATION LOCATIONS. VINYL-FACED TO MEET KITCHEN REQ.
-	ACOUSTICAL FABRIC WRAPPED PANELS - CEILING MOUNTED	MBI - COLORSONIX - 2" THICK SIZE (AS NOTED ON RCP) TYPE: Series 1800F-2060-ZIN / BEVELED EDGE FABRIC: GULFORD OF MAINE - FR 701 - 2100 FABRICS - COLOR: (TO BE SELECTED FROM FULL RANGE OF OPTIONS)	- REF. REFLECTED CEILING PLAN (RCP) FOR INSTALLATION & CUSTOM SIZES & SHAPES - ATTACH TO CEILING PER MANUFACTURER'S RECOMMENDATIONS - COORDINATE W/ SPEC. "SOUND ABSORBING CEILING UNITS"
FINISHES - MISCELLANEOUS:			
ABBREVIATION	MATERIAL / DESCRIPTION	MANUFACTURE / STYLE / COLOR / MISC.	REMARKS
FRP	FIBER-REINFORCED PLASTIC PANELING	CRANE COMPOSITES - DESIGN SERIES - PATTERN: (TO BE SELECTED FROM MANUF. FULL RANGE)	PROVIDE EDGE FINISHING TRIMS IN COLOR/PATTERN TO MATCH ADJACENT FRP PANELS
TP	TOILET PARTITIONS	SCRANTON INDUSTRIES - HINEY HIDERS SOLID PLASTIC PARTITIONS (HDPE) COLOR/FINISH: SANDCASTLE / OP (ORANGE PIEL)	
-	HARDWARE - DOOR	OIL RUBBED BRONZE	
-	HARDWARE - CABINETRY	2 OPTIONS TO BE SUBMITTED INCLUDING: - OIL RUBBED BRONZE @ SACRISTY - NICKEL @ KITCHEN	
-	STAINED WOOD CABINETRY	(STAINED TO MATCH EXISTING SOLID WOOD CABINETRY)	GC TO SUBMIT SAMPLES TO MATCH EXIST. STAINED WOOD CABINETRY, INCLUDING #MW 232 RED CHESTNUT & #MW 455 PINE RIDGE
-	STAINED SOLID WOOD TRIM & VENEER PLYWOOD	(STAINED TO MATCH EXISTING SOLID WOOD TRIM)	GC TO SUBMIT SAMPLES TO MATCH EXIST. STAINED WOOD TRIM, INCLUDING #MW 232 RED CHESTNUT & #MW 455 PINE RIDGE
-	STAINED WOOD DOORS	(STAINED TO MATCH NEW SOLID WOOD TRIM, ABOVE)	SUBMIT SAMPLES FROM MANUF. FULL LINE OF STAIN OPTION (ESTIMATED MATCHES: ASSA ABLOY #350 / 925 (MED. TONE) & #125 (LIGHT TONE))
-	STAINED WOOD ROLLING DOOR	(STAINED TO MATCH NEW SOLID WOOD TRIM, ABOVE)	
FINISHES - PRODUCT REPRESENTATIVES:			
-	CERTANTEED CEILINGS	CONTACT: COLLEEN EDWARDS #484-757-2445 EMAIL: COLLEEN.EDWARDS@SAINT-GOBAIN.COM	
-	GARDEN STATE TILE	CONTACT: CHRIS BENEK #215-316-1731 EMAIL: CBENEK@GSTILE.COM	
-	ROPPE & ALTRO PRODUCTS	STANLEY STEPHENS CO., INC. CONTACT: MARLYN SAENZ #215-832-2291 EMAIL: MSAENZ@SSTFLOOR.COM	
-	SHAW CONTRACT (COMMERCIAL CARPET)	CONTACT: AARON LUCK #215-510-8928 EMAIL: AARON.LUCK@SHAWCONTRACT.COM	
-	TARKETT - JOHNSONITE PRODUCTS	SPARTAN SURFACES CONTACT: KEITH KNECHT #215-272-7085 EMAIL: KKNKNECHT@SPARTANSURFACES.COM	

ADDITIONS AND RENOVATIONS FOR

CHURCH OF THE HOLY SPIRIT

2871 BARNDT ROAD, HARLEYSVILLE, PA, 19438

REVISIONS

4-12-2021 BID SET

DRAWN BY

REVIEWED BY

JOB #

SHEET TITLE

INTERIOR FINISH PLAN & SCHEDULE

SHEET #

A7.1

SCALE

DATE

AS NOTED

4-12-2021




BID SET - APRIL 12, 2021


STAMP

CONSULTANTS

GODSHALL KANE O'ROURKE ARCHITECTS, LLC
300 Brookside Avenue
Suite 100
Annapolis, MD 21403
T: 215.646.2003 F: 215.646.5707 W: gkarchitects.com

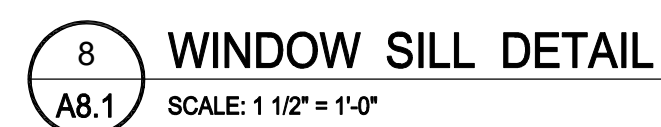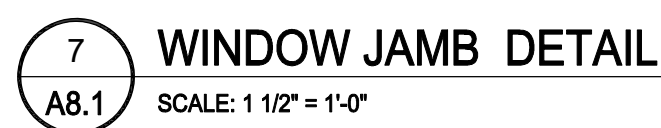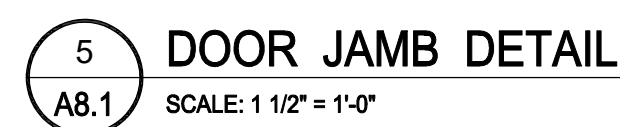

4-12-2021

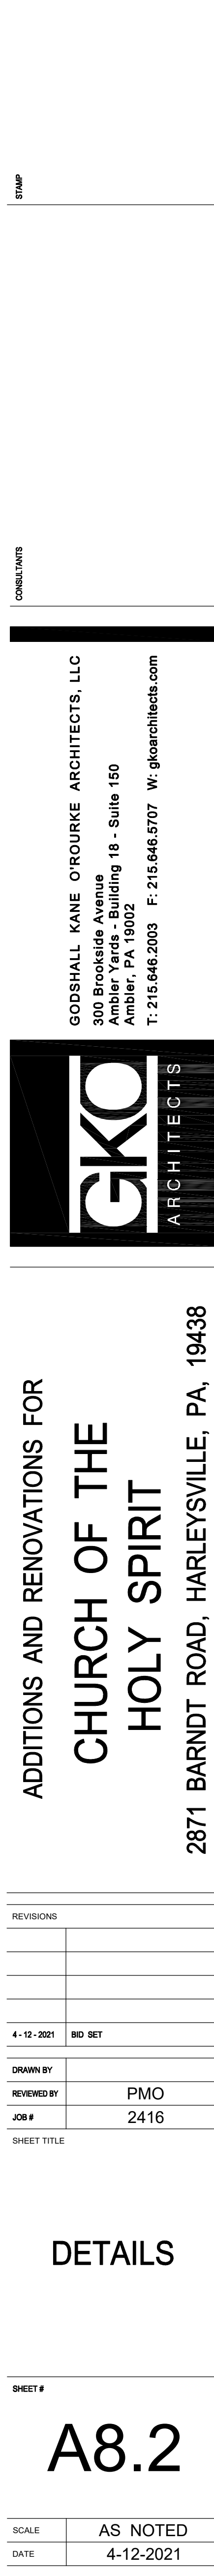



1 SCHEMATIC RENDERING - BIRD'S EYE VIEW
A9.1



2 SCHEMATIC RENDERING - EXTERIOR VIEW OF ADDITION
A9.1

NOTE: SCHEMATIC RENDERINGS FOR REFERENCE ONLY (DESIGN MAY VARY FROM DRAWINGS)



3 SCHEMATIC RENDERING - VIEW FROM PARKING LOT
A9.1



4 SCHEMATIC RENDERING - EXTERIOR VIEW OF ADDITION
A9.1



4 SCHEMATIC RENDERING - EXTERIOR VIEW OF ADDITION
A9.1

BID SET - APRIL 12, 2021

REVISIONS	
4-12-2021	BID SET
DRAWN BY	
REVIEWED BY	PMO
JOB #	2416
SHEET TITLE	
	SCHEMATIC RENDERINGS
SHEET #	
	A9.1
SCALE	AS NOTED
DATE	4-12-2021

ADDITIONS AND RENOVATIONS FOR
CHURCH OF THE
HOLY SPIRIT
2871 BARNDT ROAD, HARLEYSVILLE, PA, 19438



GODSHALL KANE O'ROURKE ARCHITECTS, LLC
300 Brookside Avenue
Suite 150
Ambler, PA 19002
T: 215.646.2003 F: 215.646.5707 W: gkoarchitects.com

CONSULTANTS
STAMP