


KEYED NOTES

- 1 TV OUTLETS @ 9'-6" A.F.F.
- 2 TV COAXIAL
- 3 NOT USED.
- 4 TELEPHONE CATS
- 5 ALL CATS, COAXIAL & LOW VOLT WIRING IN EXPOSED CEILING TO BE IN CONDUIT
- 6 TV DEMARK LOCATED IN THE UTILITY ROOM. VERIFY PRIOR TO ROUGH-IN.
- 7 TELEPHONE & INTERNET DEMARK LOCATED IN THE UTILITY ROOM. VERIFY PRIOR TO ROUGH-IN.
- 8 DESK DATA POINT - REFER TO 4/LOW2 VERIFY EXACT LOCATION PRIOR TO ROUGH-IN.
- 9 NOT USED.
- 10 WIREMOLD OUTLETS W/ 20 AMP DEDICATED CIRCUITS WITH COAXIAL & DATA CONNECTIONS W/ HOME RUNS TO TV DEMARK AND DATA DEMARK.
- 11 TV COAXIAL - TYPICALLY ONE CABLE PER TV/VIEW SCREEN
- 12 NERVE CENTER - REFER TO 5/LOW2
- 13 NO USED.
- 14 EMERGENCY PHONE LOCATION - 48" MAXIMUM TO OPERABLE PART
- 15 ABOVE DOOR/ CEILING FOR SECURITY SYSTEM - LABEL CIRCUIT IN PANEL "DOOR SECURITY"
- 16 NOT USED.
- 17 NOT USED.
- 18 GENERAL OUTLETS @ 1'-6" A.F.F.
- 19 VERIFY EXACT LOCATION OF CARDIO EQUIPMENT WITH OWNER AND EQUIPMENT MANUFACTURER PRIOR TO ROUGH-IN.

PLAN SYMBOLS

- | | |
|---|--|
|  | TELEVISION |
|  | DUPLEX RECEPTACLE, 3 WIRE GRD. TYPE - MOUNT 18" TO CENTER UNLESS NOTED OTHERWISE |
|  | QUADRAPLEX RECEPTACLE - MOUNT 18" TO CENTER UNLESS NOTED OTHERWISE |
|  | CABLE TV SIGNAL CONNECTION VIA COAXIAL CABLE |
|  | DATA RJ45 CONNECTOR FOR CONNECTION TO ETHERNET VIA CATS CABLE |
|  | 1 PHONE JACK |

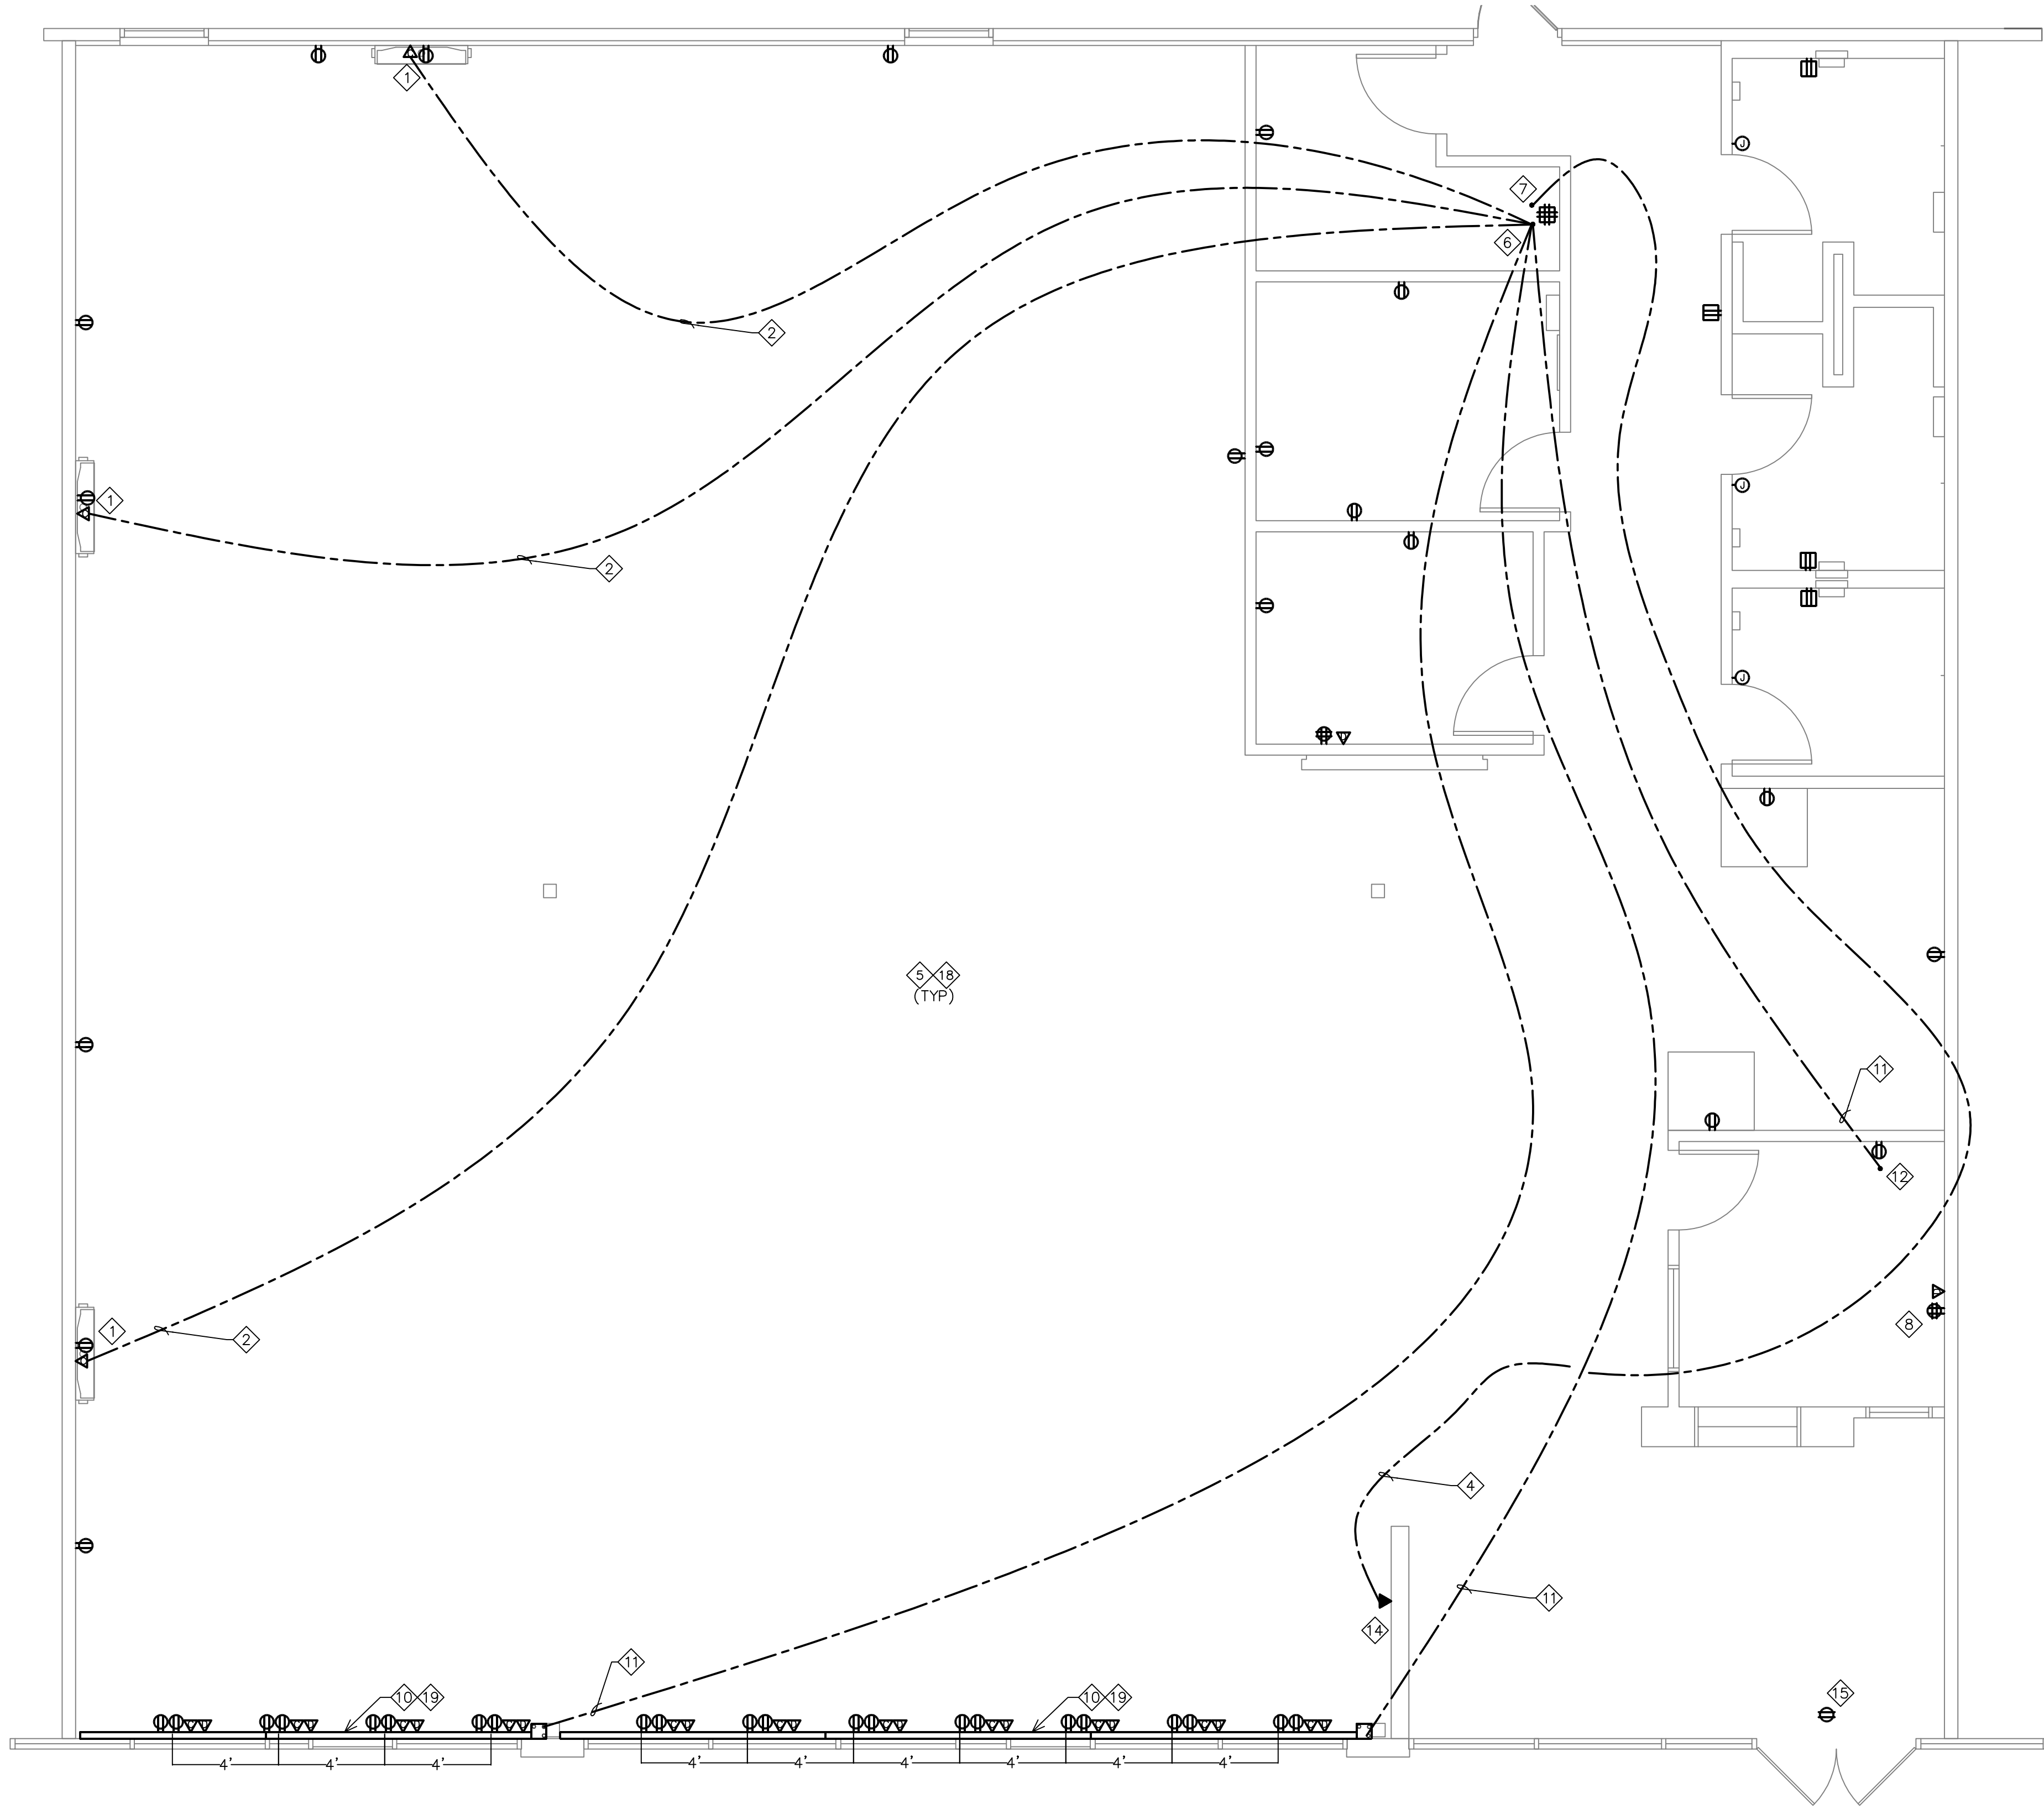

1 LOW VOLTAGE PLAN
1/4" = 1'-0"

CONSULTANT:



DUNHAM

Dunham Associates, Inc.

50 South Sixth Street / Suite 1100
Minneapolis, Minnesota 55402-1540

PHONE 612.465.7550

FAX 612.465.7551

WEB dunhameng.com

**mechanical + electrical
consulting engineering**

COA # CA 2352 PE EXPIRATION - 6/30/16

CLIENT:



ANYTIME FITNESS, LLC
12181 MARGO AVE SOUTH
HASTINGS, MN 55033
PHONE: (651) 438-5000

PROJECT INFORMATION:

**ANYTIME
FITNESS**
CROSS CREEK CENTER
3601 W MAIN ST, SUITE 145
DURANT, OK 74701

SEAL:



PROJECT NO.: 0416740-037

DRAWN BY: VB/CM

CHECKED BY: RM

ISSUE:

DATE:

PERMIT SET

03-09-16

REVISION:

DATE:

PROJECT LOCATION:

DURANT, OK

SHEET NUMBER / TITLE:

LOW1