

FIRST FLOOR PLAN

DOOR SCHEDULE			
QTY	R/L	SIZE	TYPE
1	R	2'0"x6'8"	INT HC
6	L	2'0"x6'8"	INT HC
3	R	2'8"x6'8"	INT HC
1	L	2'8"x6'8"	INT HC
3	R	2'0"x8'0"	INT HC
4	L	2'0"x8'0"	INT HC
2	L	2-2'0"x8'0"	DBL INT HC
1	R	2'4"x8'0"	INT HC
2	L	2'8"x8'0"	INT HC
1	R	2'8"x8'0"	INT SC
1	R	2'8"x8'0"	EXT SC FR
1	L	2'8"x8'0"	EXT SC FR
1	L	3'0"x8'0"	EXT SC SPECIAL
1	L	1'6"x7"	MTL SECT OVERHEAD

WINDOW SCHEDULE		
QTY	SIZE	TYPE
2	1'0"x7'0"	FIX DL
1	2'0"x3'0"	FIX
3	2'0"x3'0"	FIX DL
2	2'0"x6'0"	SH
1	2'0"x7'0"	SH DL
2	3'0"x5'0"	SH
3	3'0"x5'0"	SH DL
1	3'0"x6'0"	SH DL
3	3'0"x7'0"	SH
2	2-3'0"x6'0"	SH MULL
1	2-3'0"x7'0"	SH DL MULL
3	4'0"x4'0"	SH
1	4'0"x5'0"	FIX OBS TEMP
3	4'0"x8'0"	FIX

AREA	SQ.FT.
FIRST FLOOR	1865
SECOND FLOOR	1079
TOTAL A/C	2944
PORCH	303
PATIO	153
GARAGE	483
BONUS ROOM	272
TOTAL A.U.R.	4155
WIDTH	67'-2.5"
DEPTH	56'-6"

Homestead Designs

Plano, TEXAS
214-215-1013
e-mail: homestead.designs@verizon.net

REVISION DATE
04-14-2014 BLP
RODRIGUEZ
CUSTOM

PROJECT
ADDRESS:
110 FALLS
CREEK

PLAN NUMBER
2944

DESIGNED AND
DRAWN BY:
HOMESTEAD
DESIGNS
B.L.PHILLIPS
FOUNDER-
DESIGNER
214-215-1013

SCALE:
1/8"=1'-0" (11x17) SHEET
1/4"=1'-0" (22x34) SHEET

PAGE # 1


Plano, TEXAS
214-215-1013
e-mail: homestead.designs@verizon.net

PROJECT
ADDRESS:
110 FALLS
CREEK

DESIGNED AND
DRAWN BY:
HOMESTEAD
DESIGNS
B.L.PHILLIPS
FOUNDER-
DESIGNER
214-215-1013

PAGE # 2



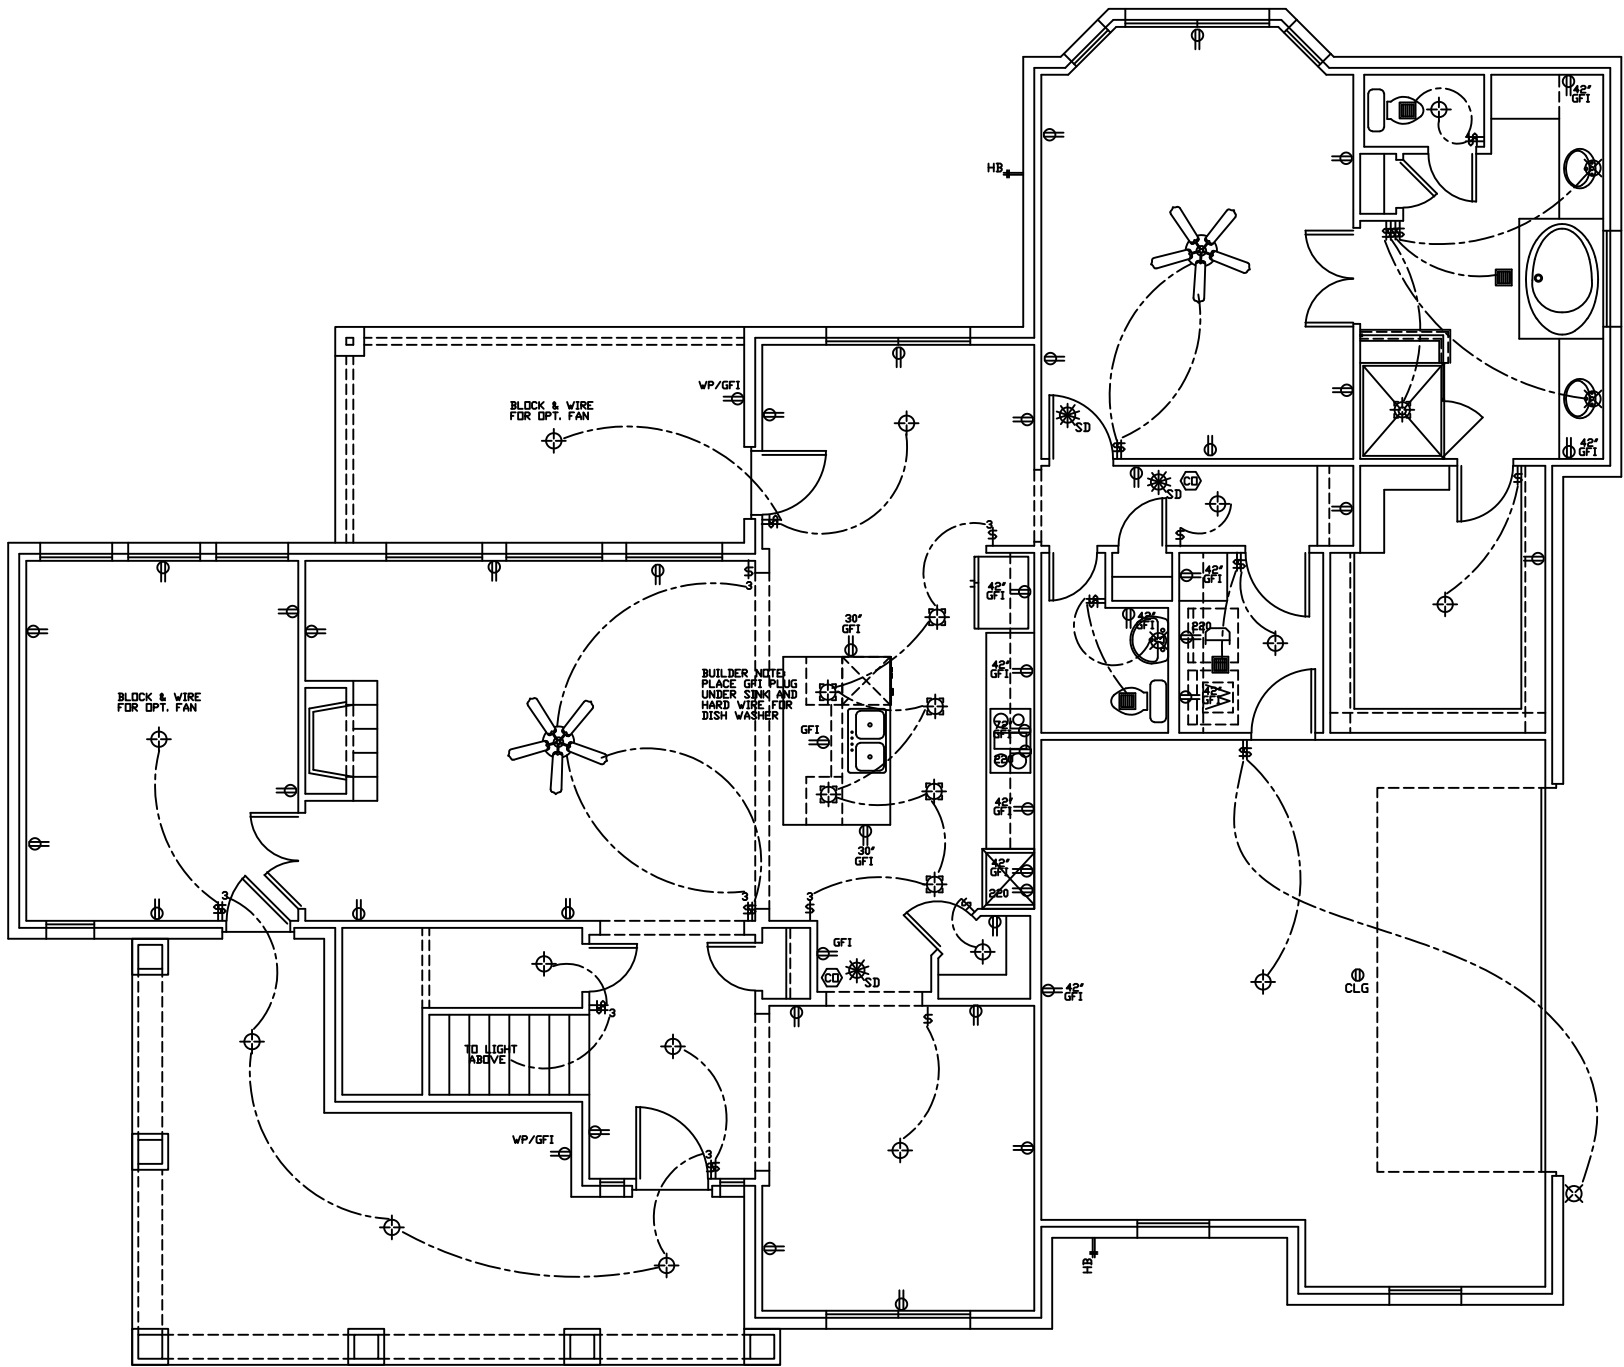

FIRST FLOOR ELECTRICAL PLAN

ELECTRICAL LEGEND

HOSE BIBB
SWITCH
THREE-WAY SWITCH
FOUR-WAY SWITCH
THERMOSTAT
DUPLEX
COUNTERTOP DUPLEX
SPLIT WIRED DUPLEX
QUAD DUPLEX

CEILING DUPLEX
FLOOR DUPLEX
PHONE OUTLET
TV OUTLET
GAS OUTLET
CARBON MONOXIDE DETECTOR
SMOKE DETECTOR
JUNCTION
220 VOLT OUTLET
LANDSCAPING LIGHT
FLOODLIGHT

CEILING LIGHT
RECESSED CEILING LIGHT
WALL HANG LIGHT
WALL HANG FAN
RECESSED EYE BALL LIGHT
VENT
VENT AND LIGHT
HEAT AND LIGHT
HEAT, VENT AND LIGHT

Homestead Designs

Plano, TEXAS
214-215-1013
e-mail: homestead.designs@verizon.net

REVISION DATE
04-14-2014 BLP
RODRIGUEZ
CUSTOM


PROJECT
ADDRESS:
110 FALLS
CREEEK

PLAN NUMBER
2944

DESIGNED AND
DRAWN BY:
HOMESTEAD
DESIGNS
B.L.PHILLIPS
FOUNDER-
DESIGNER
214-215-1013

SCALE:
1/8"=1'-0" (11x17) SHEET
1/4"=1'-0" (22x34) SHEET

PAGE # 3

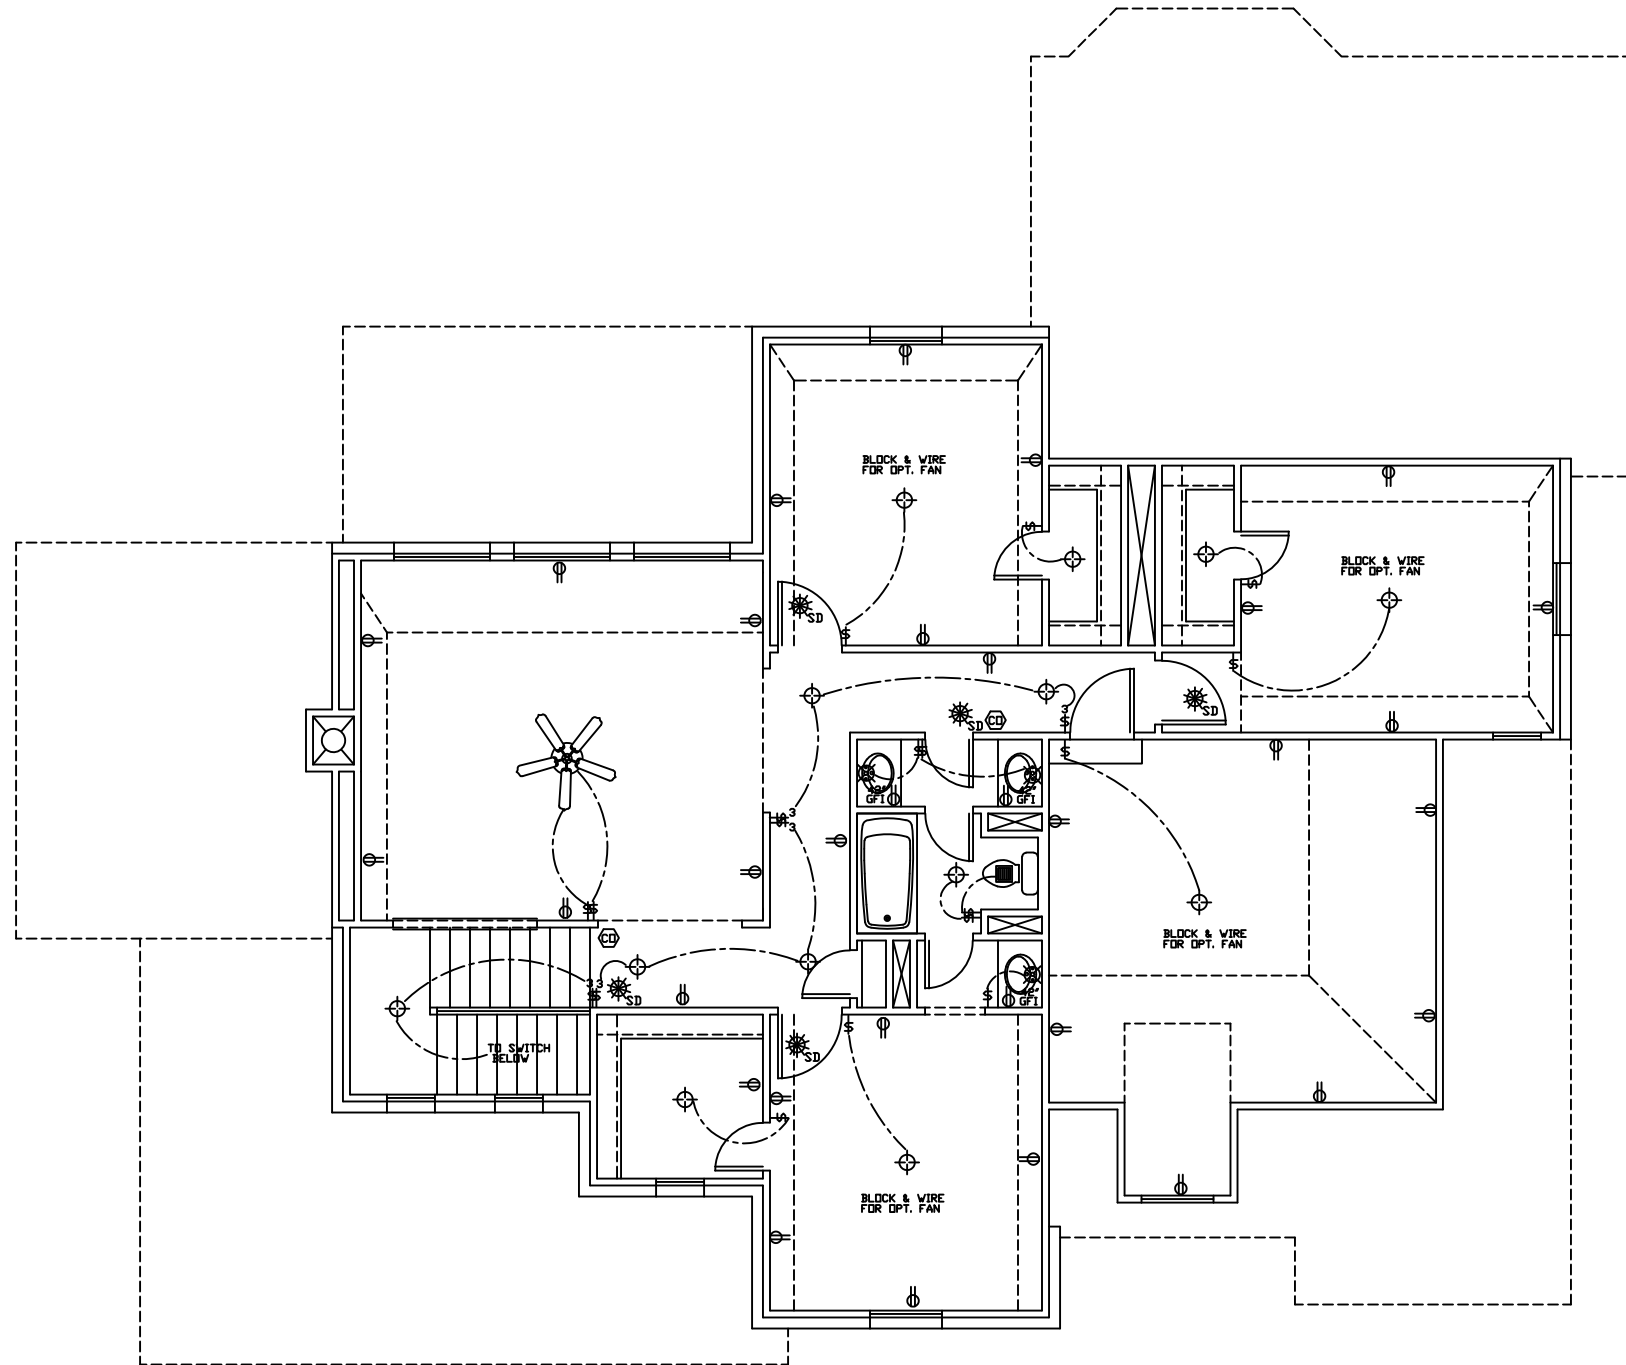

SECOND FLOOR ELECTRICAL PLAN

ELECTRICAL LEGEND	
HOSE BIB	CEILING LIGHT
SWITCH	RECESSED CEILING LIGHT
THREE-WAY SWITCH	WALL HUNG LIGHT
FOUR-WAY SWITCH	WALL HUNG FAN
RHEOSTAT	RECESSED EYEBALL LIGHT
DUPLEX	VENT
COUNTERTOP DUPLEX	VENT AND LIGHT
SPLIT WIRED DUPLEX	HEAT AND LIGHT
QUAD DUPLEX	HEAT, VENT AND LIGHT

CEILING DUPLEX	SMOKE DETECTOR
FLOOR DUPLEX	CARBON MONOXIDE DETECTOR
PHONE OUTLET	JUNCTION
TV OUTLET	220 VOLT OUTLET
GAS OUTLET	LANDSCAPING LIGHT
SMOKE DETECTOR	FLOODLIGHT

Homestead Designs

Plano, TEXAS
214-215-1013
e-mail: homestead.designs@verizon.net

REVISION DATE
04-14-2014 BLP
RODRIGUEZ
CUSTOM

PROJECT
ADDRESS:
110 FALLS
CREEK

PLAN NUMBER
2944

DESIGNED AND
DRAWN BY:
HOMESTEAD
DESIGNS
B.L.PHILLIPS
FOUNDER-
DESIGNER
214-215-1013

SCALE:
1/8"=1'-0" (11x17) SHEET
1/4"=1'-0" (22x34) SHEET



Homestead Designs

**Plano, TEXAS
214-215-1013**

214-215-1013

e-mail: homestead.designs@verizon.net

REVISION DATE
04-14-2014 BLP
RODRIGUEZ
CUSTOM


PROJECT
ADDRESS:
110 FALLS
CREEK

PLAN NUMBER
2944


DESIGNED AND
DRAWN BY:
HOMESTEAD
DESIGNS
B.L.PHILLIPS
FOUNDER-
DESIGNER
214-215-1013

SCALE:
 $1/8" = 1' - 0"$ (11x17) SHEET
 $1/4" = 1' - 0"$ (22x34) SHEET

PAGE # 5

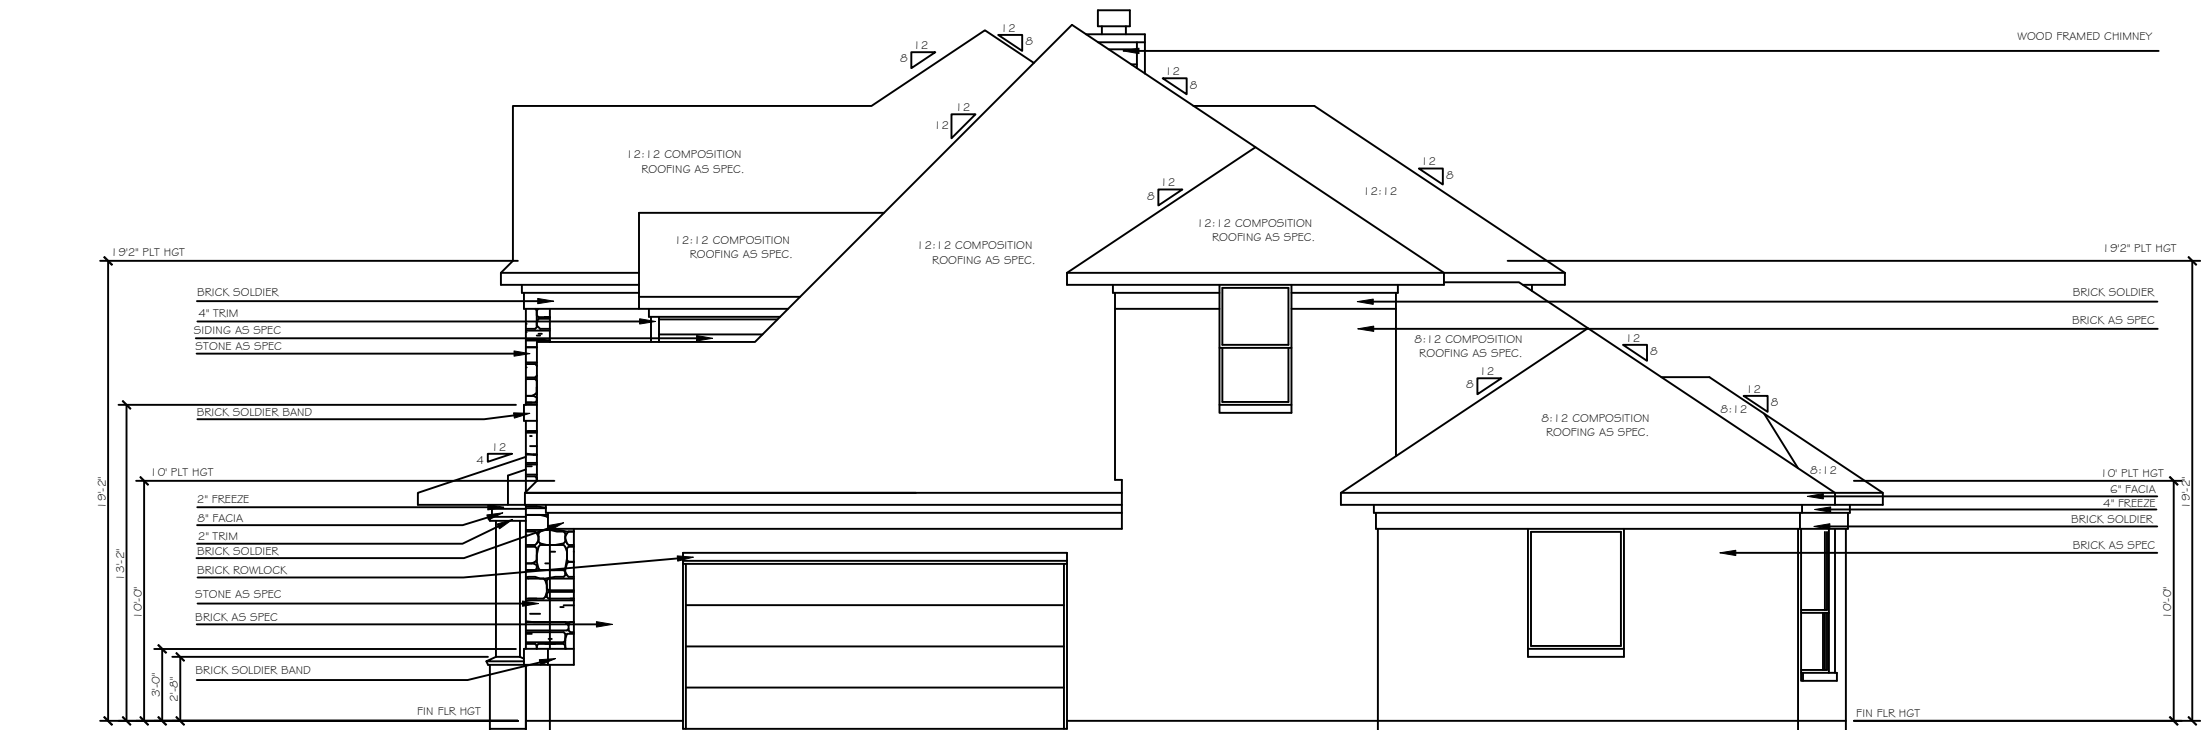

RIGHT SIDE ELEVATION

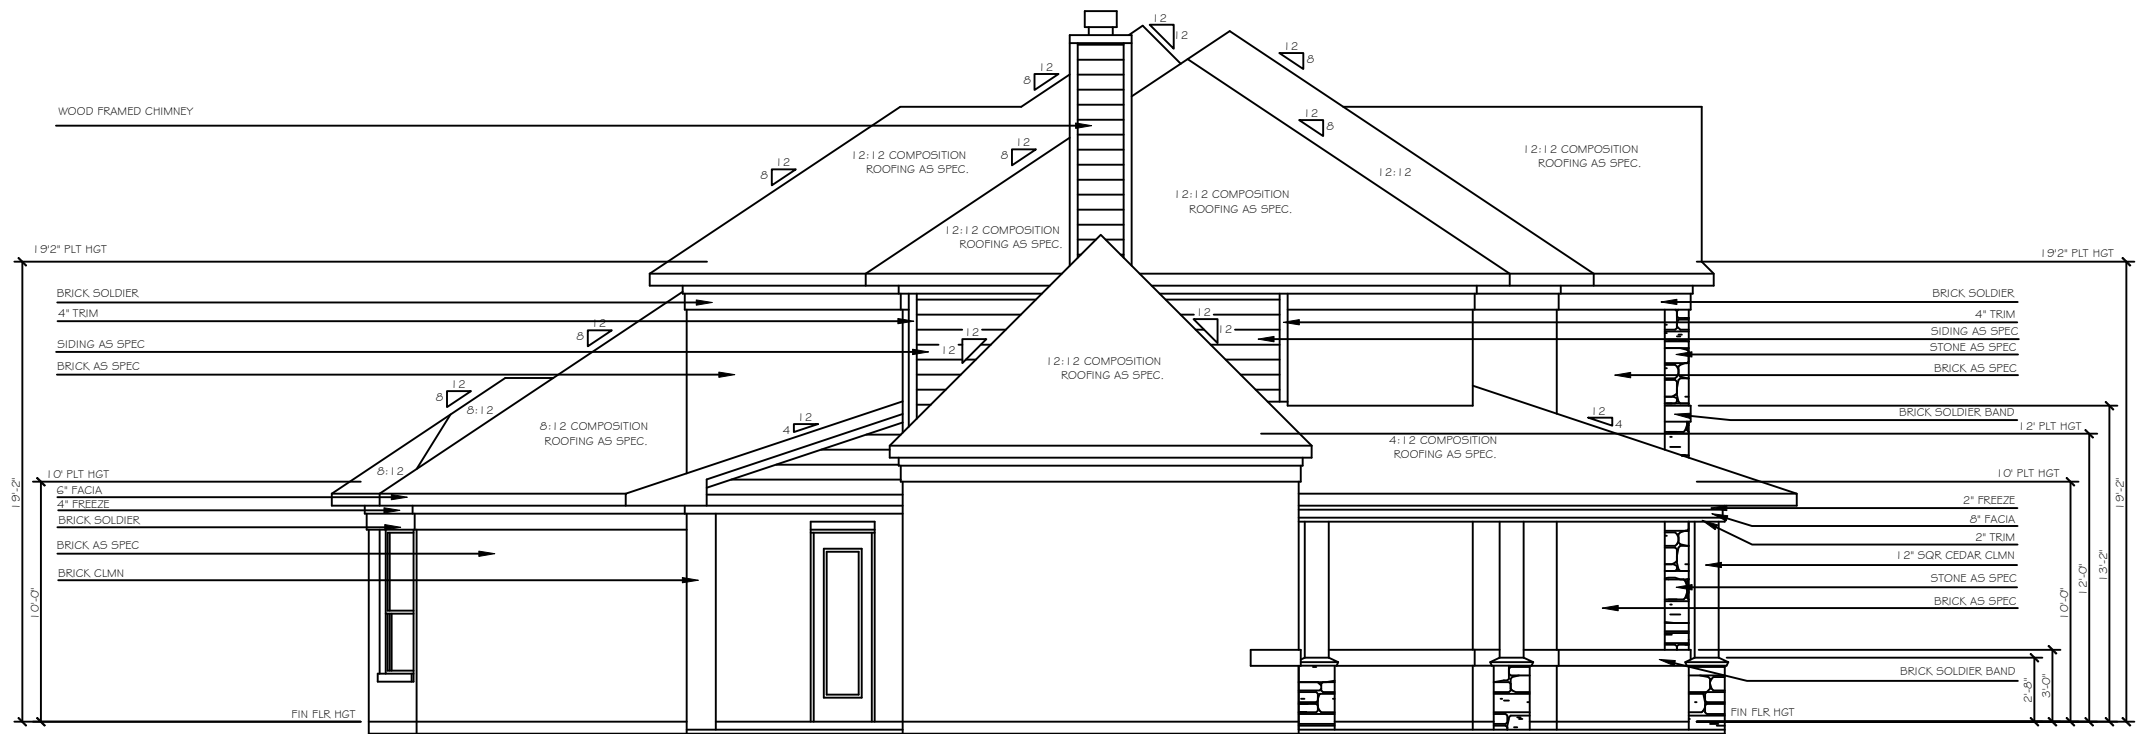

LEFT SIDE ELEVATION

Homestead Designs

Plano, TEXAS

214-215-1013

e-mail: homestead.designs@verizon.net

REVISION DATE
04-14-2014 BLP
RODRIGUEZ
CUSTOM


PROJECT
ADDRESS:
110 FALLS
CREEK

PLAN NUMBER
2944

DESIGNED AND
DRAWN BY:
HOMESTEAD
DESIGNS
B.L.PHILLIPS
FOUNDER-
DESIGNER
214-215-1013

SCALE:
1/8"=1'-0" (11x17) SHEET
1/4"=1'-0" (22x34) SHEET

PAGE # 6

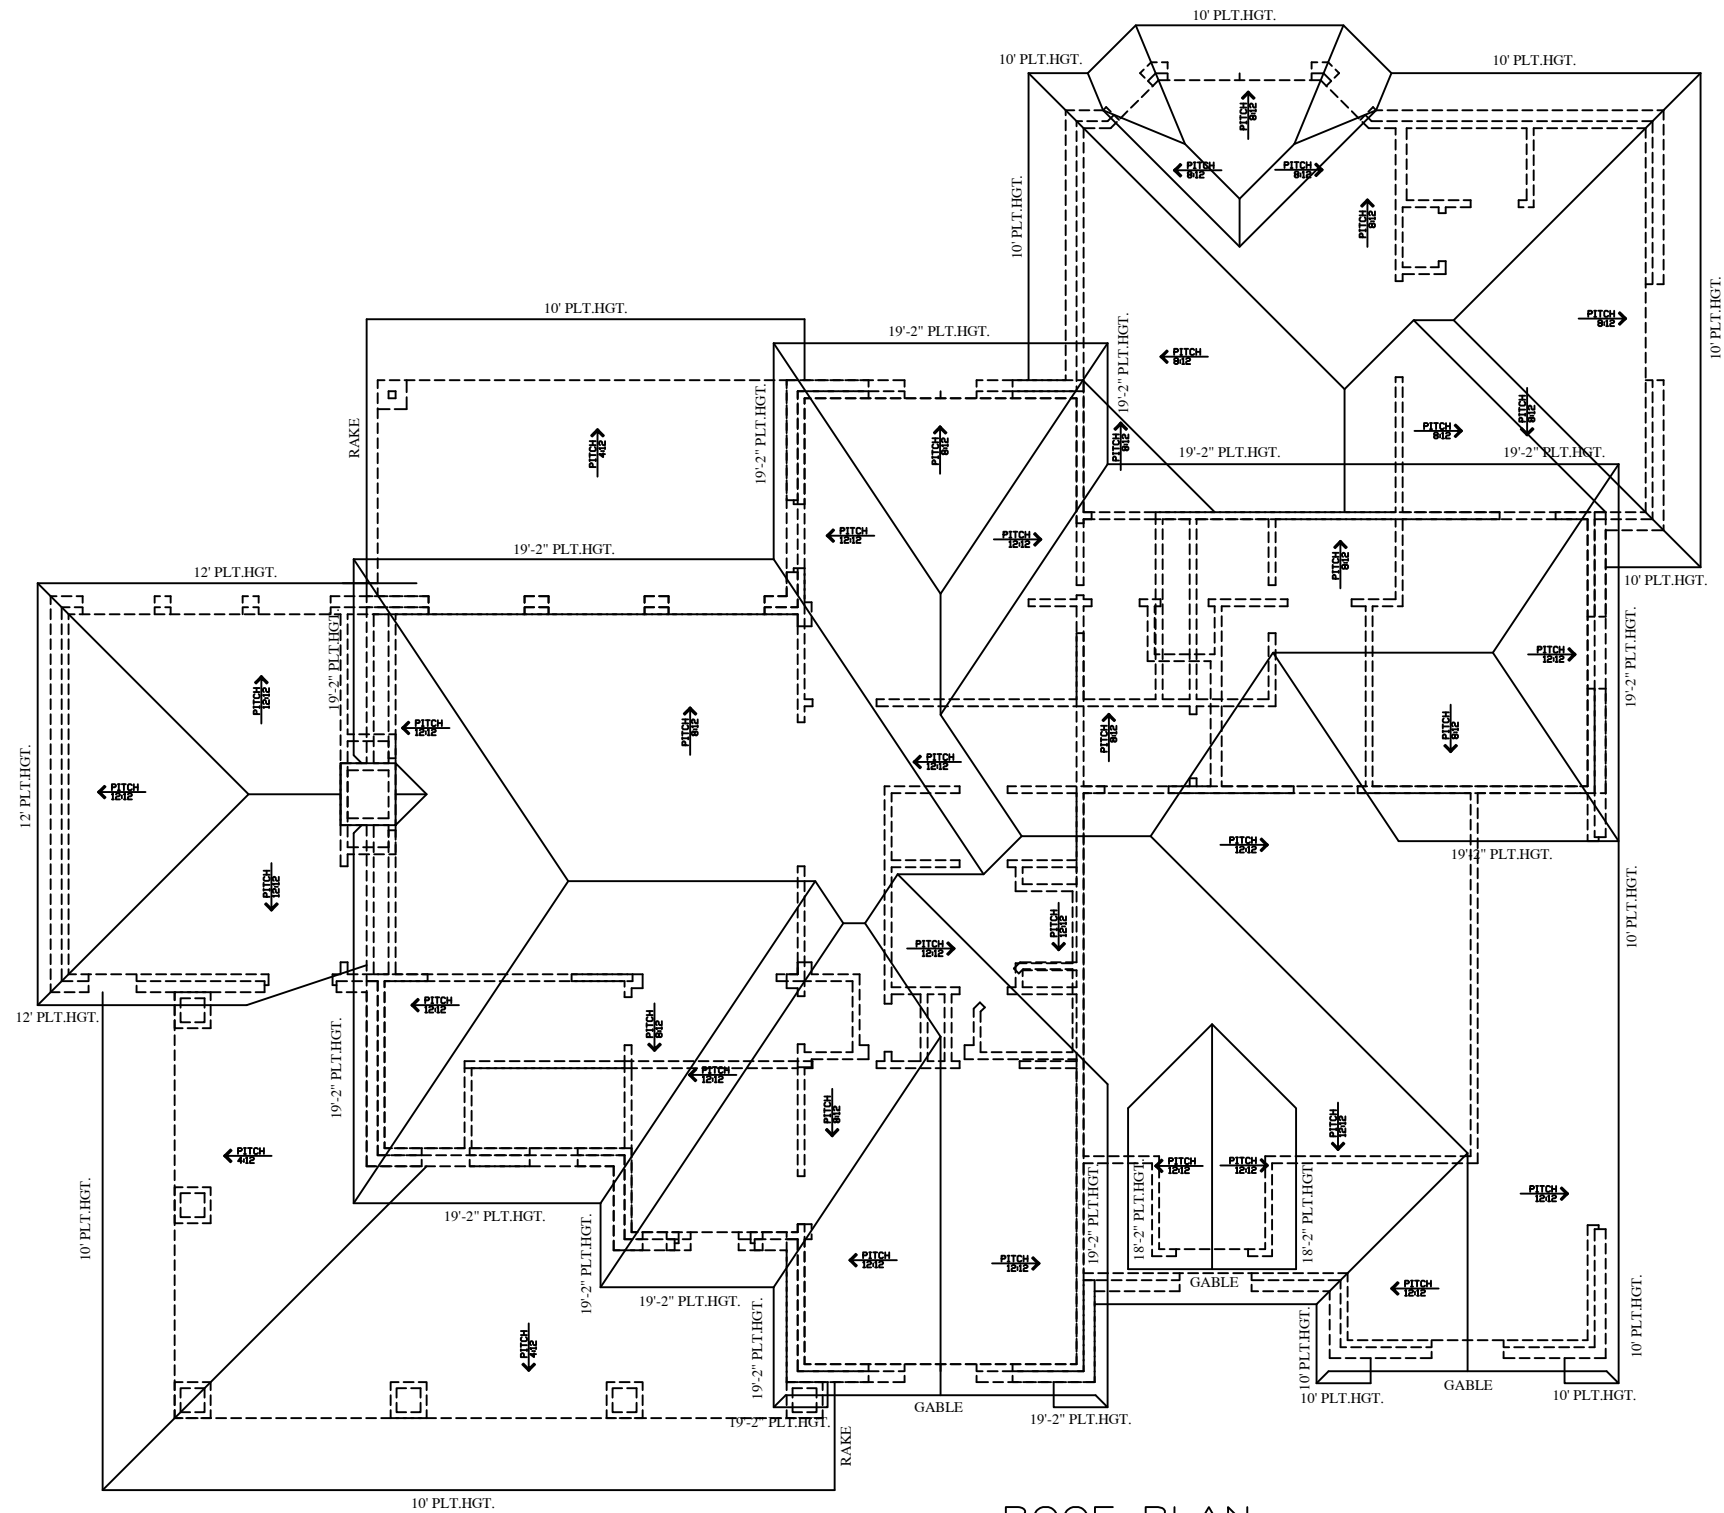

ROOF PLAN

Homestead Designs

Plano, TEXAS
214-215-1013
e-mail: homestead.designs@verizon.net

REVISION DATE
04-14-2014 BLP
RODRIGUEZ
CUSTOM

PROJECT
ADDRESS:
110 FALLS
CREEEK

PLAN NUMBER
2944

DESIGNED AND
DRAWN BY:
HOMESTEAD
DESIGNS
B.L.PHILLIPS
FOUNDER-
DESIGNER
214-215-1013

SCALE:
1/8"=1'-0" (11x17) SHEET
1/4"=1'-0" (22x34) SHEET