
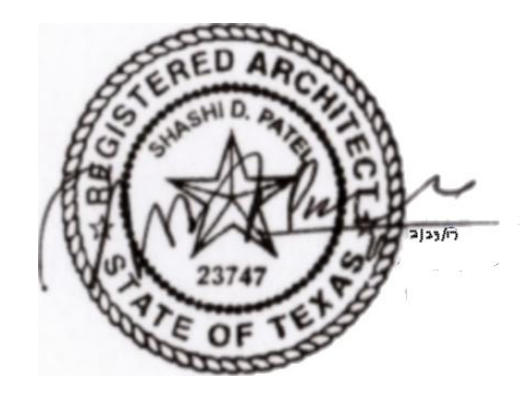
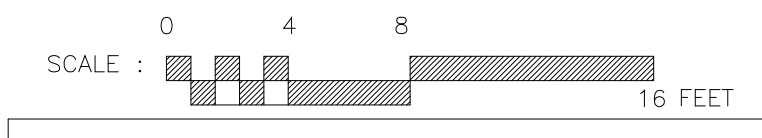


- RCP LEGEND:**
- 2x2 SUSPENDED ACOUSTICAL CEILING
  - GYPSUM BOARD CEILING
  - ALUMINUM SOFFIT DESIGN BASIS: ATAS LINEAR CEILING LCR-3"
  - 2x2 LED LIGHT FIXTURE RE. ELECT.
  - 2x4 LED LIGHT FIXTURE RE. ELECT.
  - 1x4 FLUORESCENT LIGHT FIXTURE
  - SUSPENDED LINEAR LIGHT FIXTURE
  - RECESSED LIGHT FIXTURE
  - 2x2 SUPPLY AIR DIFFUSER. REFER TO MECHANICAL DRAWINGS.
  - 2x2 AIR RETURN GRILL. REFER TO MECHANICAL DRAWINGS.

THIS DRAWING IS INTENDED TO ALIGN AND LOCATE FIXTURES IN A SYMMETRICAL PATTERN. RE. MEP DRAWINGS FOR QUANTITIES AND DETAILS. SPRINKLER HEADS TO BE CENTERED IN TILES- NO EXCEPTIONS

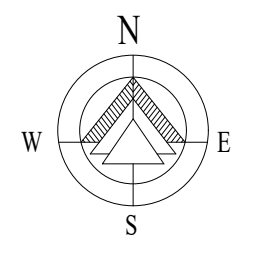

rev	
rev	2: 02-23-2017
rev	1: 01-18-2017 rev. fixture layout
date	10-05-2015 released for const.
scale	AS NOTED
drawn by	CADD-NV

SHASHI D. PATEL AIA NCARB  
ARCHITECTS AND PLANNERS  
442 EAST END AVE. STE-B. PITTSBURGH PA 15221

REFLECTED CEILING PLAN FIRST FLOOR  
CONSTRUCTION DOCUMENT PHASE

RADHA KRISHNA TEMPLE  
ALLEN TEXAS

dwg. no. 07162013 A-8

**1 REFLECTED CEILING PLAN FIRST FLOOR**  
SCALE: 1/8" = 1'-0"

COPYRIGHT © 2015 BY SHASHI D. PATEL AIA. ALL RIGHTS RESERVED. REPRODUCTION IN PART OR WHOLE IS PROHIBITED WITHOUT A WRITTEN CONSENT FROM SHASHI D. PATEL AIA NCARB