

M. En. P. Engineers
 Reg.#12249
 124 N. Spring Dr. ,
 Richardson, TX 75081
 972-697-3057
 KChishti@aol.com



Project

RADHA KRISHNA TEMPLE
 1450 N. WATERS ROAD
 ALLEN, TX 75013

ISSUE	DATE	DESCRIPTION

PROJECT NUMBER CM170123

SCALE

DRAWN TCG


DATE 06/05/2020

SHEET DESCRIPTION

PLUMBING RISERS


SHEET NUMBER

P3.0

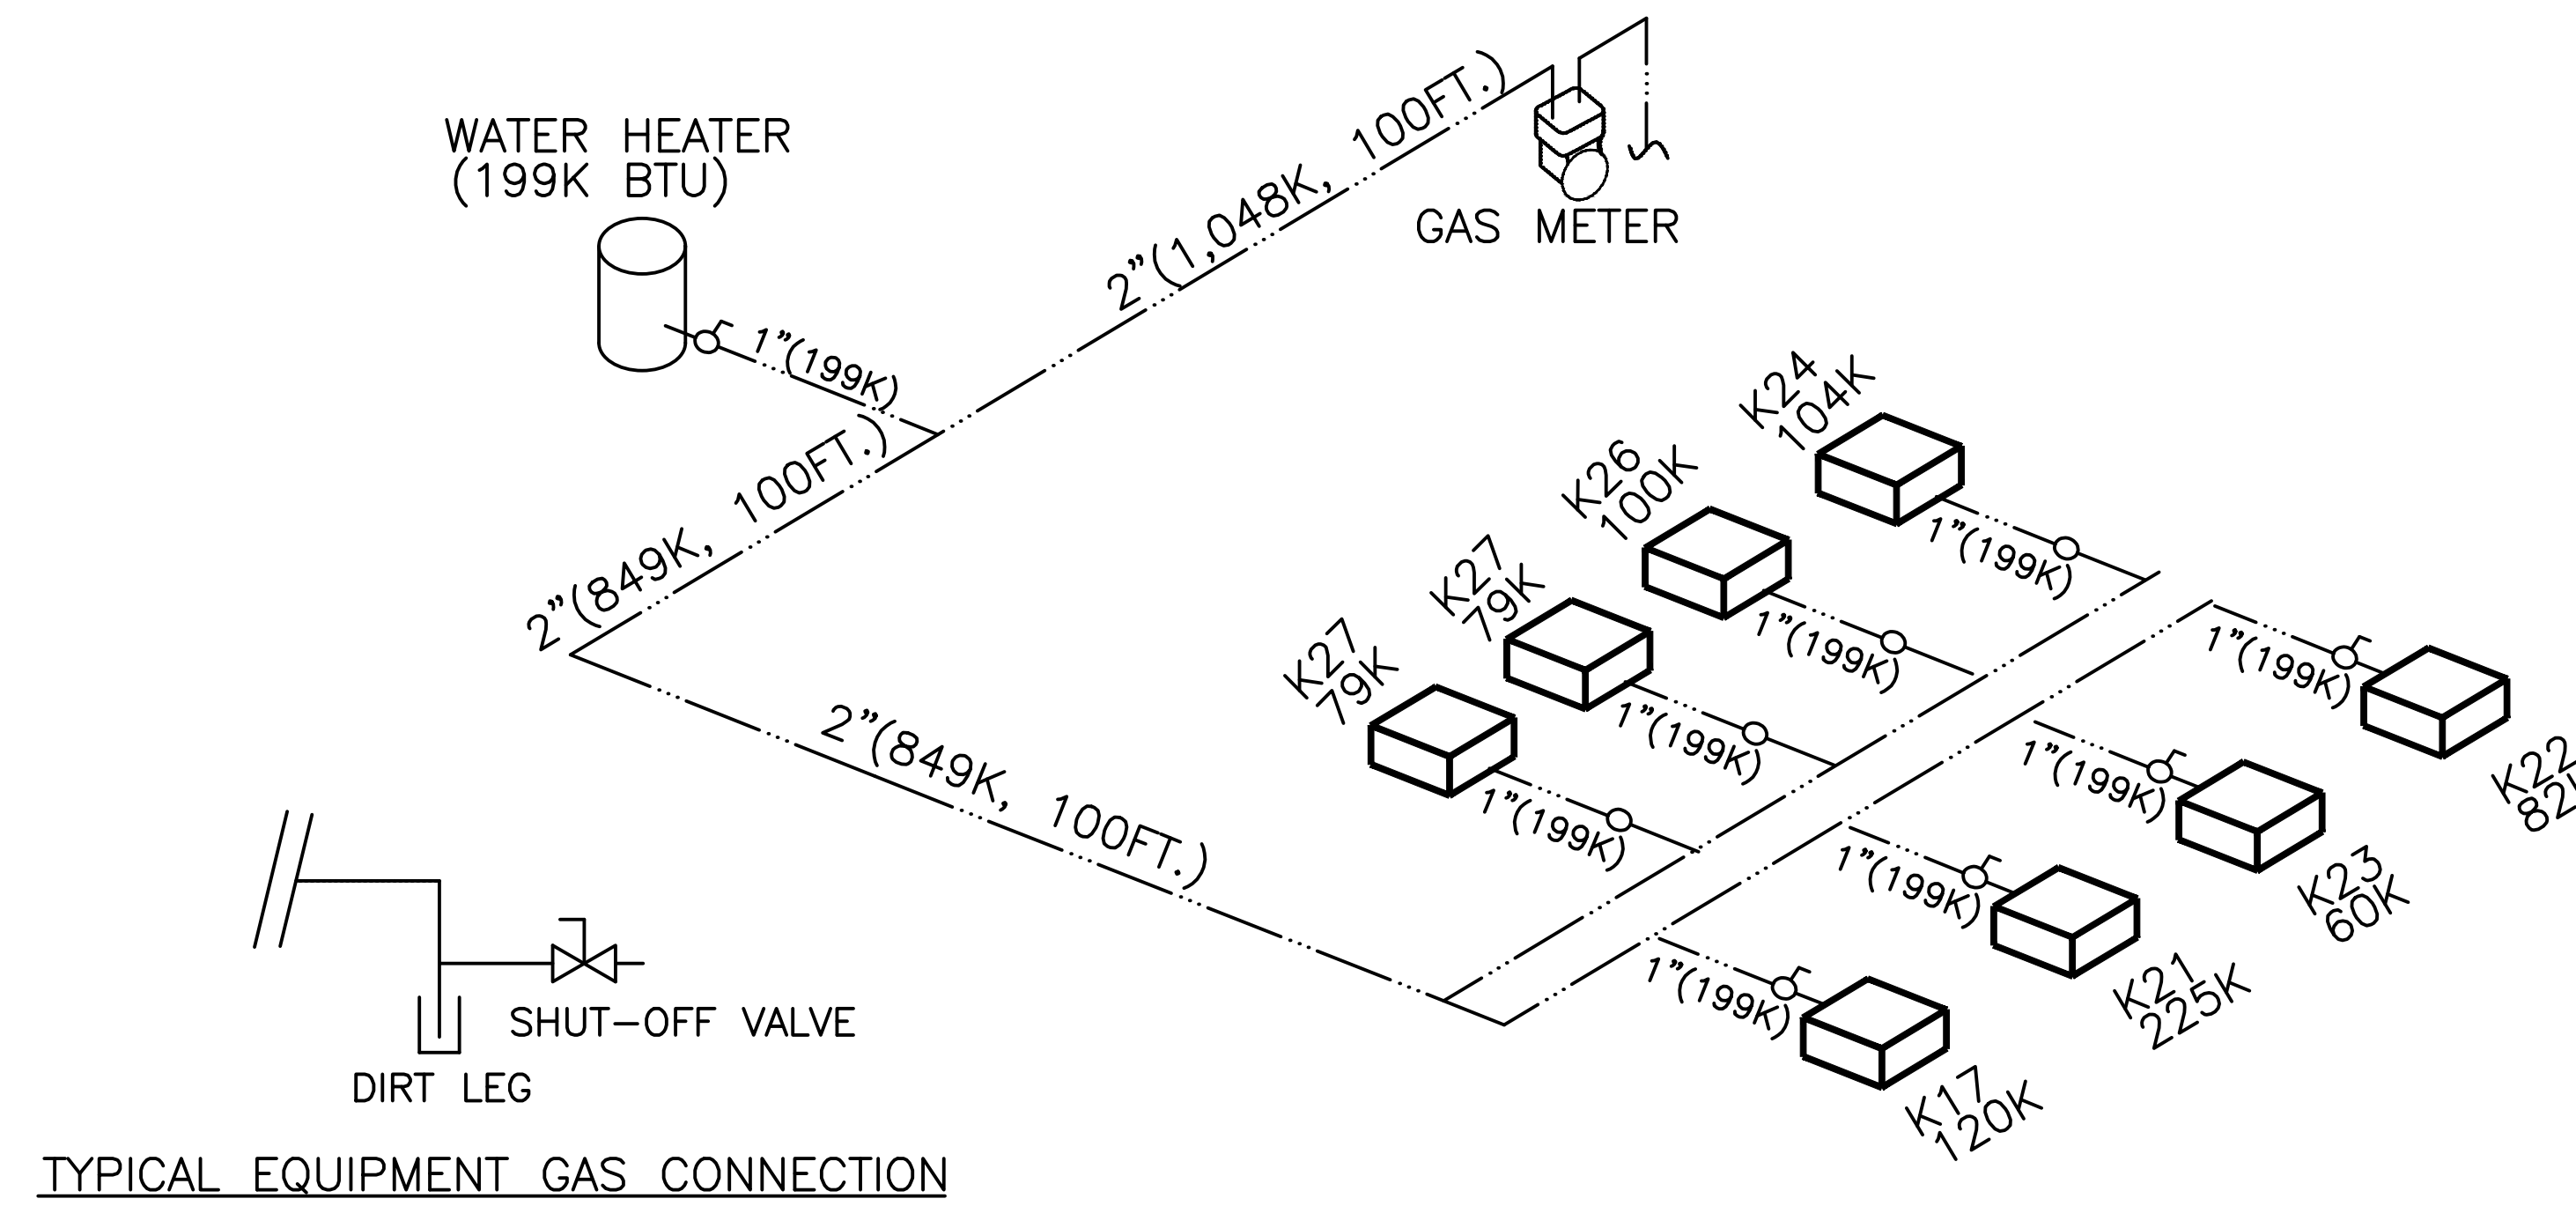

01-GAS RISER

SCALE: NONE

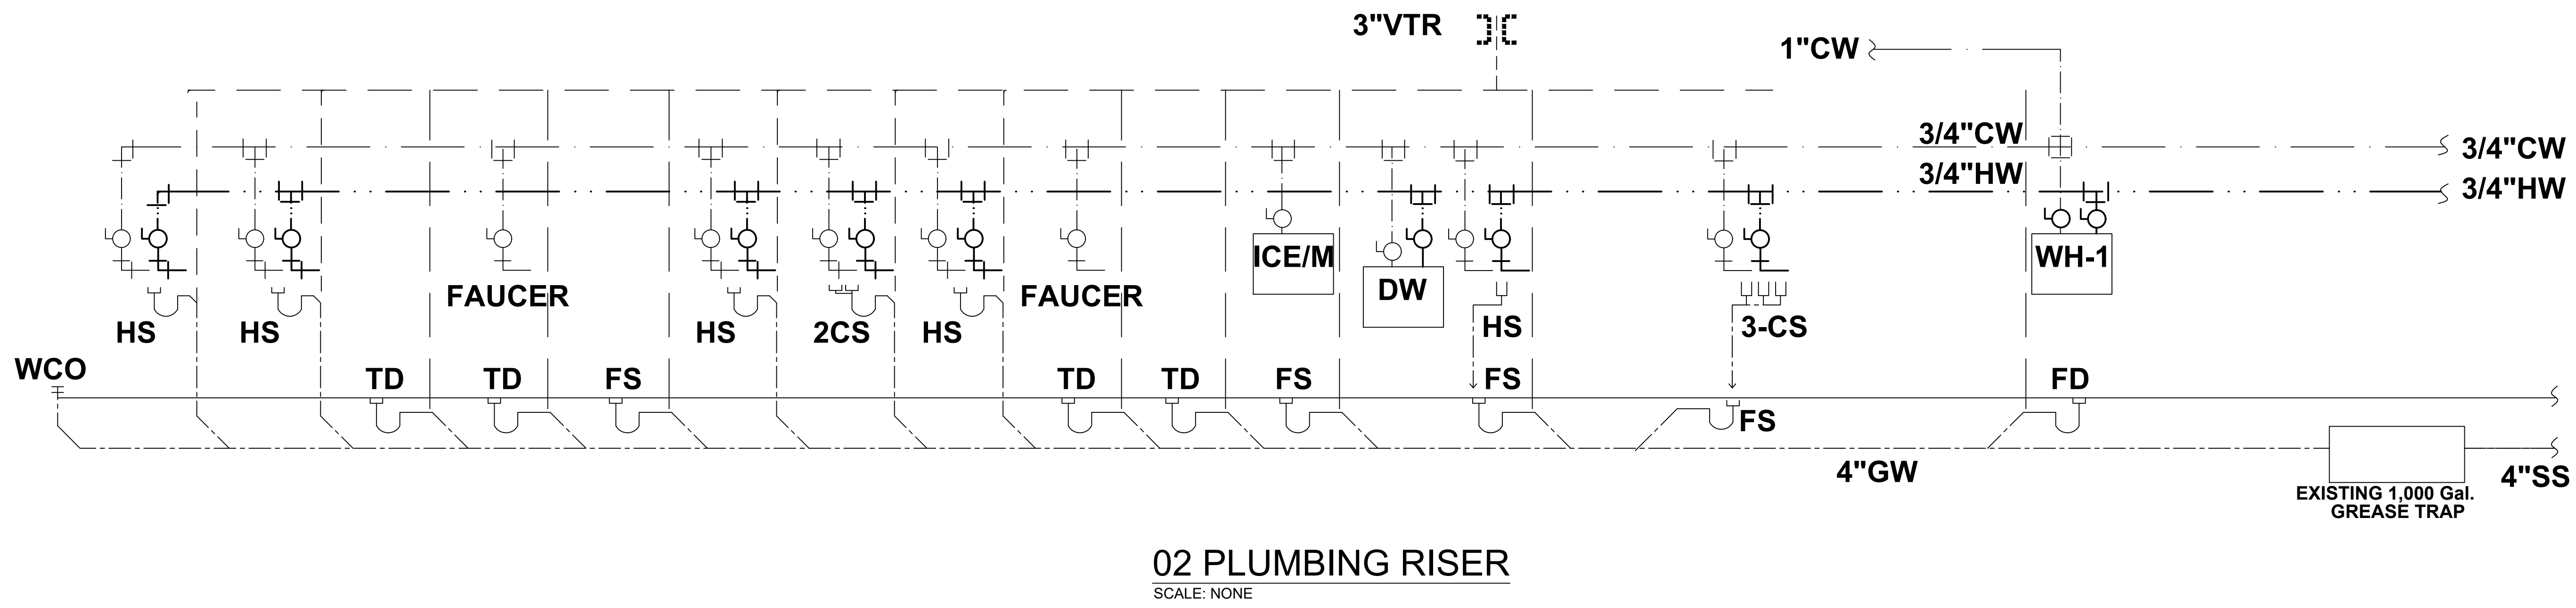

02 PLUMBING RISER

SCALE: NONE