
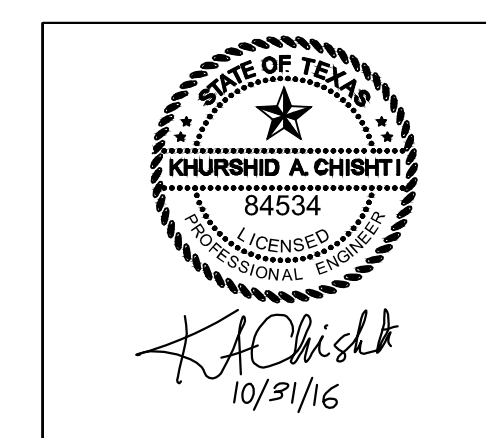
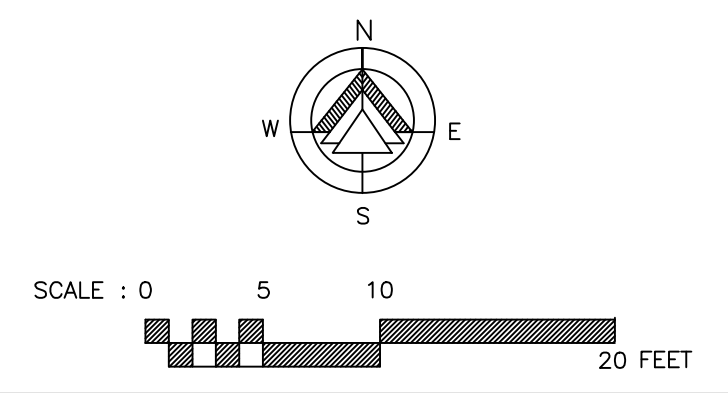
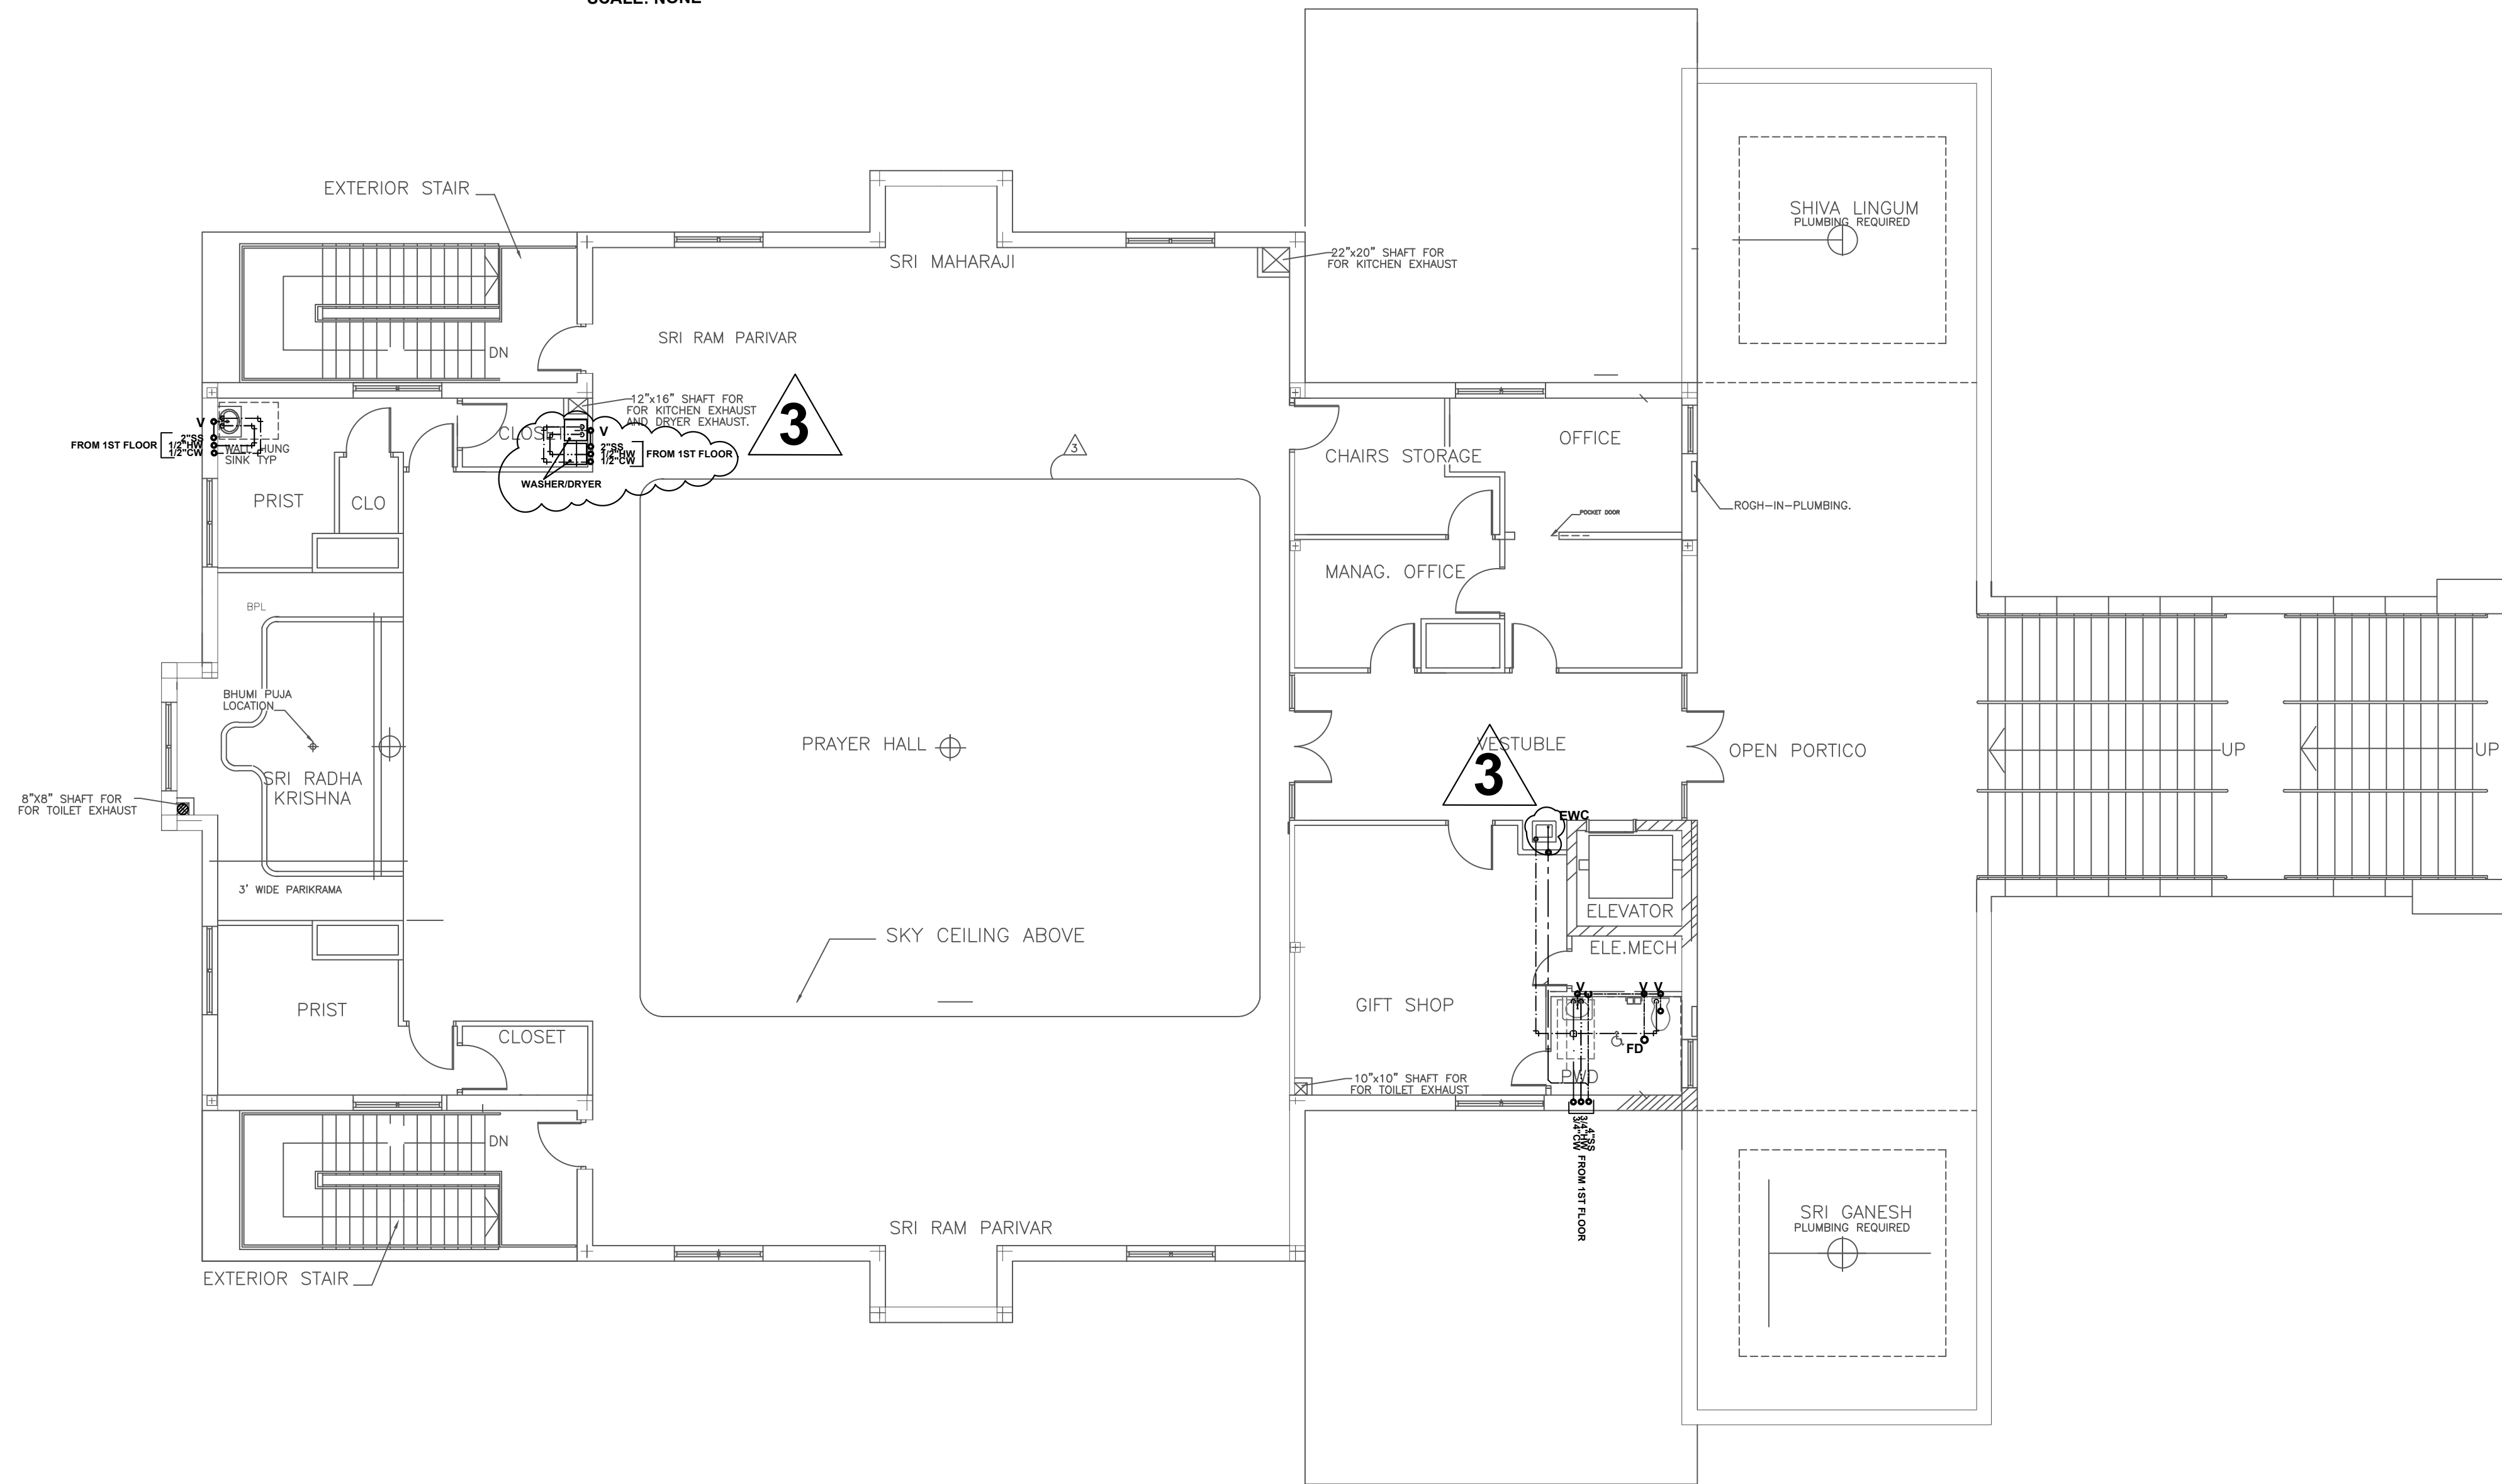


PLUMBING FIXTURE SCHEDULE			
TYPE	LOCATION	STANDARD	MAKE AND MODEL
LAVATORY	ALL TOILETS	ASME A112.19.2	AMERICAN STANDARD MODEL# 0356.028, COMPLETE WITH AMERICAN STANDARD FAUCET MODEL# 6028.201
COMMODE	ALL TOILETS	ASME A112.19.2 ANSI A117.1	AMERICAN STANDARD MODEL# 2386.010, COMPLETE WITH SEAT, FLUSH TANK MODEL#4019.016
3-COMP. SINK	KITCHEN	ASME A112.19.3M	ELKAY MODEL SS8345L4
HAND SINK	KITCHEN	ASME A112.19.3M	GSW USA MODEL HS-1615SS
MOP SINK	JAN. CLOSET	ASME A112.19.3M	ELKAY MODEL ESSW 2520C

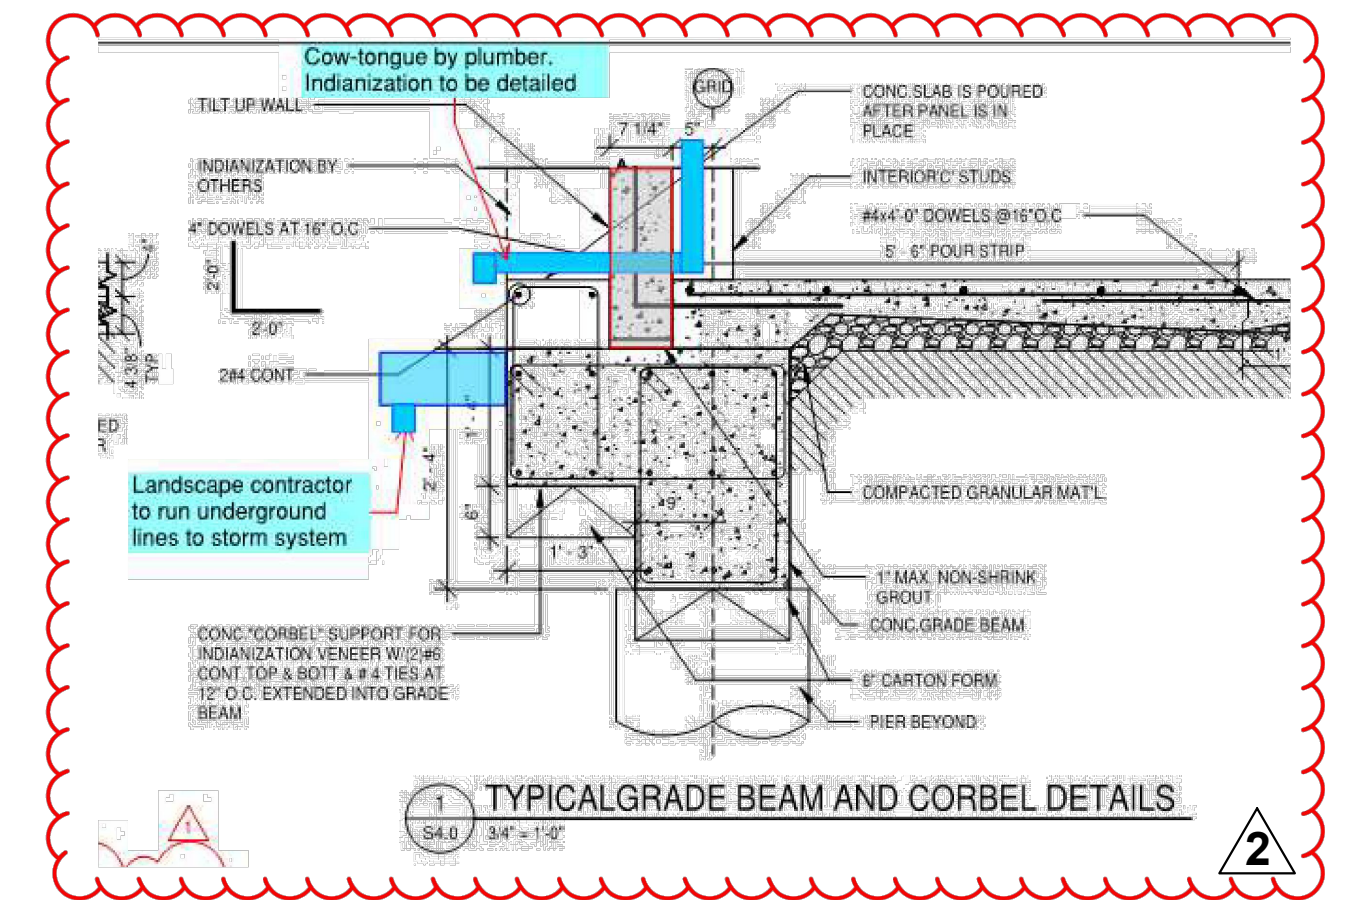

CONSULTANT:
WAHEED CONSULTING
MECHANICAL-ELECTRICAL-PLUMBING SYSTEM DESIGNS
Registration No. F-6336
TEL (817) 793 2010, FAX: (972) 442 4063
420 PARKSIDE ST. MURPHY, TX, 75094
E-mail: waheedmep@yahoo.com

rev	△ 10-31-2016	Revised as noted
rev	△ 10-20-2016	Revised as noted
rev	△ 11-05-15	City Comments
scale	AS NOTED	
drawn by	CADD-NV	
SHASHI D. PATEL AIA NCARB ARCHITECTS AND PLANNERS 442 EAST END AVE. STE-B. PITTSBURGH PA 15221		
SECOND FLOOR PLUMBING PLAN		
CONSTRUCTION DOCUMENT PHASE		
RADHA KRISHNA TEMPLE		
ALLEN TEXAS		
dwg. no.	07162013	

COPYRIGHT © 2014 BY SHASHI D. PATEL AIA. ALL RIGHTS RESERVED. REPRODUCTION IN PART OR WHOLE IS PROHIBITED WITHOUT A WRITTEN CONSENT FROM SHASHI D. PATEL AIA NCARB