

SECOND FLOOR LIGHTING PLAN  
 SCALE : 1/8" = 1' - 0"


ELECTRIC SYMBOLS			
SYMBOL	DESCRIPTION	SYMBOL	DESCRIPTION
	120V DUPLEX RECEPTACLE		PRESET MARK 7 DIMMER/1T/W / SINGLE POLE OR 3 POLE
	120V QUAD RECEPTACLE		THREE WAY SWITCH
	120V DUPLEX RECEPTACLE W/ (2) USB		OCCUPANCY SENSOR SWITCH
	120V GFCI DUPLEX RECEPTACLE		OCCUPANCY SENSOR SWITCH
	120V GFCI WATERPROOF DUPLEX		PHOTOCELL
	208V RECEPTACLE		MOTOR
	120V DUPLEX FLOOR RECEPTACLE		MOTOR W/ LIGHT
	WALL LIGHT FIXTURE		JUNCTION BOX
	CEILING FIXTURE		SAFETY SWITCH
	PENDANT CEILING FIXTURE		TELEPHONE RECEPTACLE
	2X2 LED LIGHT FIXTURE		CAT6 NETWORK RECEPTACLE
	STEP LIGHT FIXTURE		TELEPHONE/CAT6 NETWORK RECEPT
	EXIT LIGHT		CABLE TELEVISION RECEPTACLE
	REMOTE EM. LIGHT HEAD		CIRCUIT LEG & CIRCUIT #
	BATTERY PACK/EM. LIGHTS		HEIGHT ABOVE FINISHED FLOOR
	DOOR BELL - BUTTON		FIRE ALARM PULL
	DOOR BELL		FIRE ALARM STROBE
	SMOKE DETECTOR		FIRE ALARM HORN & STROBE
	HEAT DETECTOR		FIRE ALARM HORN

**KEY NOTES:**

1. ALL RESTROOMS, ELECTRICAL ROOMS SHALL HAVE SEPARATE EMERGENCY WALL PACK LIGHT. ALL EMERGENCY LIGHT AND EXIT LIGHTING SHALL BE WIRED TO THE NORMAL WIRING CIRCUIT WHERE THEY ARE INSTALLED. THE BATTERY PACK SHALL BE TIED INTO THE HOT LEG AND AHEAD OF THE ROOM SWITCH.
2. ALL EXTERIOR ILLUMINATION SHALL BE NON APPARENT FROM THE ADJACENT PROPERTY. ALL LIGHT SOURCES USED AT THE BOUNDING BOUNDARY LINES SHALL BE SHIELDED TO ELIMINATE PROBLEMS OF GLARE, REFLECTIONS AND PREVENT EXCESSIVE OR DIRECT ILLUMINATION.
3. ALL CIRCUITS WHICH CONTROL EMERGENCY AND/OR EXIT LIGHTING MUST BE PROPERLY LABELED.

**LIGHT SWITCHES:**

LIGHT SWITCHES SHOWN ARE REPRESENTATIVE IN NATURE ONLY. ALL INTERIOR LIGHTING SHALL BE ON DIMMABLE SWITCHES. CONTRACTOR SHALL VERIFY AND COORDINATE WITH OWNER AND ARCHITECT FOR EXACT LOCATION AND TYPES OF SWITCHES TO BE INSTALLED.

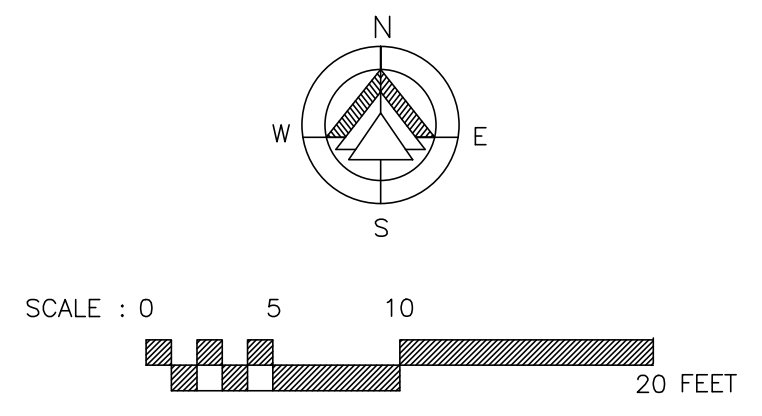

SEAL:

10-29-16

CONSULTANT:  
**WAHEED CONSULTING**  
 MECHANICAL-ELECTRICAL-PLUMBING SYSTEM DESIGNS  
 Registration No. F-6336

TEL (817) 793 2010, FAX: (972) 442 4063  
 420 PARKSIDE ST. MURPHY, TX, 75094  
 E-mail: waheedmep@yahoo.com

rev	△	10-09-2016	LIGHTING REVISED
rev	△	11-05-2015	CITY COMMENTS
date		10-05-2015	RELEASE FOR CONSTRUCTION
scale			AS NOTED
drawn by			CADD-NV
		SHASHI D. PATEL AIA NCARB ARCHITECTS AND PLANNERS 442 EAST END AVE. STE-B. PITTSBURGH PA 15221	
SECOND FLOOR LIGHTING PLAN CONSTRUCTION DOCUMENT PHASE			
RADHA KRISHNA TEMPLE ALLEN TEXAS			
dwg. no.		07162013	

COPYRIGHT © 2014 BY SHASHI D. PATEL, AIA. ALL RIGHTS RESERVED. REPRODUCTION IN PART OR WHOLE IS PROHIBITED WITHOUT A WRITTEN CONSENT FROM SHASHI D. PATEL, AIA, INC.