
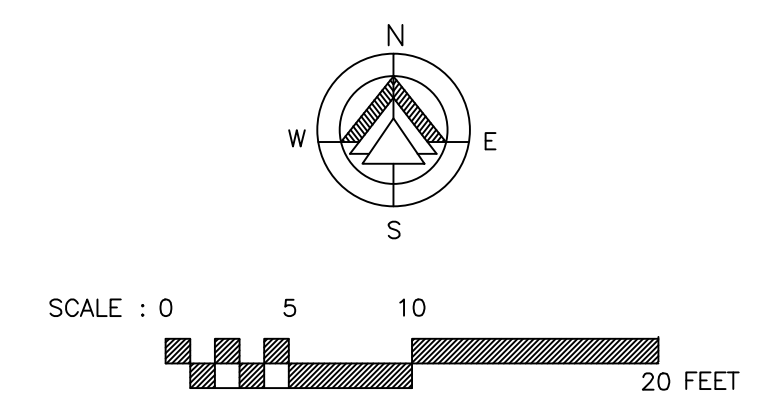
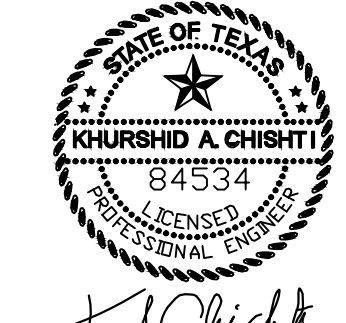


ROOF HVAC PLAN
SCALE: 1/8"=1'-0"

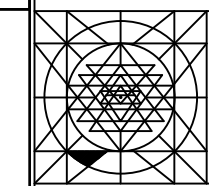


 KHURSHID A. CHISTI
 84534
 MECHANICAL, ELECTRICAL AND PLUMBING
 10/20/16

CONSULTANT:
WAHEED CONSULTING
 MECHANICAL-ELECTRICAL-PLUMBING SYSTEM DESIGNS
 Registration No. F-6336
 TEL: (817) 793 2010, FAX: (972) 442 4063
 420 PARKSIDE ST. MURPHY, TX, 75094
 E-mail: waheedmep@yahoo.com

rev	△ 10-20-2016	Revised as noted
rev	△ 11-05-15	City Comments
scale	AS NOTED	
drawn by	CADD-SPA	
 SHASHI D. PATEL AIA NCARB ARCHITECTS AND PLANNERS 442 EAST END AVE. STE-B. PITTSBURGH PA 15221		ROOF PLUMBING PLAN AND DETAILS CONSTRUCTION DOCUMENT PHASE
RADHA KRISHNA TEMPLE ALLEN TEXAS		