

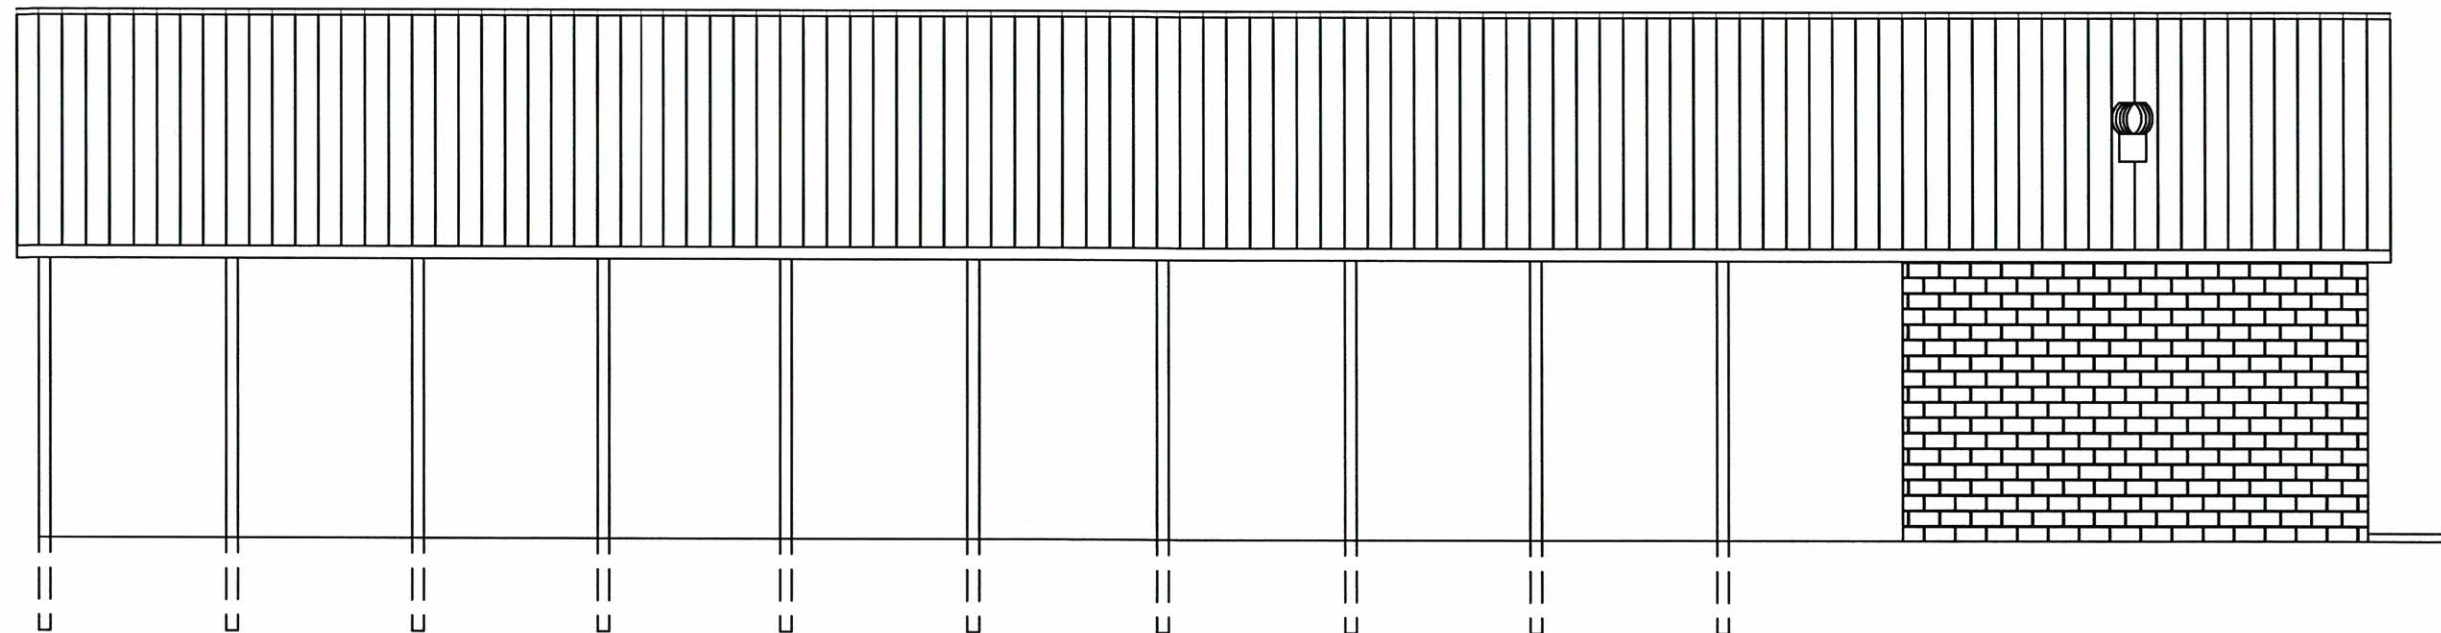
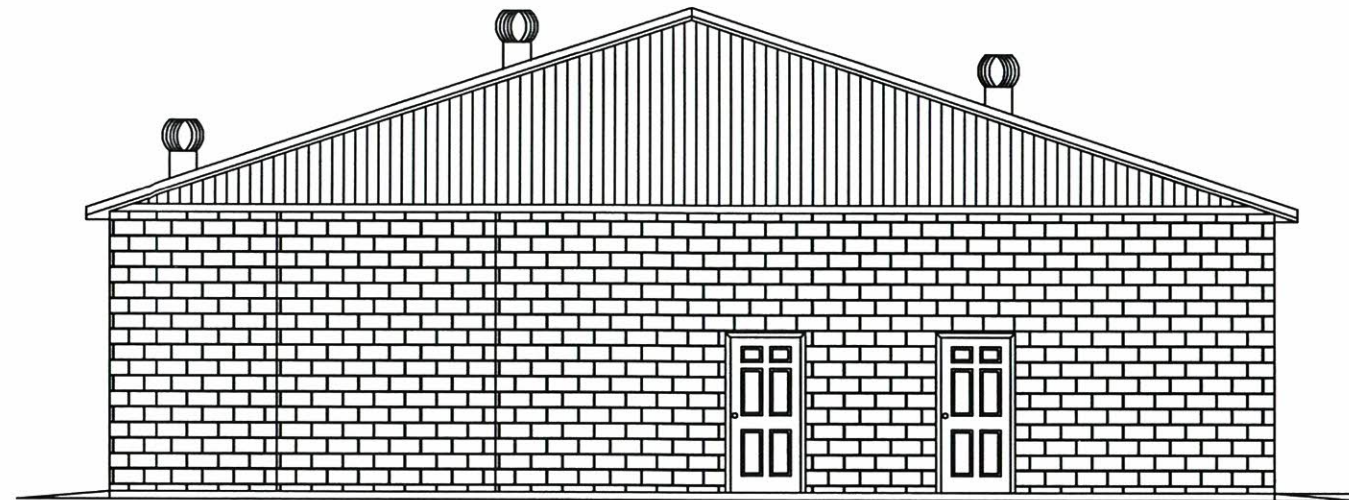
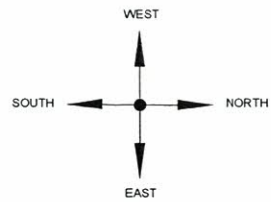


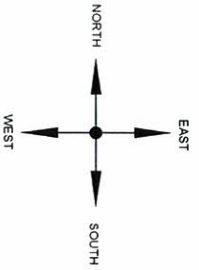



PURPOSED POLE BARN AND RESTROOMS FOR MOULTON LIONS CLUB

DRAWN BY:
BRUCE REYNOLDS
TRINITY ALABAMA
256-565-2062 reynoldsdraftingservice@yahoo.com

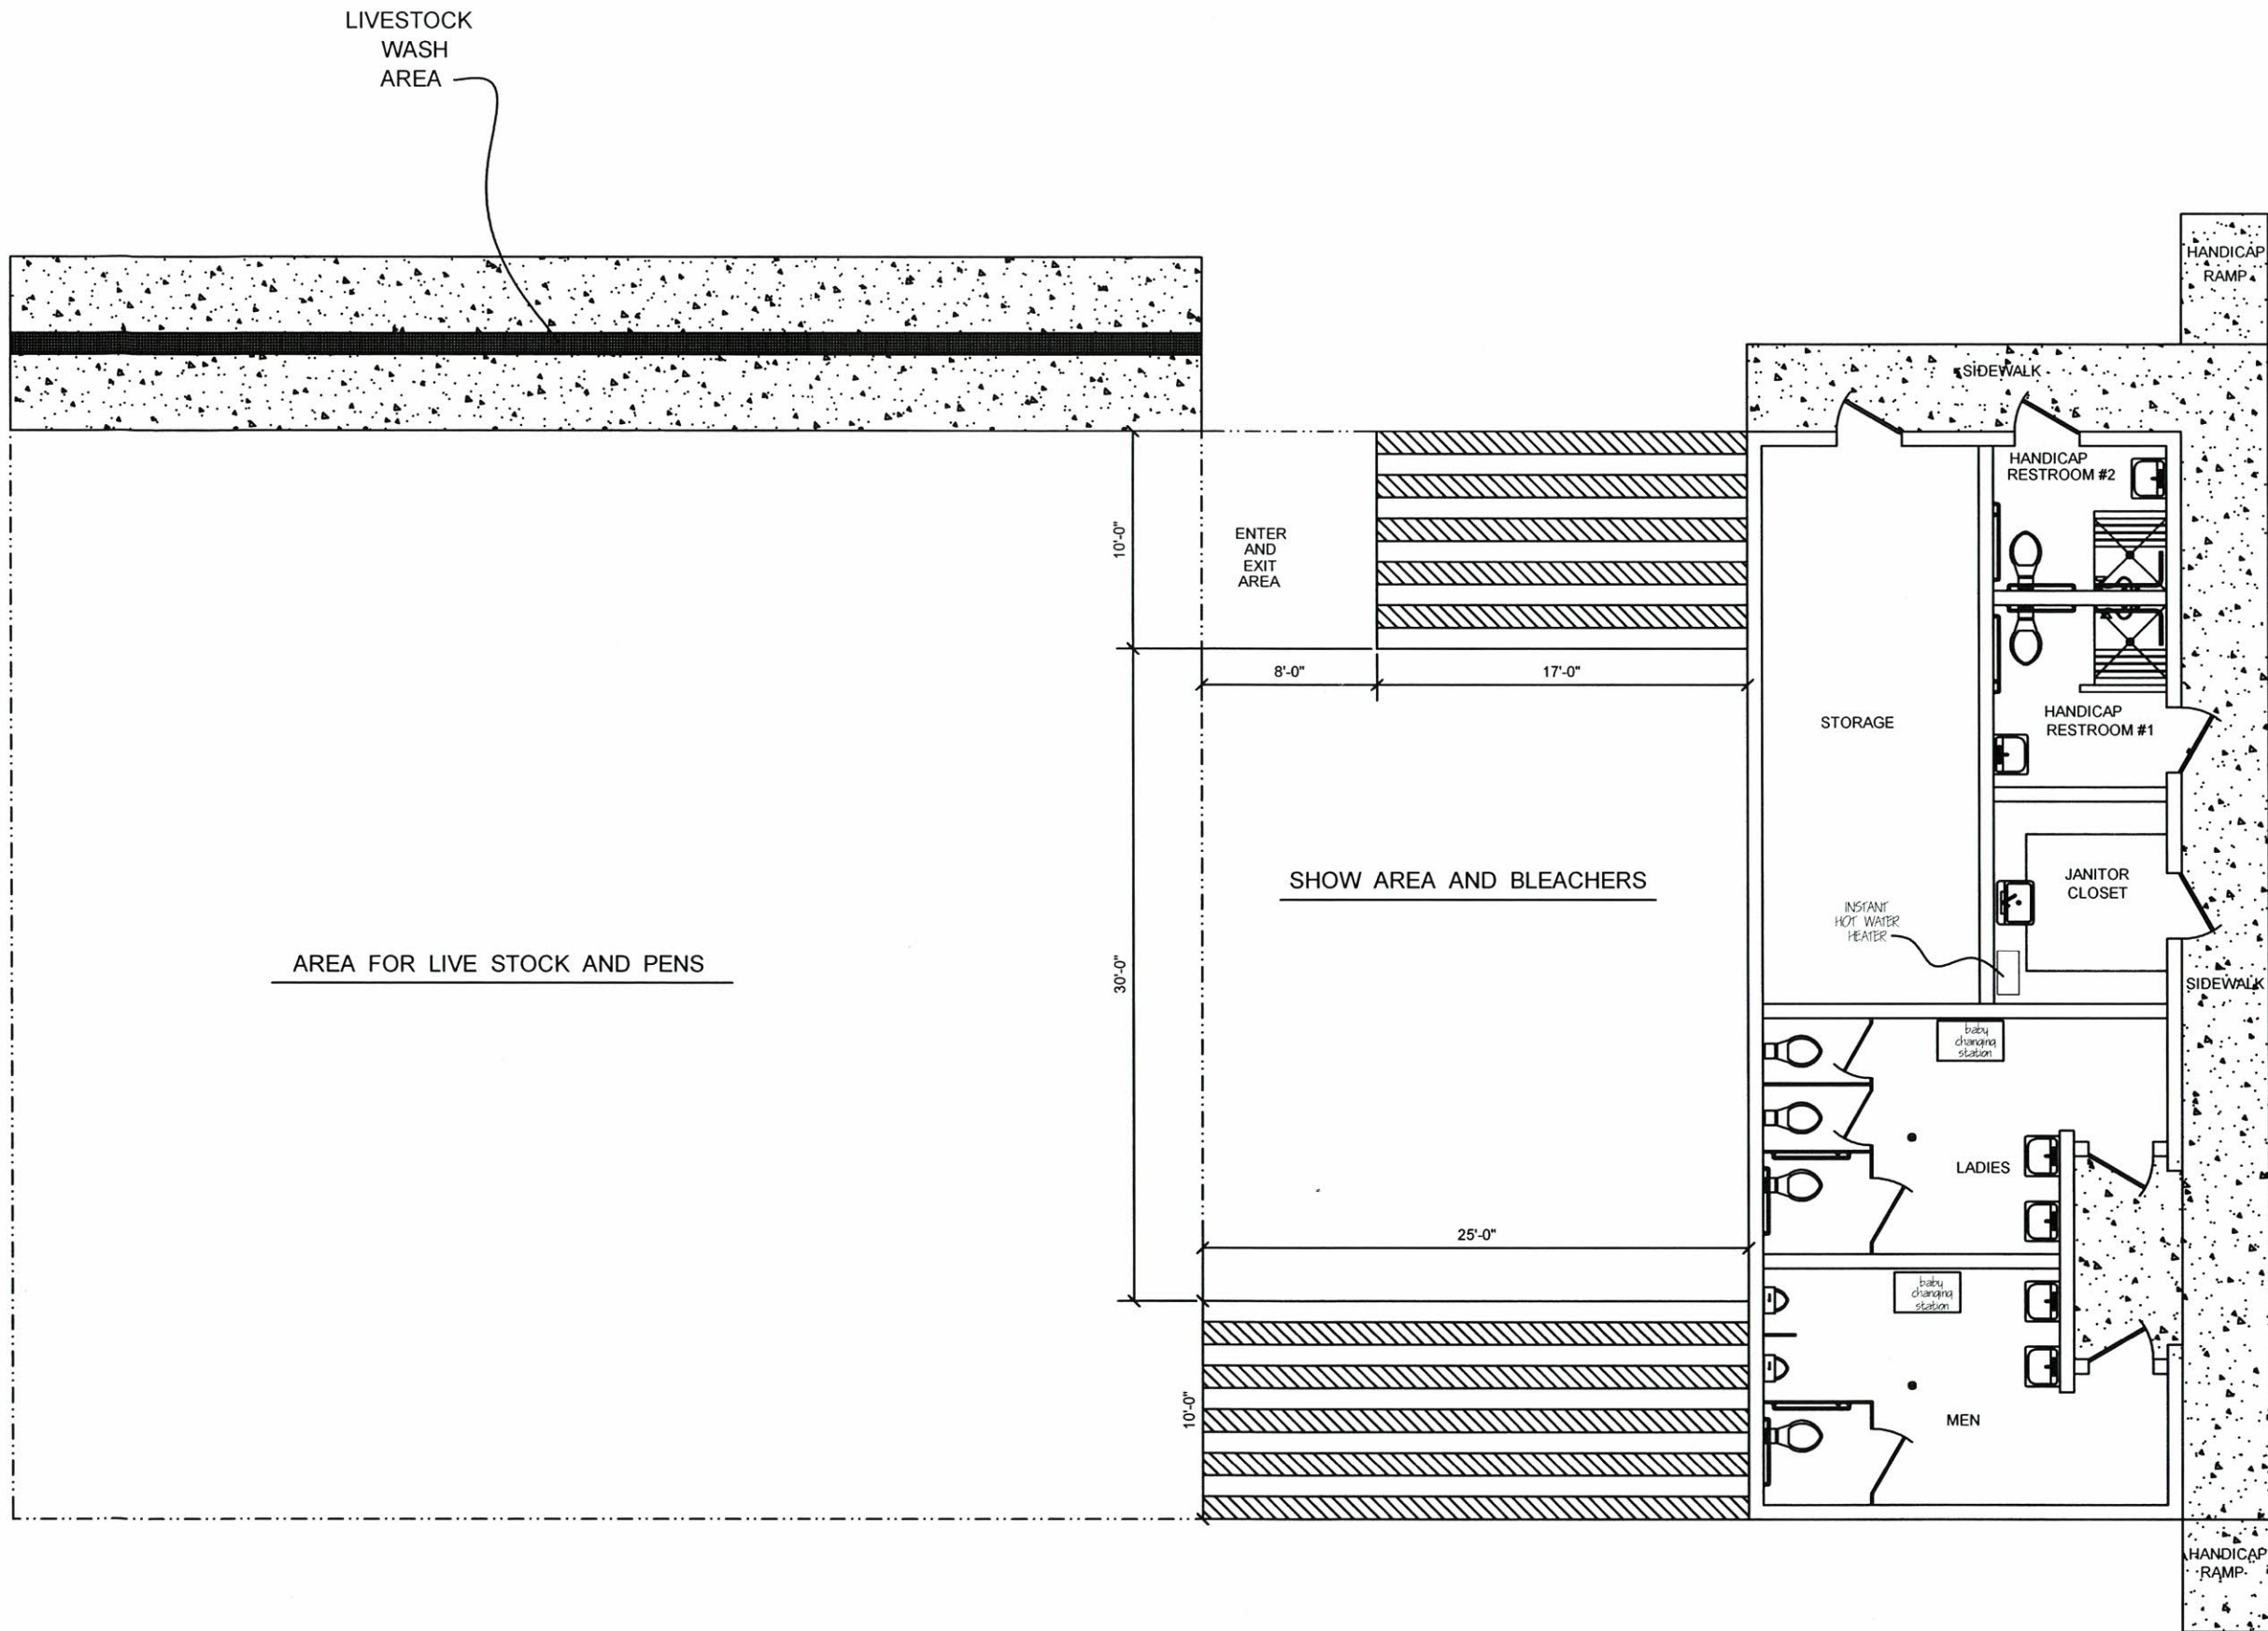


PLAN VIEW

<i>Plans For:</i>	
MOULTON, LIONS CLUB	
<i>Drawn by:</i>	<i>Phone</i>
BRUCE REYNOLDS	1-256-565-2062
<i>Trinity, Alabama</i>	reynoldsdraftingservice@yahoo.com
<i>Date</i>	
7-1-2018	PLAN VIEW

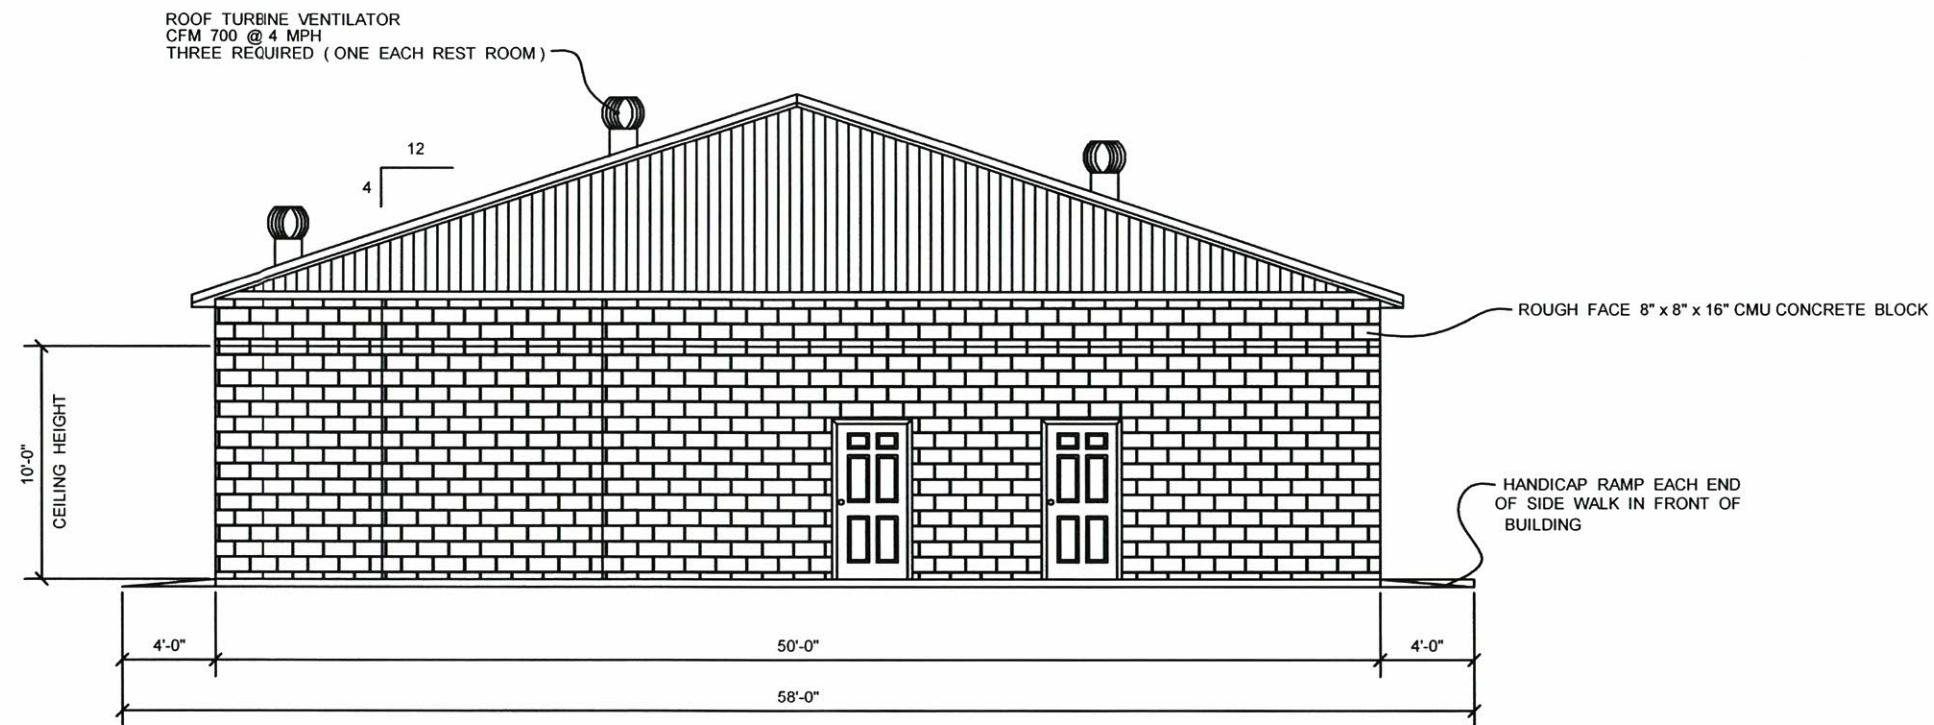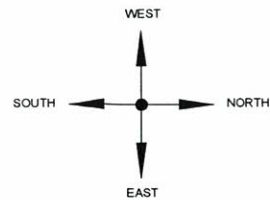



FRONT ELEVATION
EAST SIDE

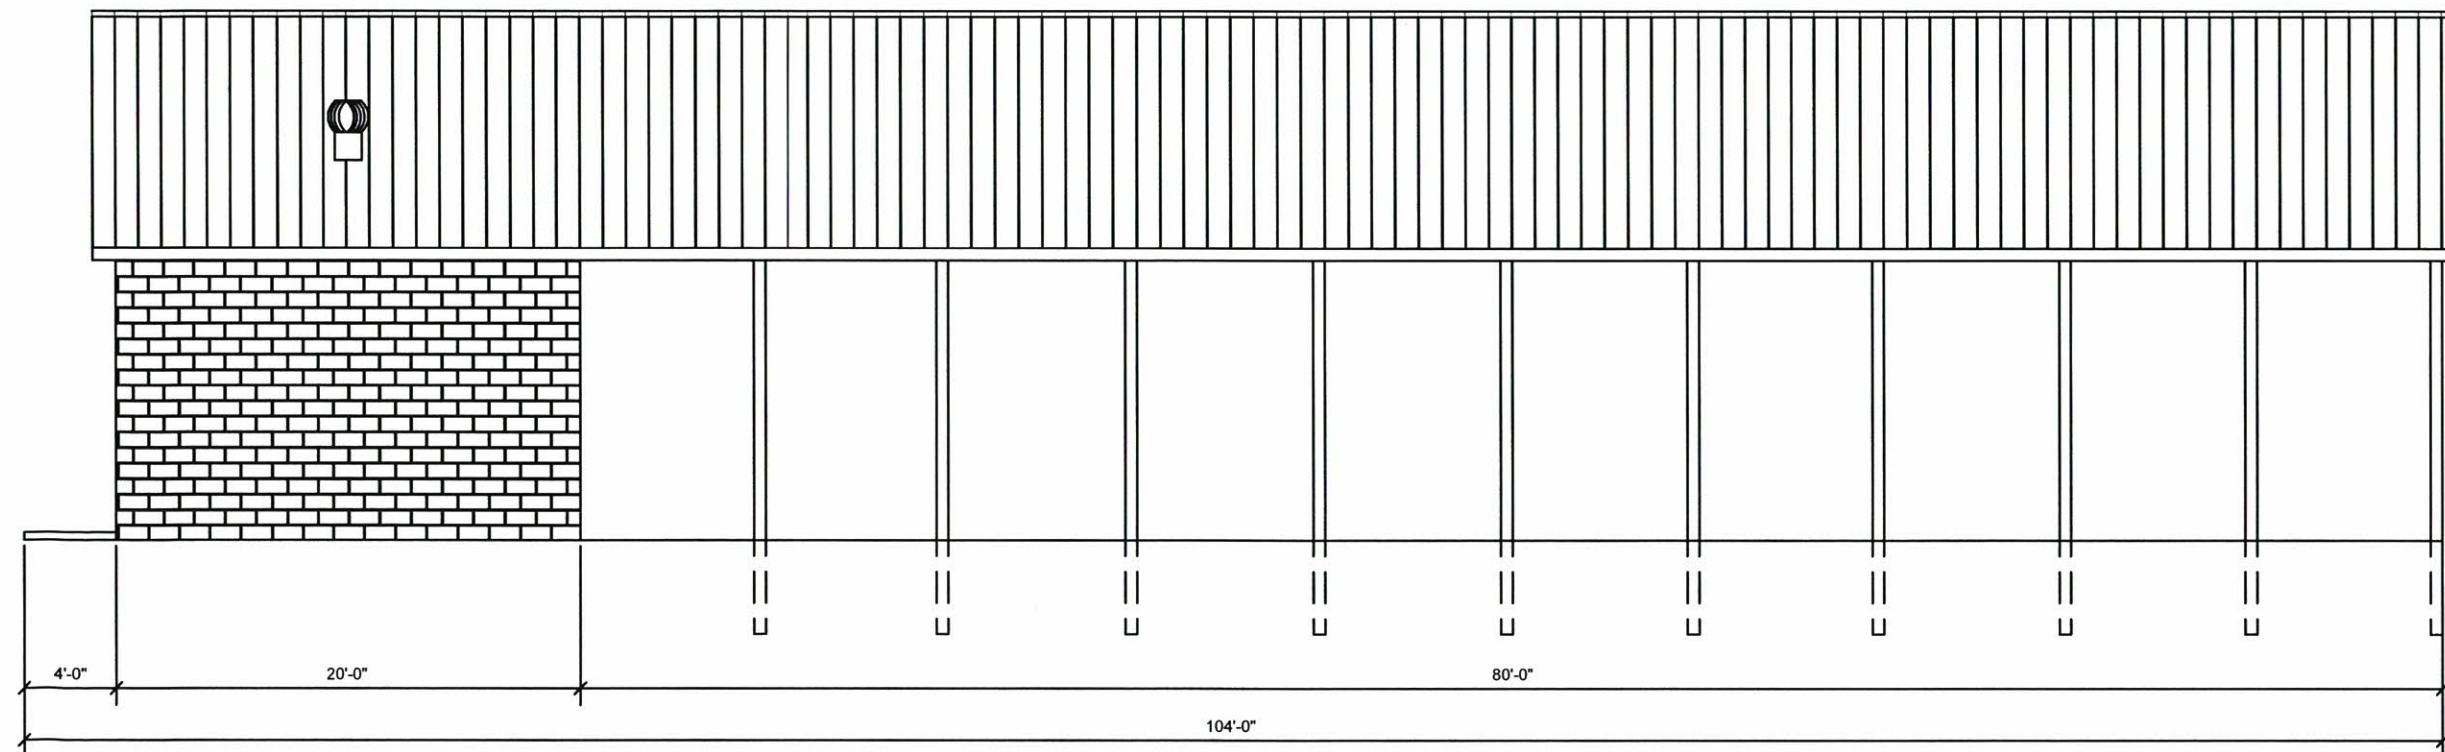

RIGHT ELEVATION
NORTH SIDE


CEILING HEIGHT OF RESTROOM AND HANDICAP BATH TO BE 10'-0"
CEILING TO BE 2'-0" x 4'-0" DROP CEILING

Plans For:	
MOULTON, LIONS CLUB	
Drawn by:	Phone
BRUCE REYNOLDS	1-256-565-2062
Trinity, Alabama	reynoldsdraftingservice@yahoo.com
Date	
7-1-2018	ELEVATION PLAN

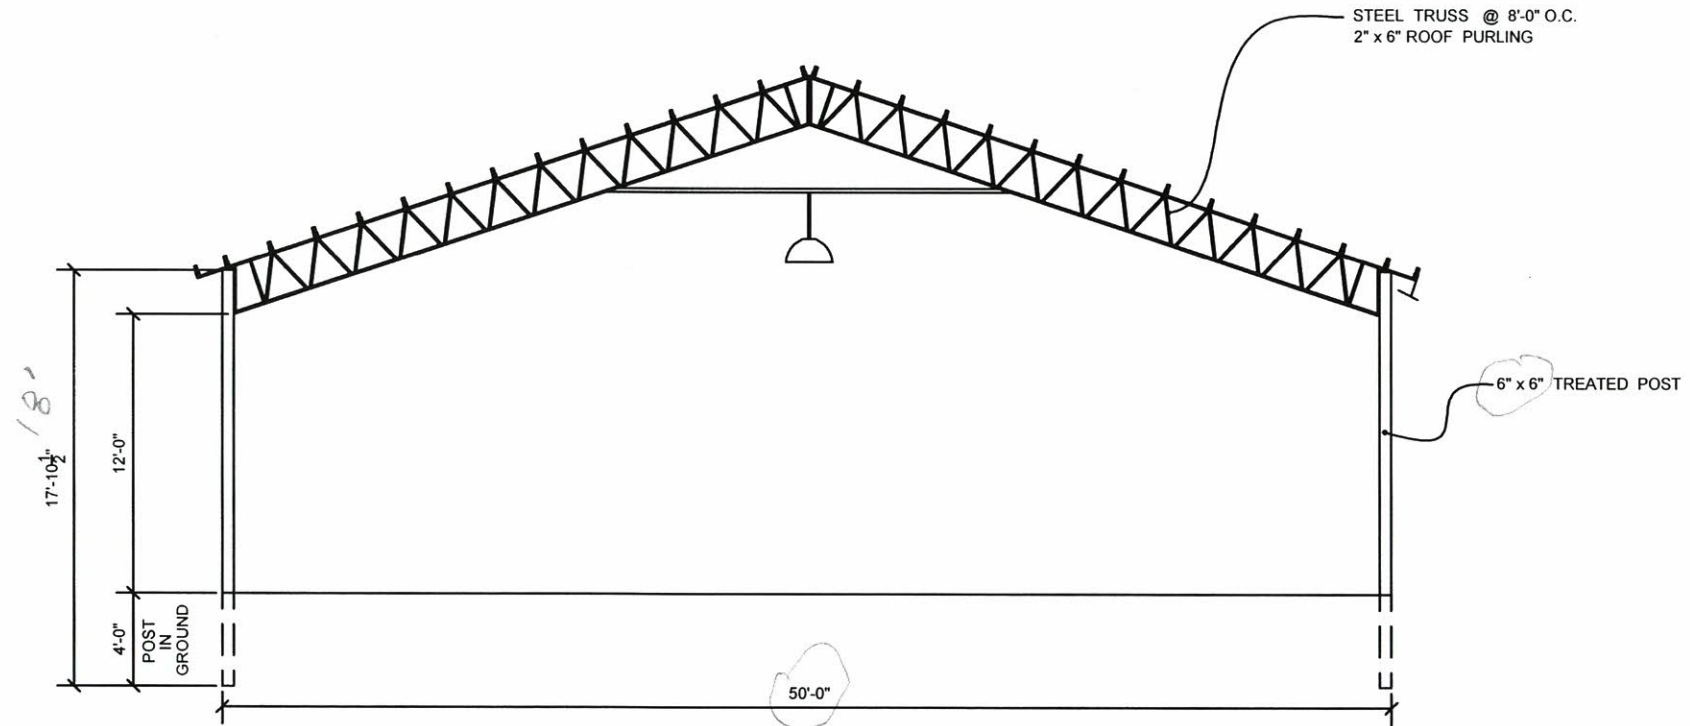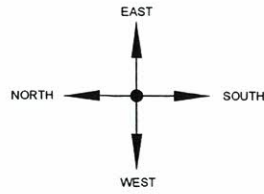



REAR ELEVATION
WEST SIDE

ROOF PANEL TO BE 29 ga. 36" WIDE
RIB HT. 3/4" OR 1-1/4"
EXPOSED FASTENERS
SLOPE 4:12
PANEL TRIMS
COLOR: WHITE
12" OVERHANG

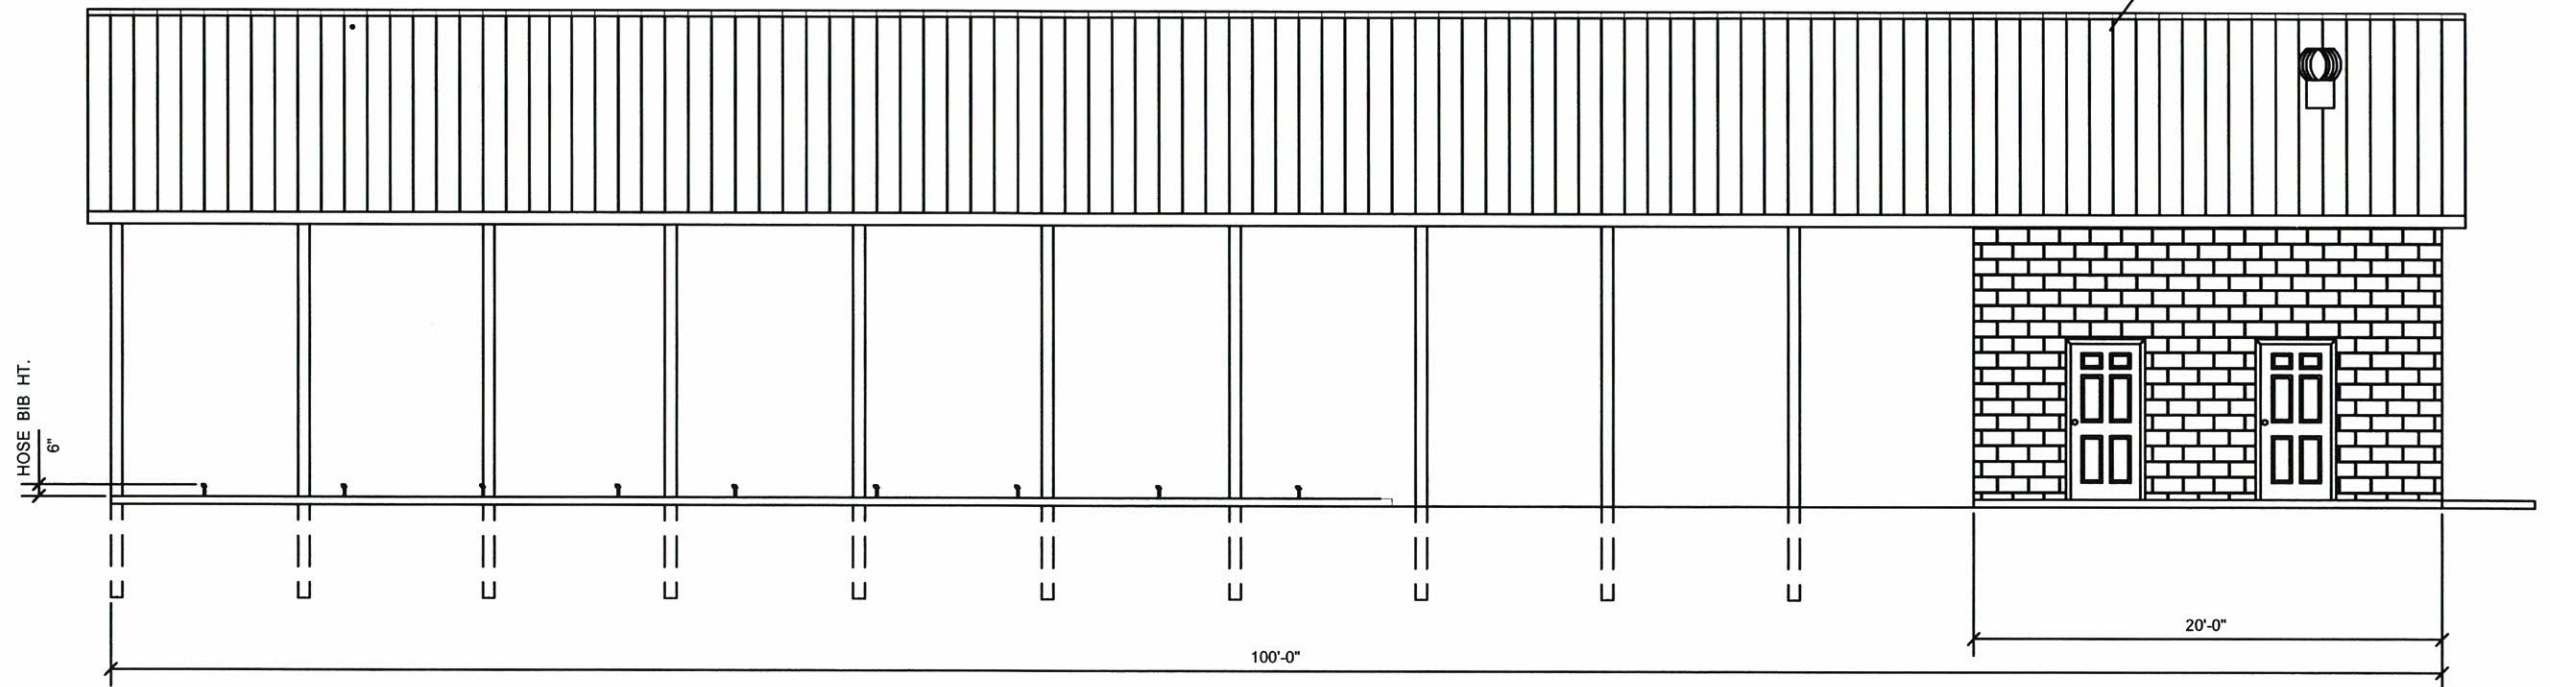

LEFT ELEVATION
SOUTH SIDE

<i>Plans For:</i>	
MOULTON, LIONS CLUB	
<i>Drawn by:</i>	<i>Phone</i>
BRUCE REYNOLDS	1-256-565-2062
<i>Trinity, Alabama</i>	reynoldsdraftingservice@yahoo.com
<i>Date</i>	
7-1-2018	ELEVATION PLAN

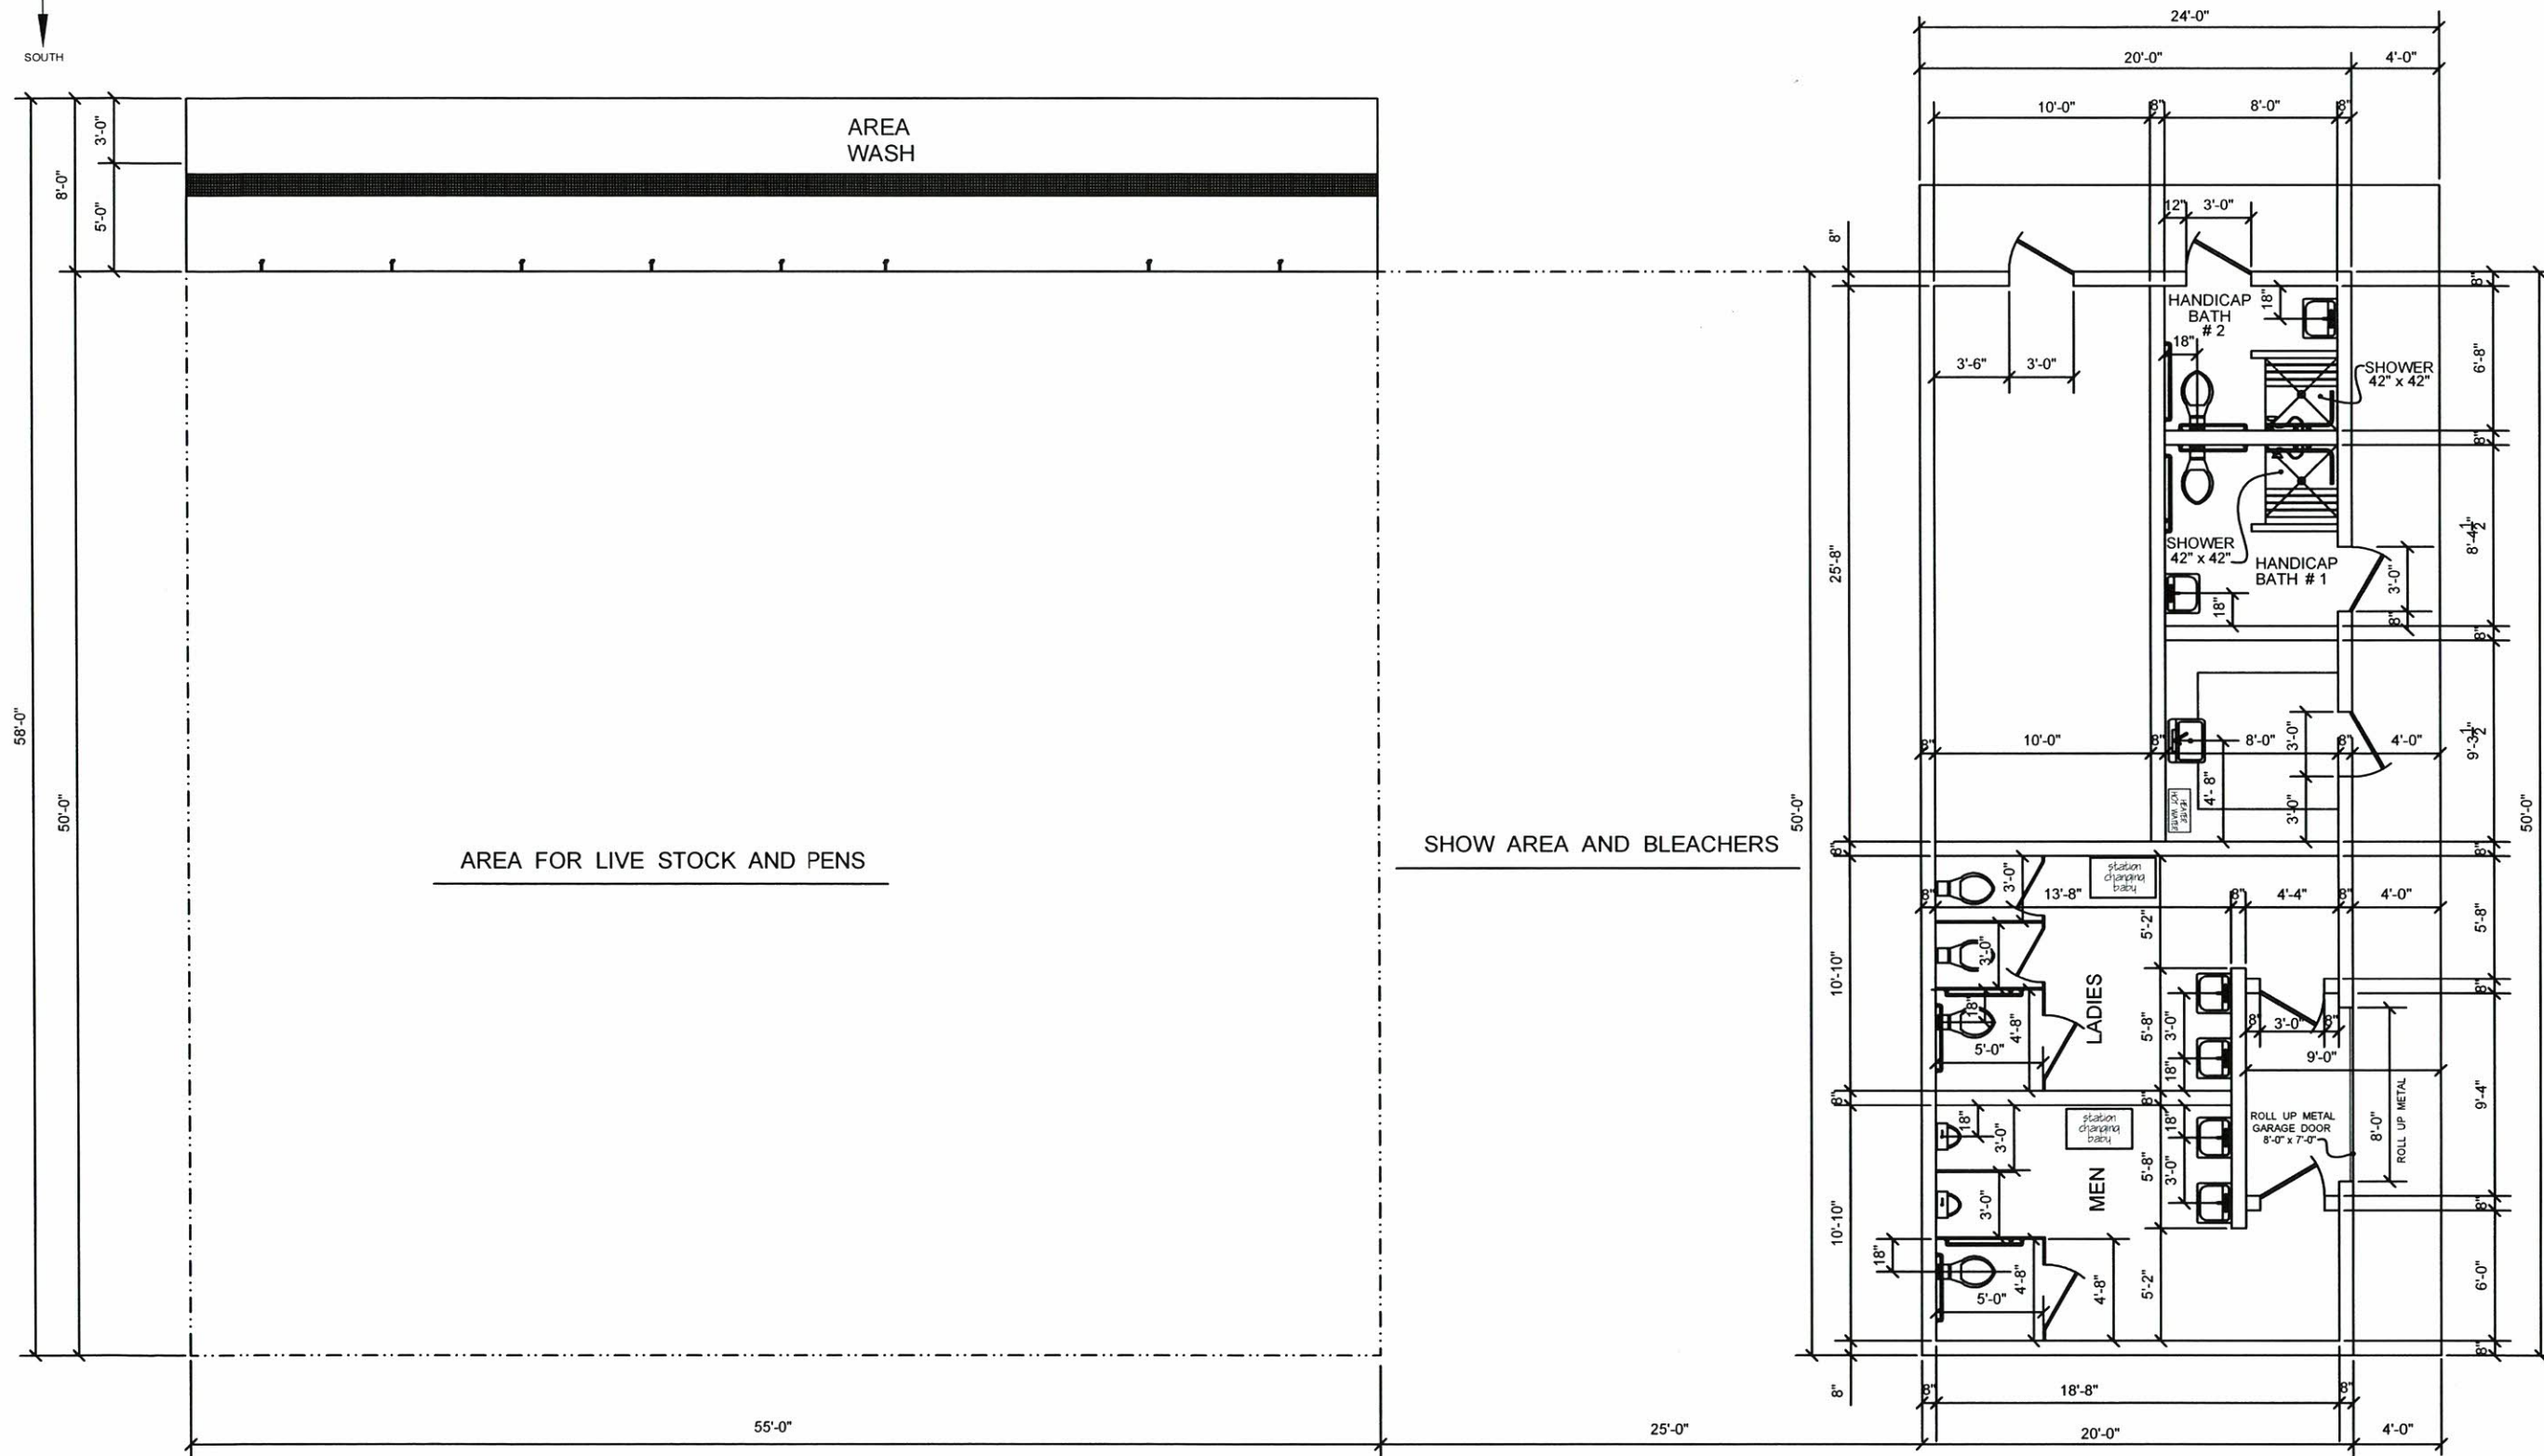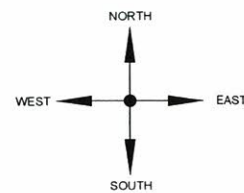


CEILING HEIGHT OF RESTROOM AND HANDICAP BATH TO BE 10'-0"
CEILING TO BE 2'-0" x 4'-0" DROP CEILING

FLOOR PLAN
scale: 1/4" = 1'-0"


DOORS:

ALL DOORS TO BE 36" METAL (7 TOTAL)
ALL DOORS TO HAVE LOUVERS IN BOTTOM
ONE 8'-0" x 7'-0" METAL ROLL UP DOOR


Plans For:	
MOULTON, LIONS CLUB	
Drawn by:	Phone
BRUCE REYNOLDS	1-256-565-2062
Trinity, Alabama	reynoldsdraftingservice@yahoo.com
Date	
7-1-2018	FLOOR PLAN

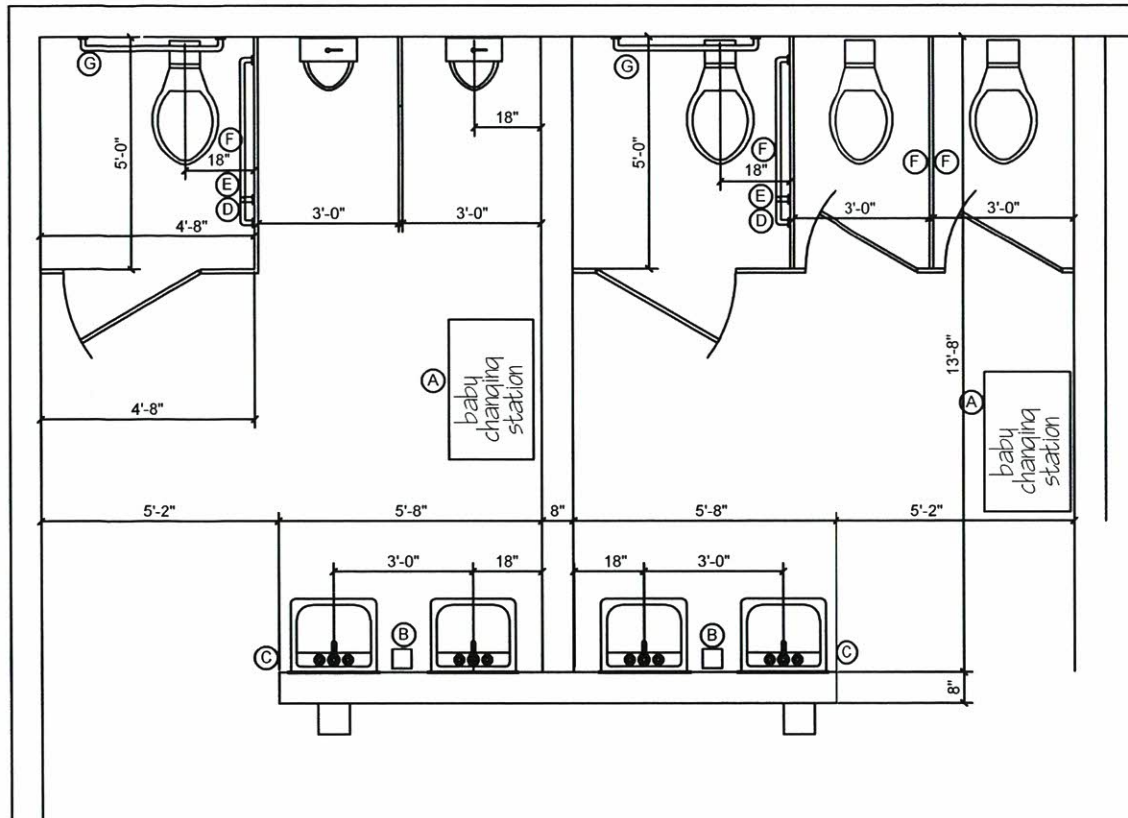

PUBLIC RESTROOM

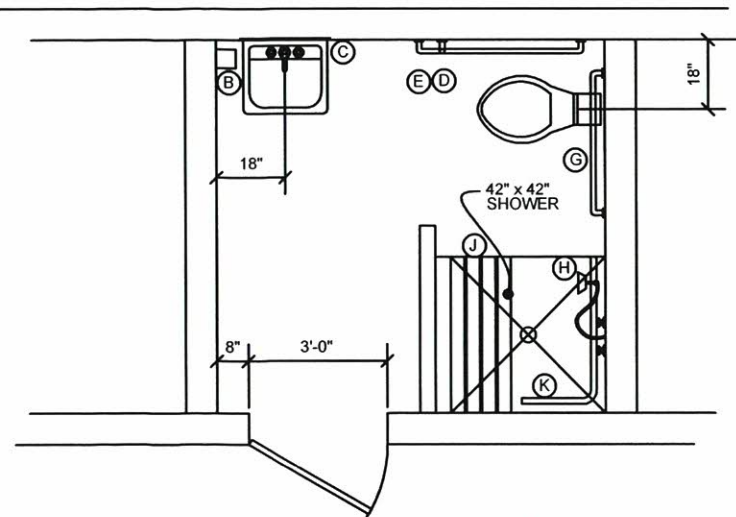

HANDICAP BATH #1

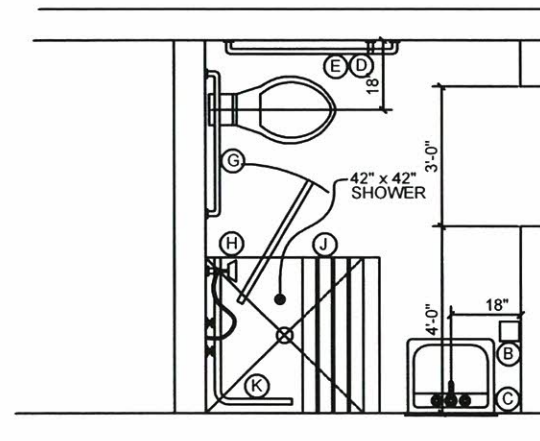

HANDICAP BATH #2

RESTROOM DETAILS

MOUNTING HEIGHTS

REST ROOMS : (MEN & LADIES)

SINKS TOP OF FIXTURE BOWL 2'-10"
URINAL 1'-5"
WATER CLOSET TOP OF LID 1'-4"
TOILET PAPER DISPENSER 1'-4"
GRAB BARS 2'-9"
MIRROR BOTTOM 3'-4"
SOAP DISPENSER 3'-4"

MOUNTING HEIGHTS

HANDICAP BATH :

SINKS TOP OF FIXTURE BOWL 2'-10"
WATER CLOSET TOP OF LID 1'-7"
TOILET PAPER DISPENSER 1'-7"
VERTICAL GRAB BARS BOTTOM 3'-3"
HORIZONTAL GRAB BARS 2'-9"
MIRROR BOTTOM 3'-4"
SOAP DISPENSER 3'-4"
FOLD UP SHOWER BENCH 1'-6" SEAT TOP

NOTES:

- A. FOLD DOWN COMMERCIAL BABY CHANGING DIAPER STATION
ECR4KIDS MODEL # ELR-18004
COLOR - GRAY
2- REQUIRED
- B. LIQUID SOAP DISPENSER
GLOBAL INDUSTRIAL STAINLESS STEEL VERTICAL 1000 ml
ITEM # T9F640905
WALL MOUNT
3- REQUIRED
- C. WALL MIRROR 24" x 30"
HOME DEPOT GLACIER BAY
MODEL # 81173
STORE SKU # 1001085210
5- REQUIRED
- D. 18" VERTICAL GRAB BAR
MOEN 8718 18 INCH
ITEM MODEL # 8718
4- REQUIRED
- E. MOEN 8742 42" GRAB BAR
ITEM MODEL # 8742
4- REQUIRED
- F. SAN JAMAR DOUBLE ROLL TOILET TISSUE DISPENSER
MODEL # R3690TBL
6- REQUIRED
- G. MOEN 8736 36" GRAB BAR
4- REQUIRED
- H. MOEN MULTI-FUNCTION HAND SHOWER
PART #MOEN 3669EP
2- REQUIRED
- J. CLEVER 36" DOUBLE SEAT FOLDING SHOWER SEAT
STAINLESS STEEL CHROME FINISH
WALL MOUNT 400 lbs LIMIT
2- REQUIRED
- K. MOEN 8994 36" x 24" x 1-1/2" L-SHAPE GRAB BAR
ITEM MODEL # MOEN 8994
2- REQUIRED

Plans For:

MOULTON, LIONS CLUB

Drawn by:

BRUCE REYNOLDS

Phone

1-256-565-2062


Trinity, Alabama

reynoldsdraftingservice@yahoo.com

Date

7-1-2018

RESTROOM DETAILS

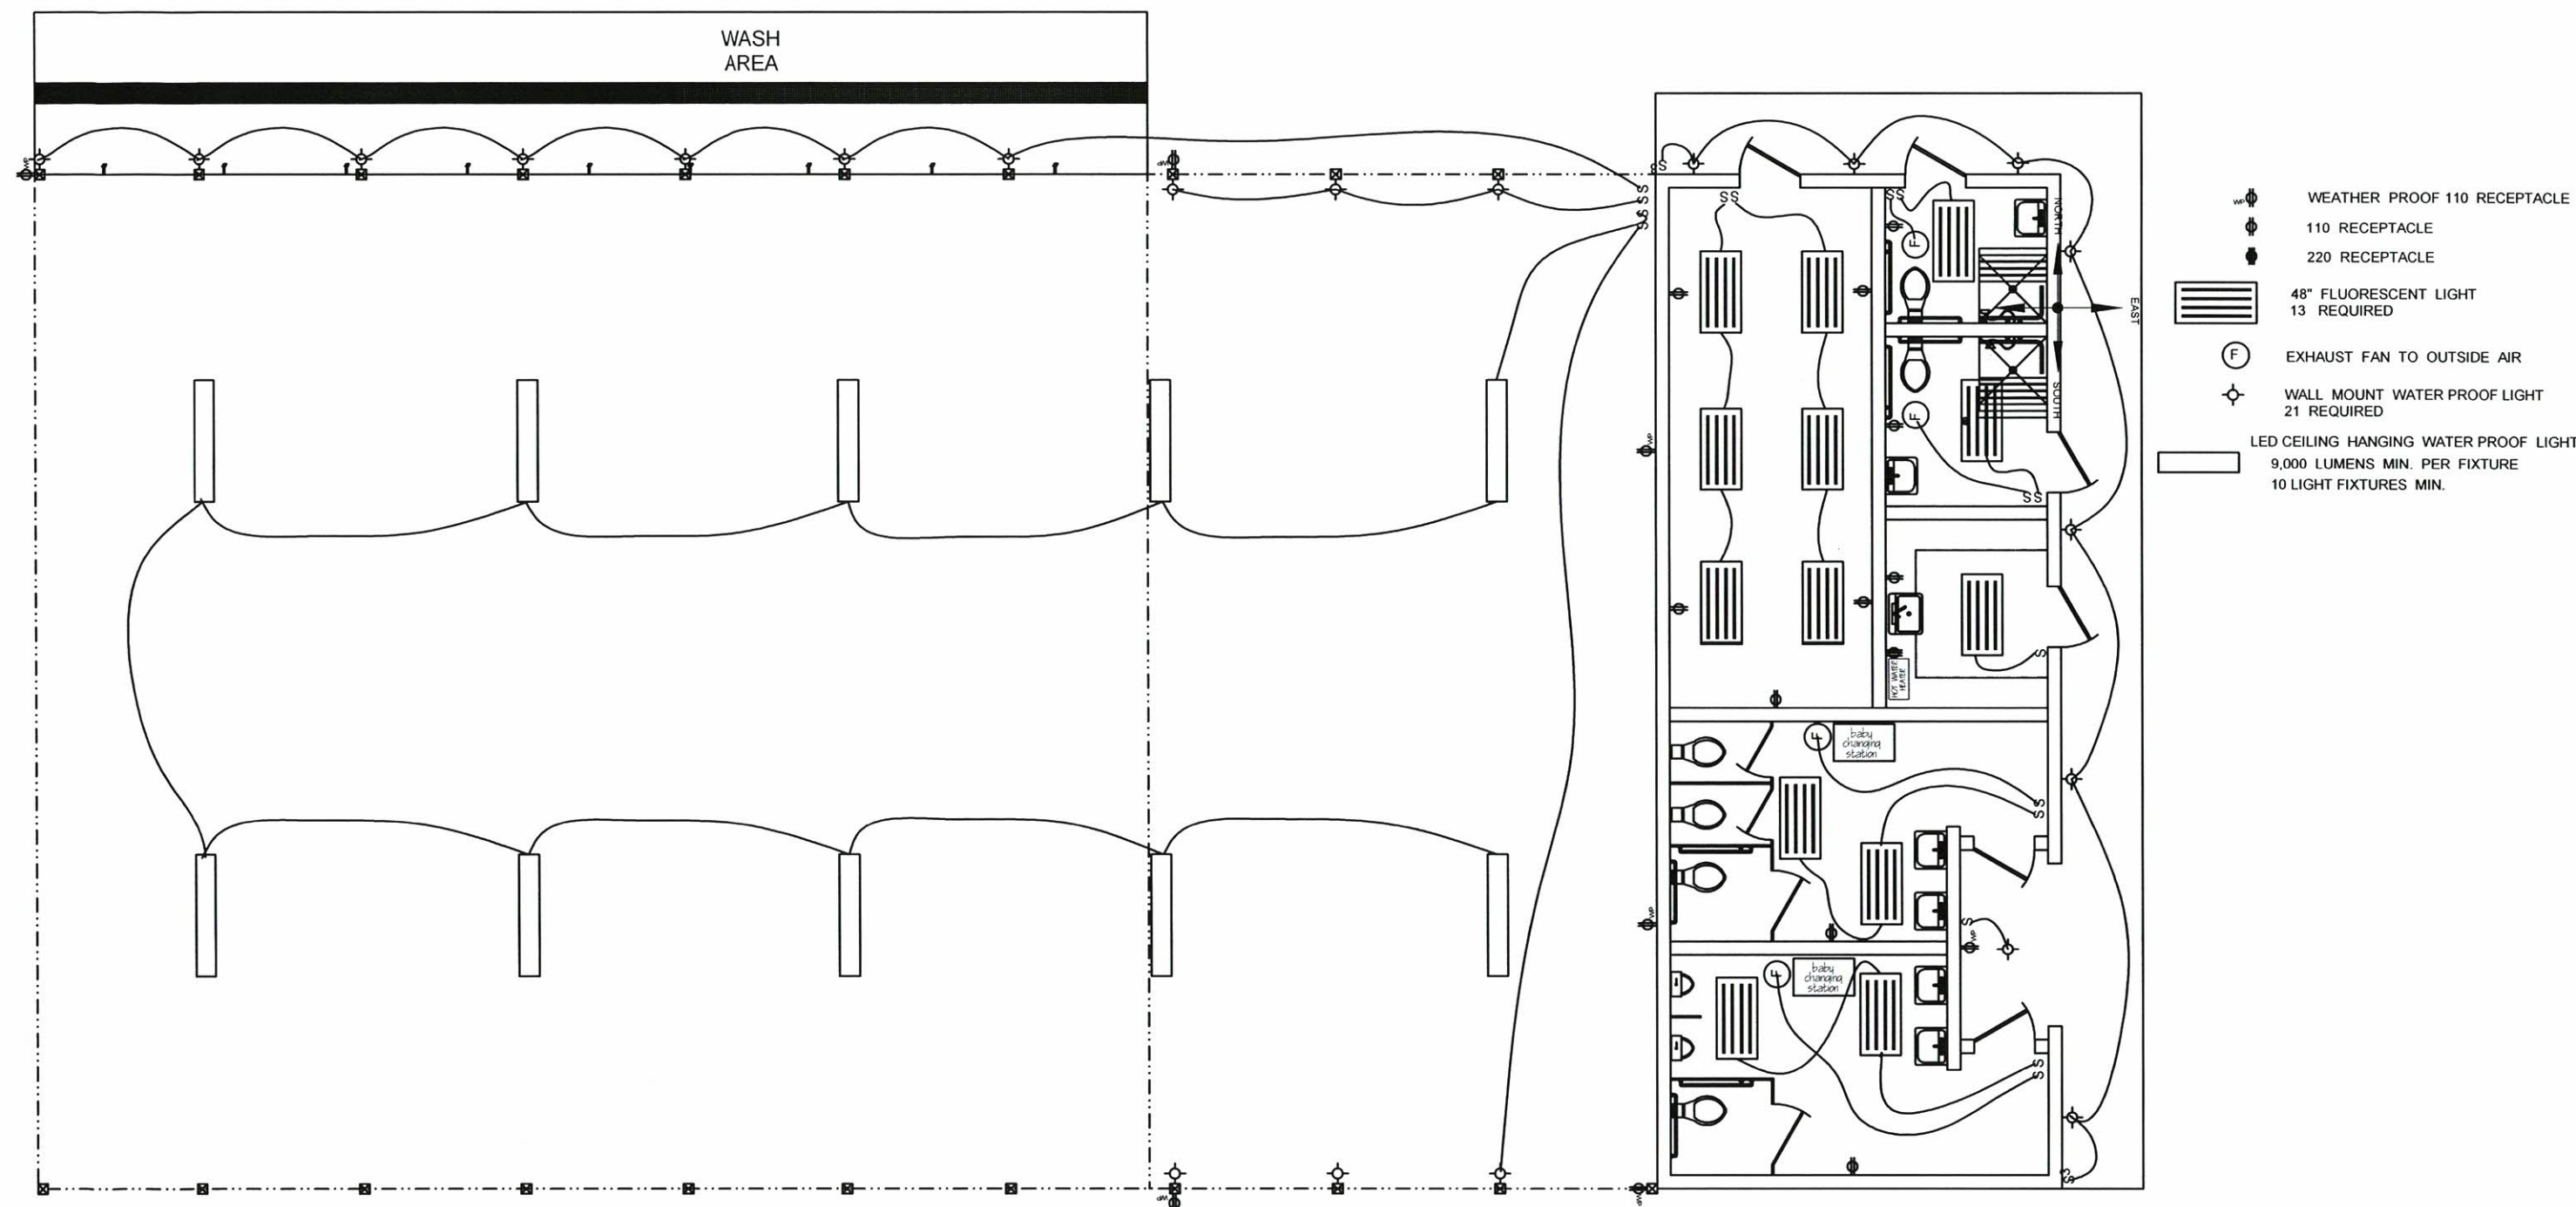

ELECTRICAL PLAN

ALL RECEPTACLES IN
RESTROOMS AND HANDICAP BATH,
TO BE GFIC.

IN RESTROOMS AND HANDICAP BATHROOMS,
ALL LIGHT SWITCHES AND RECEPTACLES
TO BE INSTALLED AT HANDICAP CODES.

Plans For:	
MOULTON, LIONS CLUB	
Drawn by:	Phone
BRUCE REYNOLDS	1-256-565-2062
Trinity, Alabama	reynoldsdraftingservice@yahoo.com
Date	
7-1-2018	ELECTRICAL PLAN



TYPE OF FIXTURE	MODEL	NO. REQUIRED	PIPE CONNECTION SIZES						
			CW	HW	S&W	VENT	TRAP	GAS	
WATER CLOSET	Kohler- K 4325-0 WALL MOUNT 1.6 GPF Kohler- K 4731 SC ELONGATED TOILET SEAT (BUK) Kohler- K 13516-CP CHROME FLUSH VALVE	SIX	1/2"	1/2"	3"	2"	-	-	-
LAVATORY	Kohler- K-2005-0 WHITE WALL MOUNT MOEN 8917 M-BITION FAUCET 1.5 GPM Kohler P-TRAP K5018-CP CHROME	SIX	1/2"	1/2"	2"	1-1/2"	1-1/2"	-	-
UTILITY SINK	UNIVERSAL B52118-1 ONE COMPARTMENT SINK KROWNE 12-802L-COMMERCIAL SERIES 8" CENTER	ONE	1/2"	1/2"	2"	1-1/2"	1-1/2"	-	-
WATER HEATER	Rheem 18 KW SELF-MODULATING 3.5 GPM ELECTRIC TANKLESS	ONE	3/4"	3/4"	-	-	-	-	-
URINAL	Kohler DEXTER K-5016-ET-0 WHITE URINAL Kohler K-13518-CP 1.0 GPF FLUSH VALVE FERNCO FUS-2 WAX FREE URINAL SEAL	TWO	1/2"	-	2"	2"	-	-	-
HOSE BIB		FIFTEEN	3/4"	-	-	-	-	-	-
HANDICAP SHOWER STALL 42" x 42"		TWO	1/2"	1/2"	2"	2"	-	-	-

— SLOPE 6" DIAMETER SEWER PIPE LINE
RUN TO CONNECT WITH CITY SEWAGE.

FALL 1/4" PER FOOT

OUT TO
CITY SEWER
LINE

WASH
AREA

— HOSE BIB TO BE
6" TALL MAX.
INSULATE ALL EXPOSED
BIB AND PIPE
TO COLD WEATHER.
(TYPICAL 9 PLACES)

MOUNTING HEIGHTS

HANDICAP BATH:
SINKS TOP OF FIXTURE BOWL —2'-10"
WATER CLOSET TOP OF LID —1'-7"
TOILET PAPER DISPENSER —1'-7"
VERTICAL GRAB BARS BOTTOM —3'-3"
HORIZONTAL GRAB BARS —2'-9"
MIRROR BOTTOM —3'-4"
SOAP DISPENSER —3'-4"
FOLD UP SHOWER BENCH SEAT TOP —1'-6"

MOUNTING HEIGHTS

REST ROOMS: (MEN & LADIES)
SINKS TOP OF FIXTURE BOWL —2'-10"
URINAL 1'-5"
WATER CLOSET TOP OF LID —1'-4"
TOILET PAPER DISPENSER —1'-4"
GRAB BARS —2'-9"
MIRROR BOTTOM —3'-4"
SOAP DISPENSER —3'-4"

 CUSTOMER WATER CUT - OFF VALVE

—+ HOSE BIB

 INSTANT HOT WATER HEATER

— · — · — · — COLD WATER

————— HOT WATER

SEWER
LINE

CUSTOMER
WATER
CUT - OFF

OUT TO
CITY SEWER
LINE

Plans For:

MOULTON, LIONS CLUB

Drawn by:
BRUCE REYNOLDS

Phone _____

1-256-565-2062

Trinity, Alabama

reynoldsdraftingservice@yahoo.com

Date 7-1-2018

PLUMBING PLAN

PLUMBING PLAN