




OPT. ALTERNATE KITCHEN

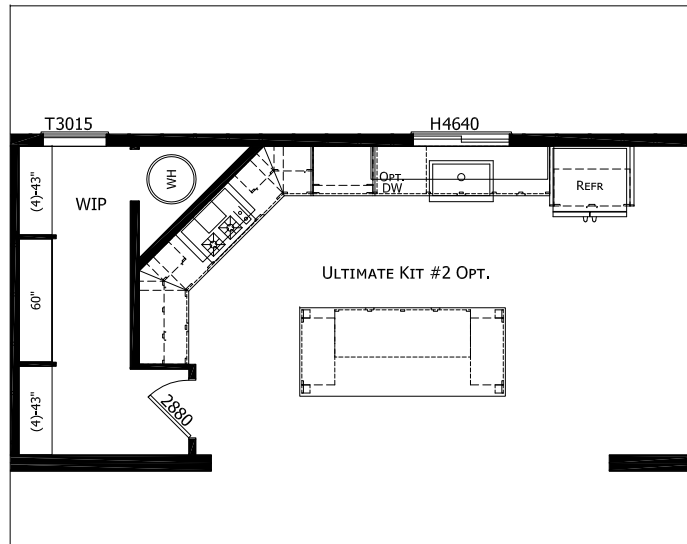


OPT. RADIANT SPA BATH

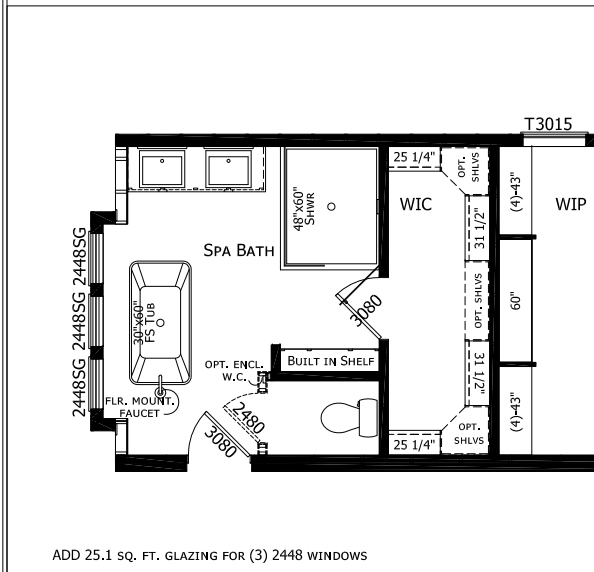

OPT. GLAMOUR BATH

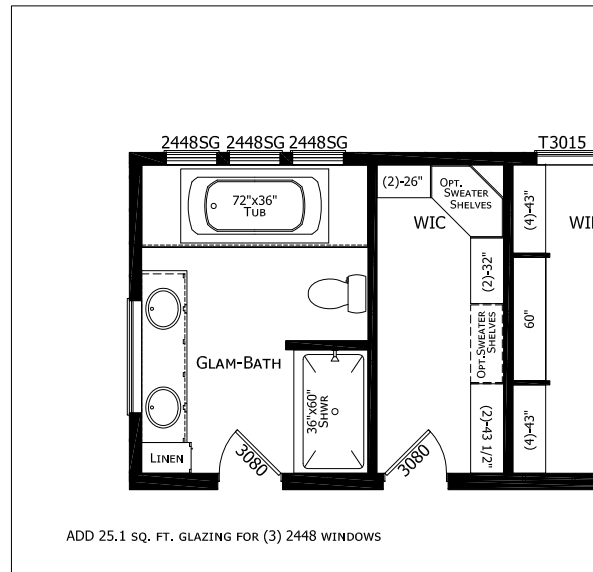

OPT. WALK-IN SHOWER

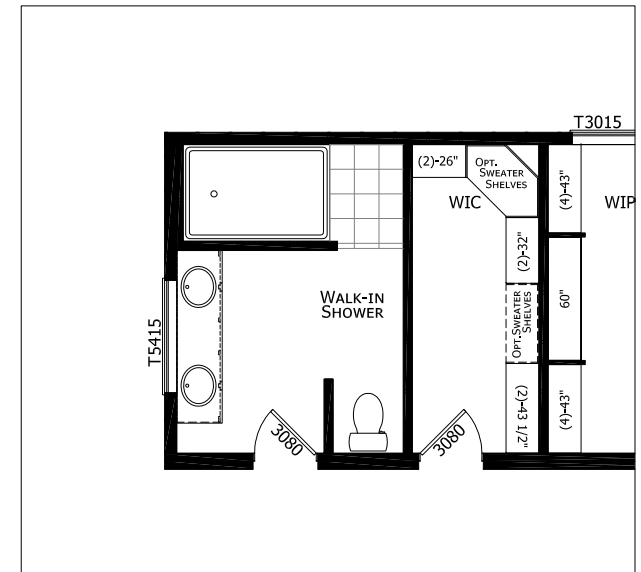

CHAMPION

MANUFACTURED BEAUTIFULLY™

1425 SUNNYSIDE RD. WEISER, ID 83672

MODIFICATIONS

PROJECT: 17-HV4623M
62' x 26'8" 3 BD 2 BTH

DRAWN BY:
DATE: 04-04-18
SCALE: 5/32" = 1'-0"

TITLE: FLOOR PLAN
ELECTRICAL PLAN
OPTIONS

FILENAME: HV4623M NOT FINISHED

SHEET: L-102 OPT

PROPRIETARY AND CONFIDENTIAL
THESE DRAWINGS AND SPECIFICATIONS ARE ORIGINAL
PROPRIETARY AND CONFIDENTIAL MATERIALS OF CHAMPION,
COPYRIGHT © 1976-2017 BY CHAMPION