

DATE:	SEPTEMBER 13, 2023
FILE:	.
DRAWN BY:	MEDS
CHECKED BY:	TC
REVISIONS:	




FORUM ARCHITECTS, LLC
415 Lincolnway East Mishawaka, Indiana
Phone: 574-233-2119
email: Info@forumarchitectsllc.com

WATERFALL BOILER & RIVERSIDE RTU REPLACEMENT
ELKHART HOUSING AUTHORITY
WATERFALL AND RIVERSIDE HIGH RISE BUILDINGS

RIVERSIDE
MECH/ELEC PLANS

ME102

FORUM
ARCHITECTS

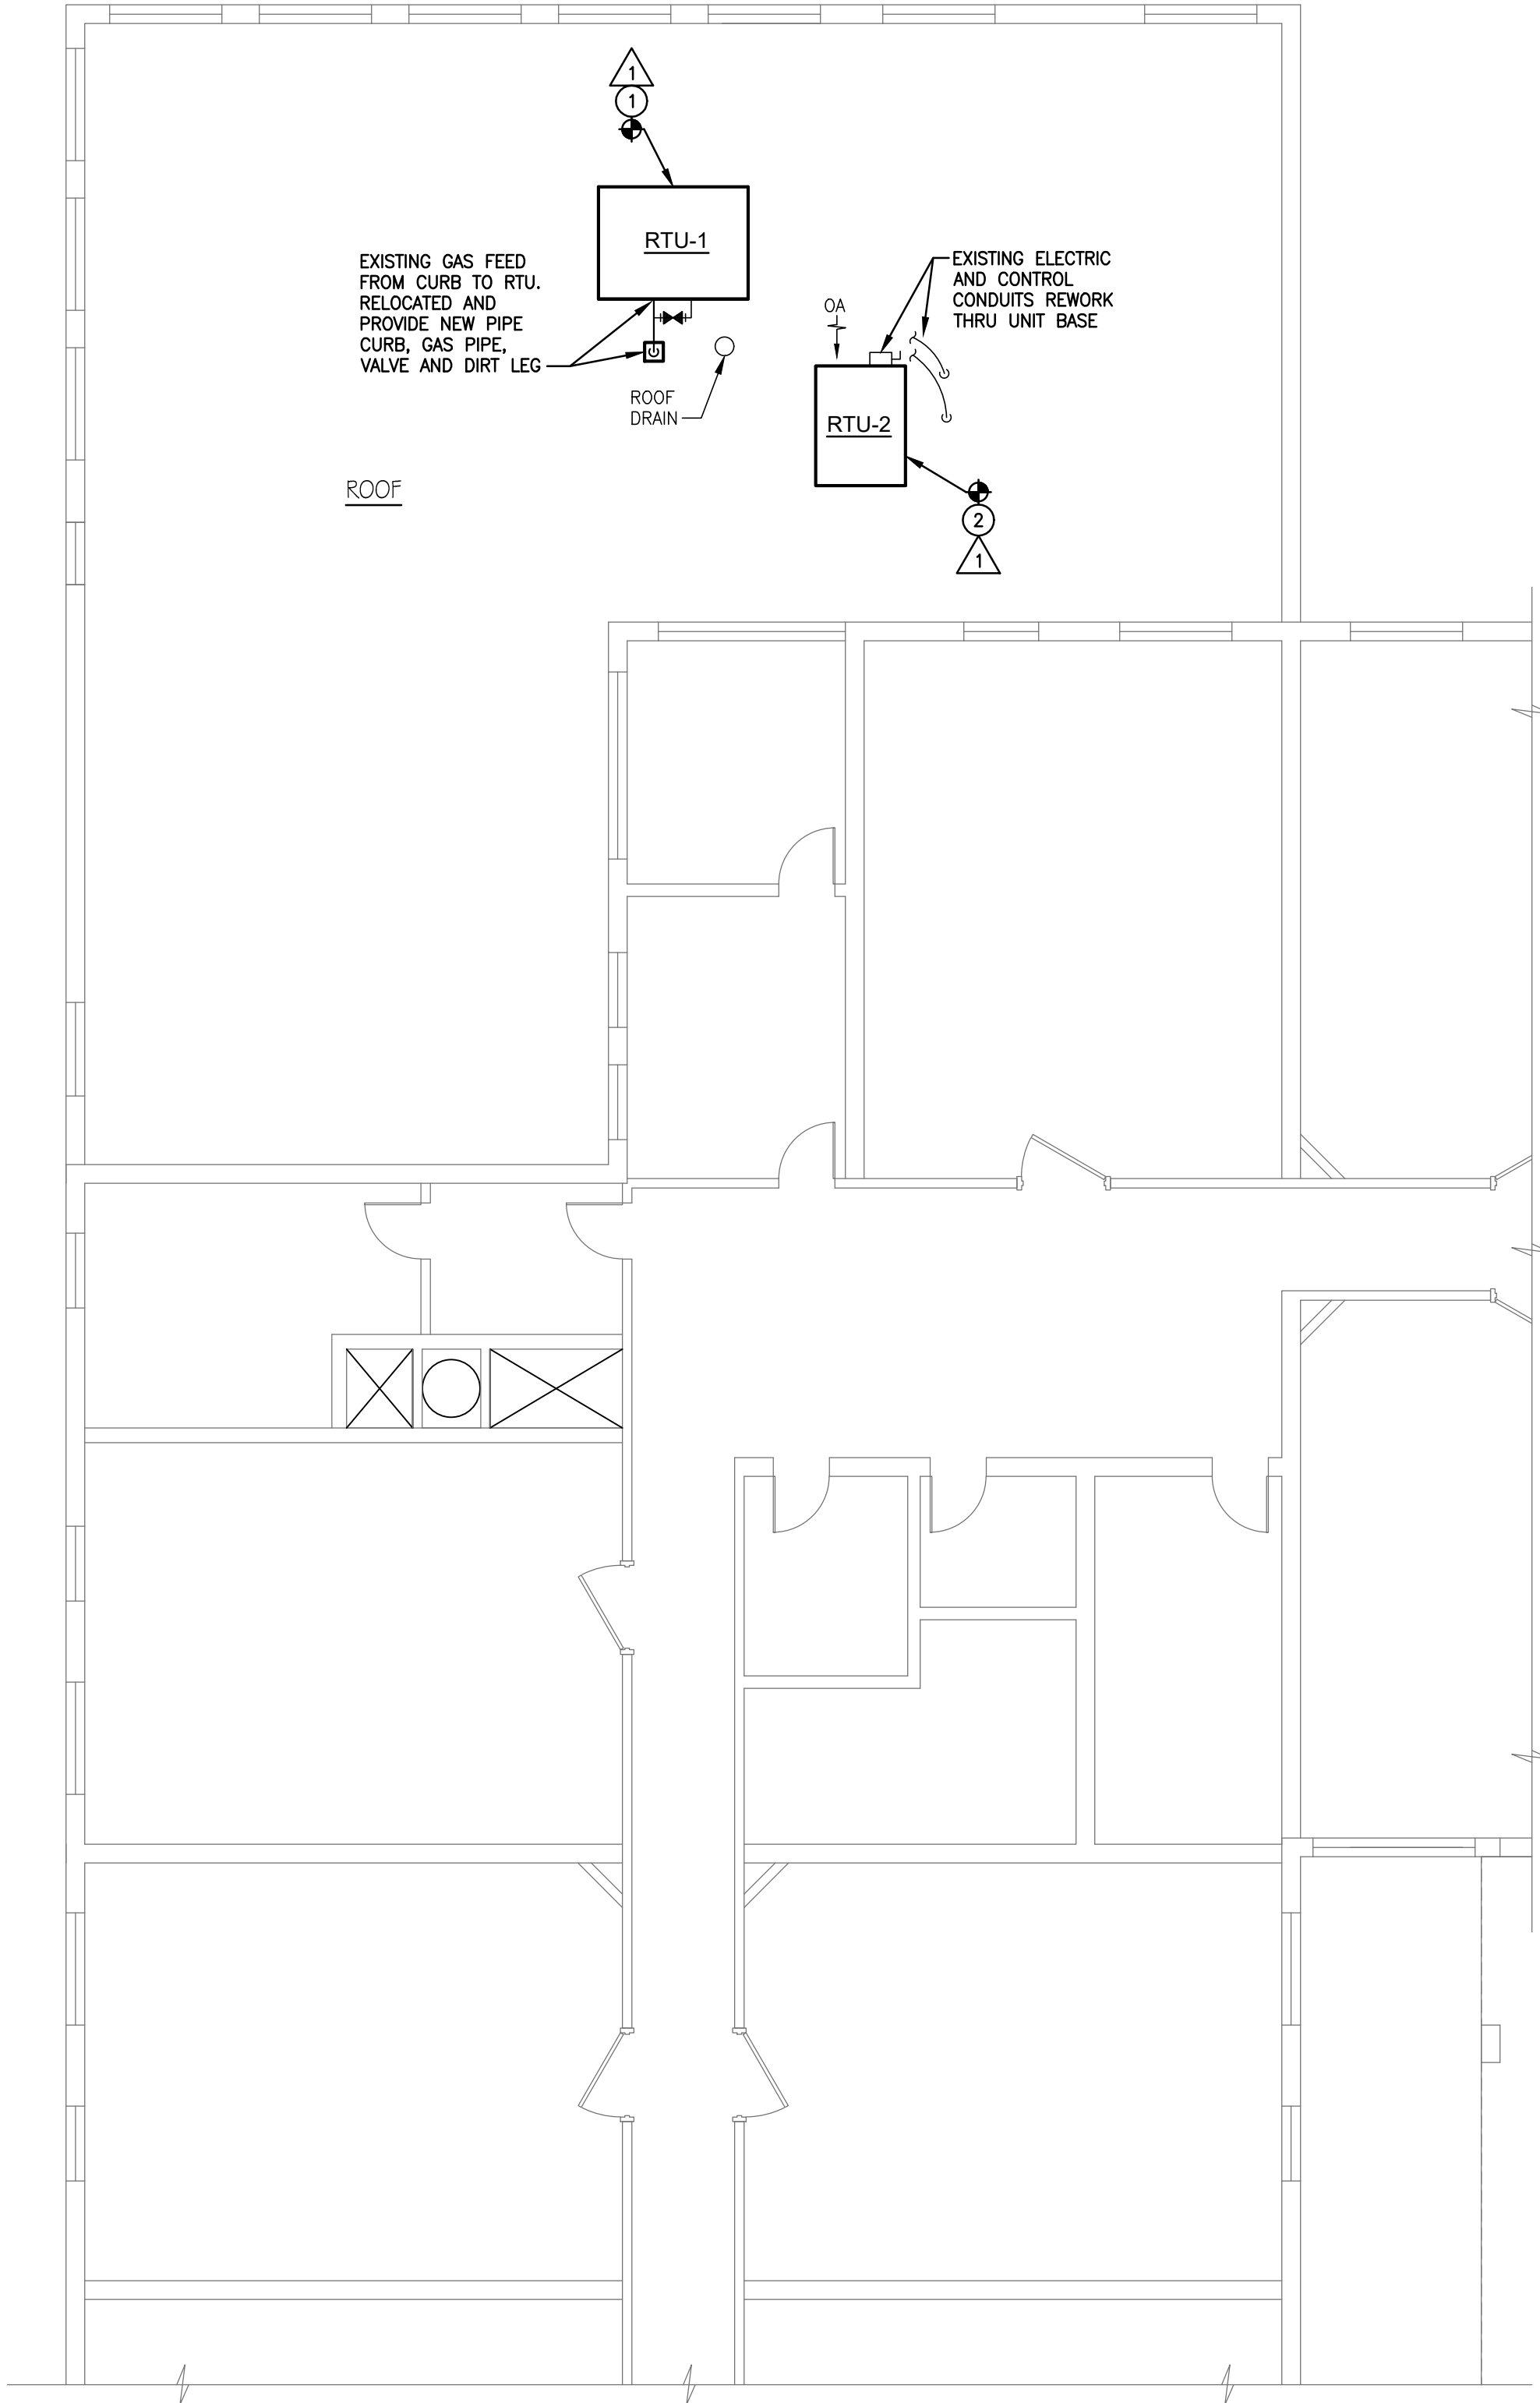


RIVERSIDE
MECH/ELEC LOWER ROOF PLAN
SCALE: 1/8" = 1'-0"

MECHANICAL NOTES

- 1 DISCONNECT, REMOVE AND REPLACE ROOFTOP UNIT IN IT'S ENTIRETY. ASSOCIATED DUCTWORK, CURB AND GAS PIPING BELOW ROOF TO REMAIN FOR REUSE. PROVIDE NEW CURB ADAPTOR, PIPE CURB, GAS AND ELECTRICAL CONNECTIONS AND CONDENSATE DRAIN. FIELD VERIFY CURB DIMENSIONS, DUCTS, ETC.
- 2 DISCONNECT, REMOVE AND REPLACE ROOFTOP UNIT IN IT'S ENTIRETY. ASSOCIATED DUCTWORK AND GAS PIPING TO REMAIN FOR REUSE. PROVIDE NEW CURB, AND ELECTRICAL CONNECTIONS AND CONDENSATE DRAIN. FIELD VERIFY CURB REQUIREMENTS, DUCTS, ETC. CUT AND PATCH ROOF AS REQUIRED.


ELECTRICAL NOTES

- 1 MECHANICAL ITEM TO BE REMOVED. DISCONNECT AND RECONNECT AS REQUIRED. COORDINATE WITH ACTUAL EQUIPMENT PROVIDED AS REQUIRED.

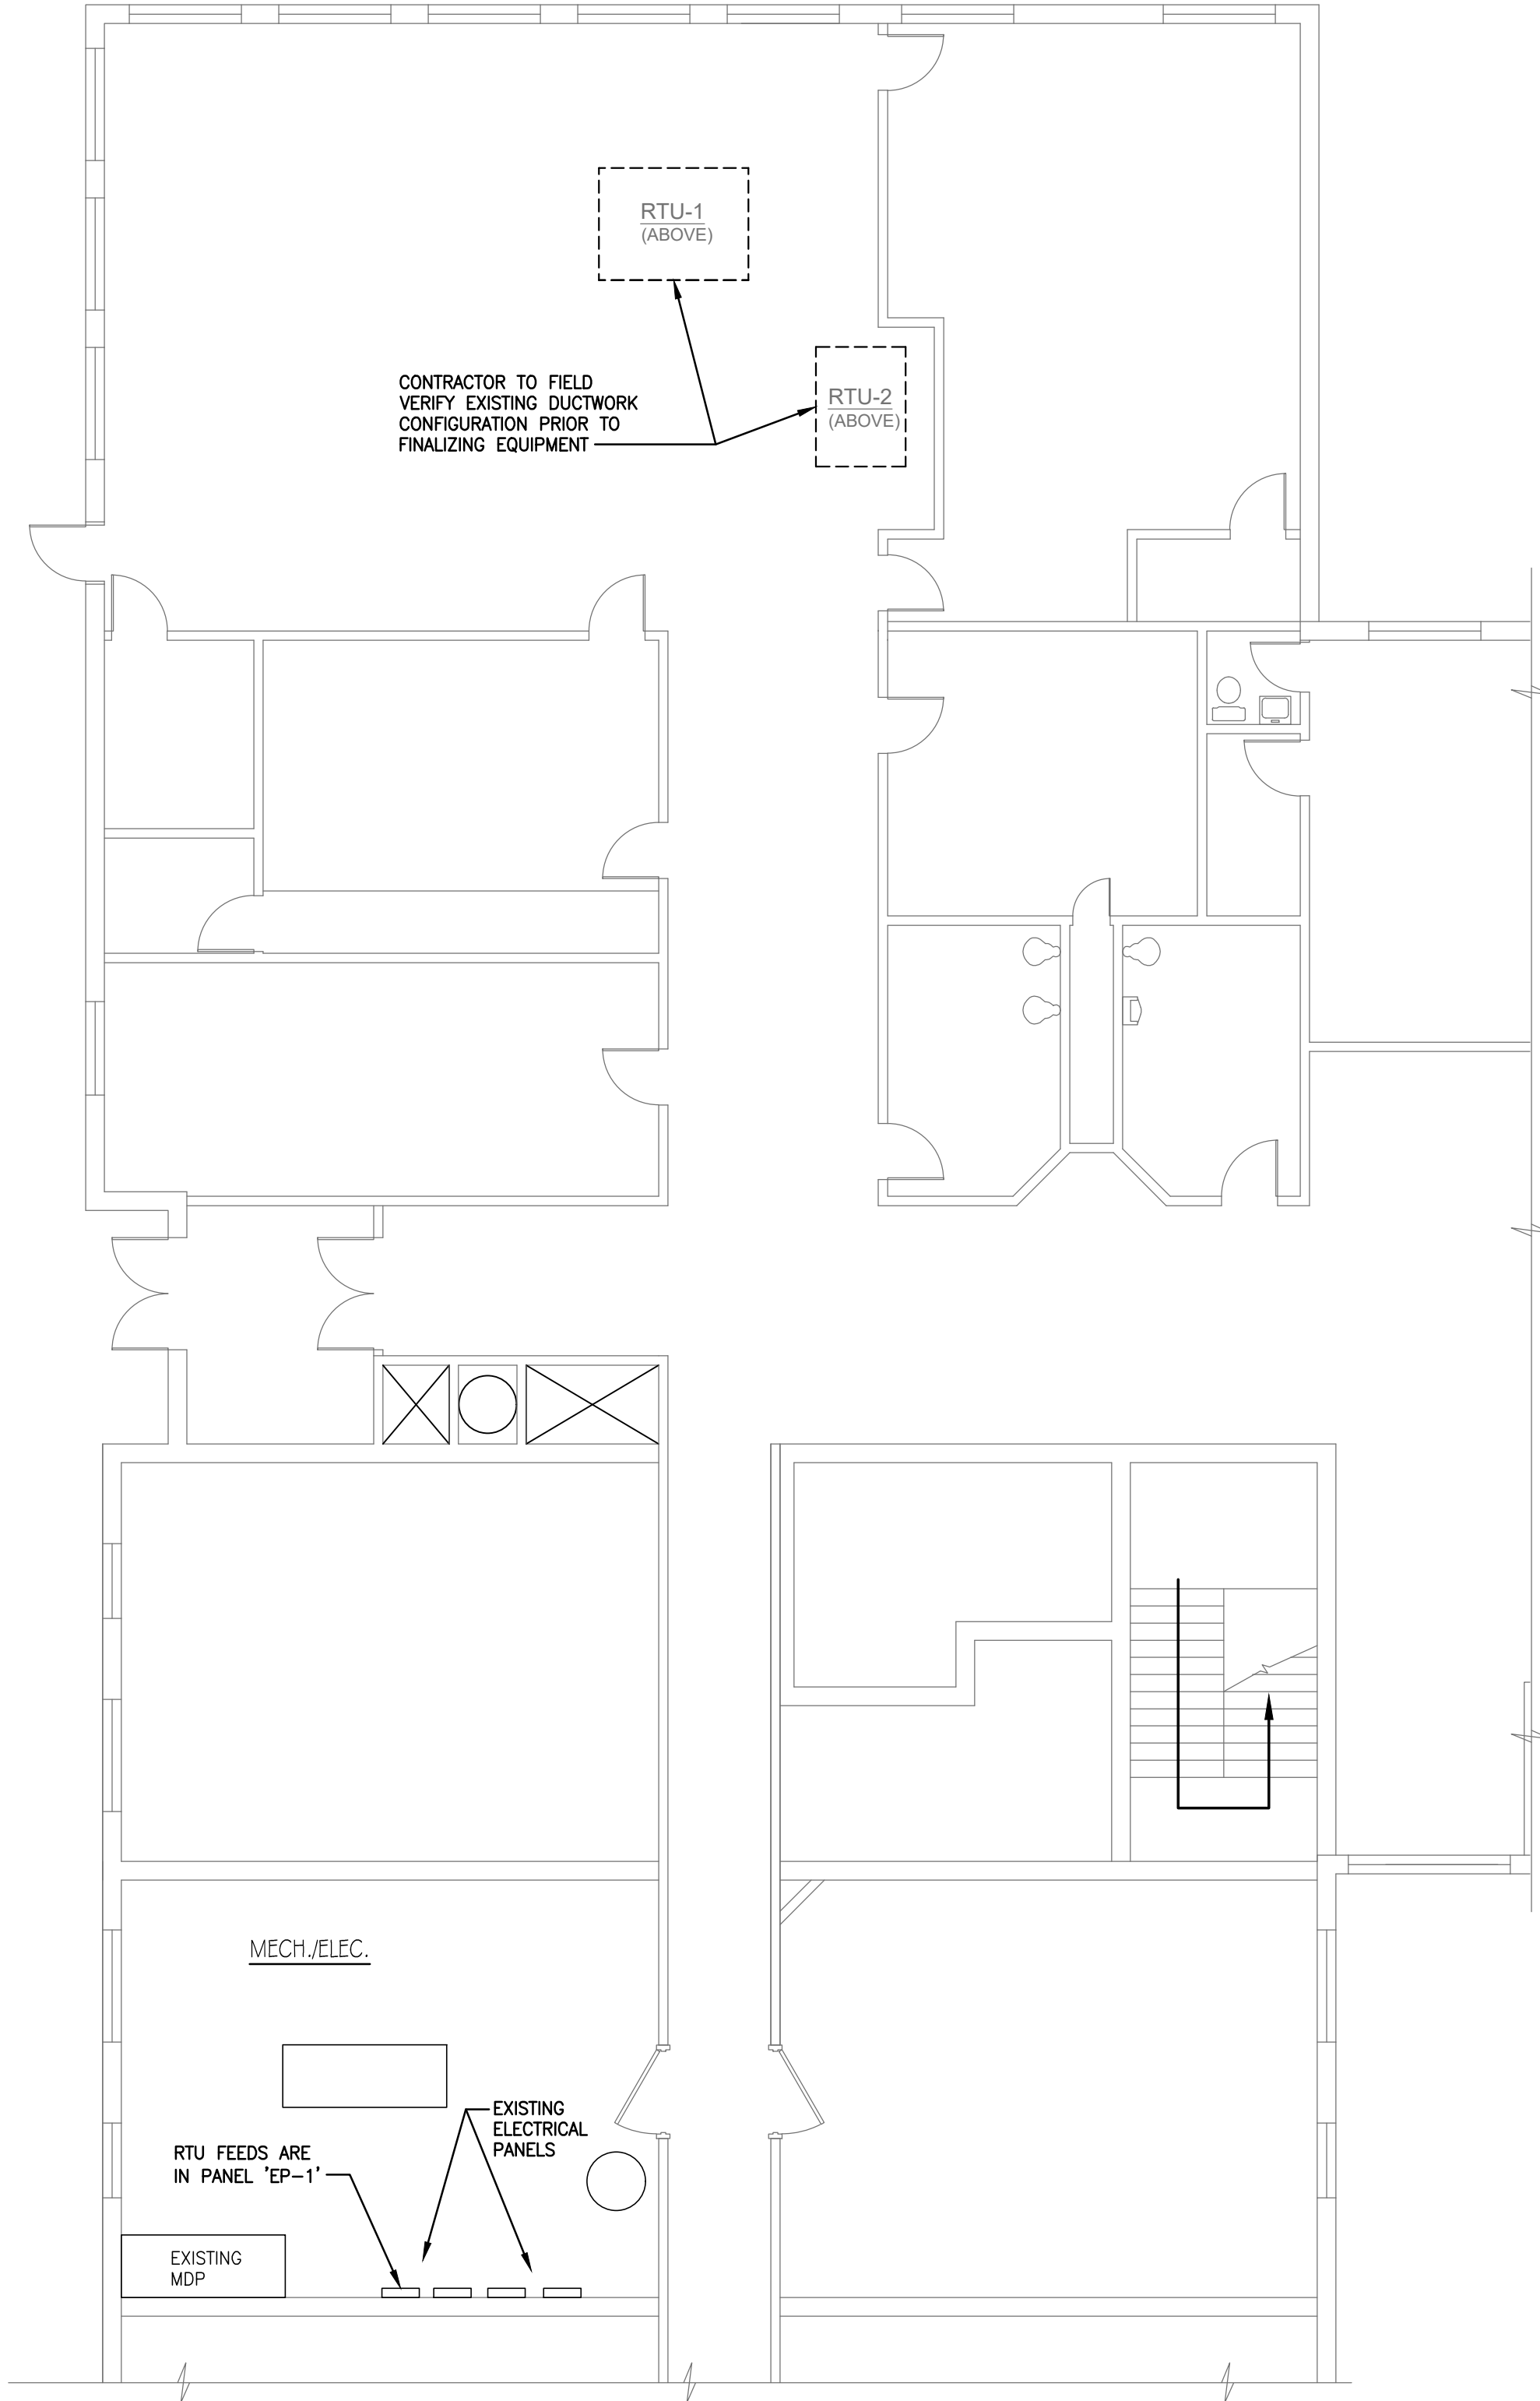

RIVERSIDE
GROUND FLOOR MECH/ELEC PLAN
SCALE: 1/8" = 1'-0"

NOTE:
THIS PLAN IS SHOWN PRIMARILY FOR REFERENCE

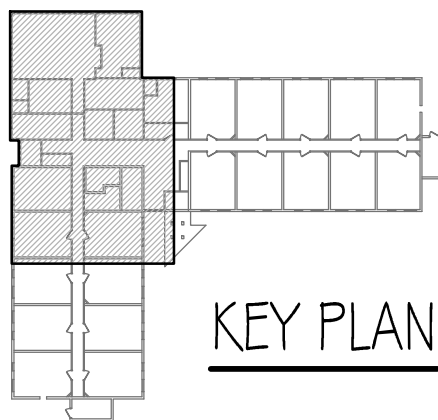

KEY PLAN