



BALL VALVE CONTROL RAVEN SCS203, 440

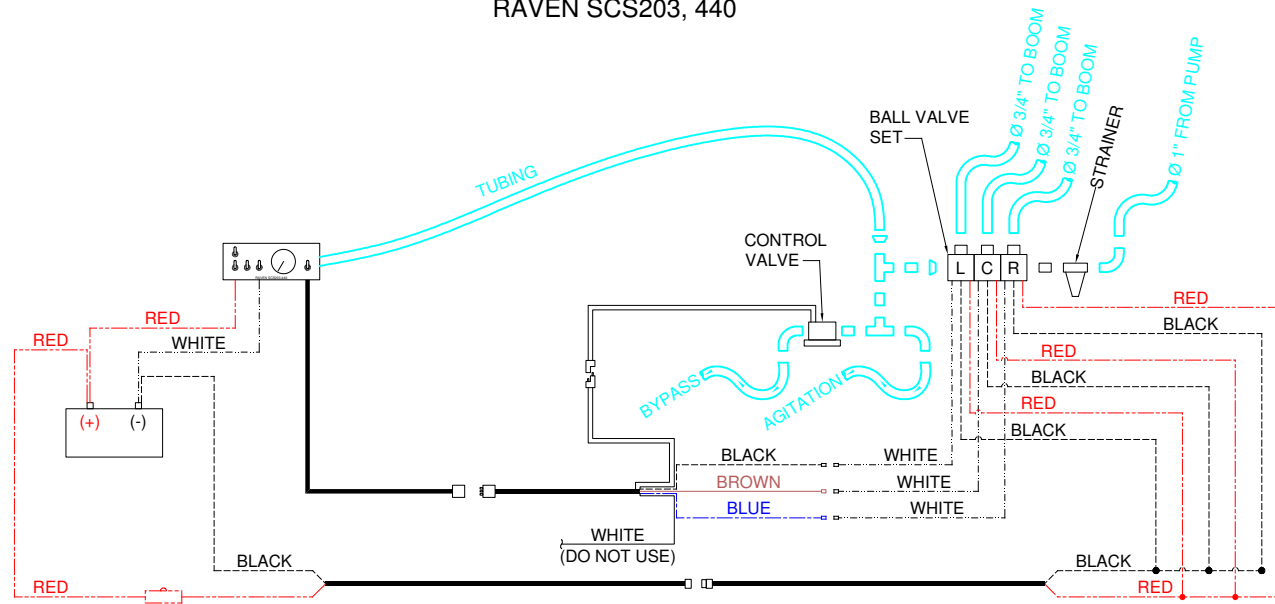

BALL VALVE CONTROL TEEJET 744

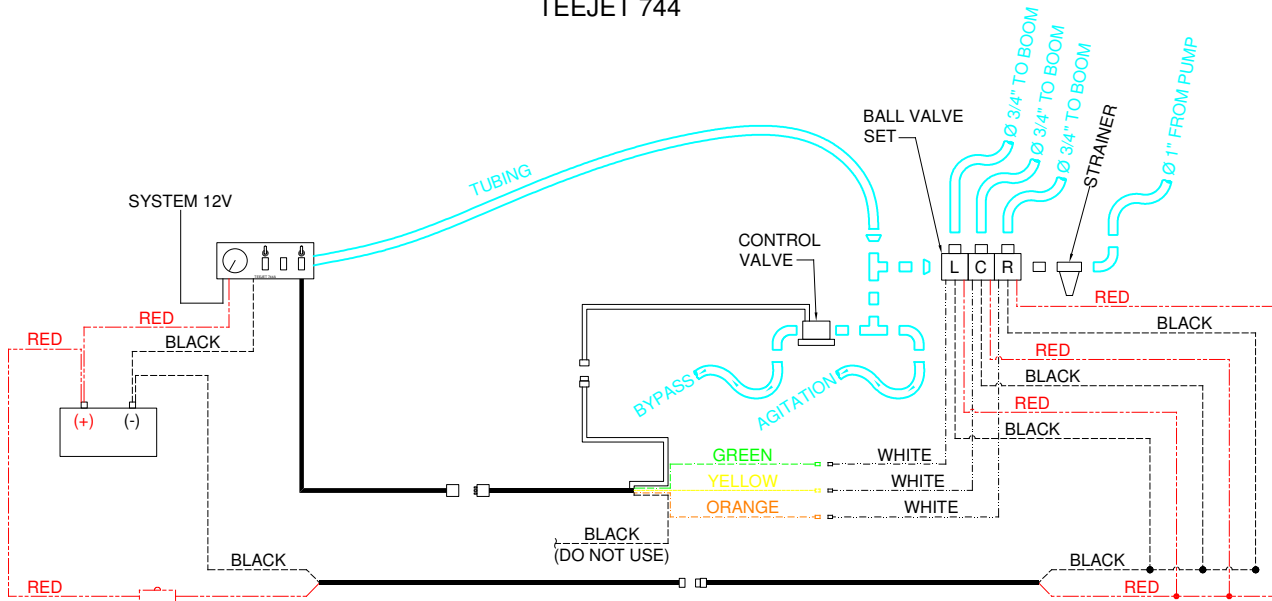

REDDICK EQUIPMENT COMPANY of NC, LLC
 P.O BOX 71 W. MAIN STREET
 WILLIAMSTON, NC 27892
 1-800-334-3388
 1-252-792-1191

DRAWN BY: DAS	DATE: 5/18/16	TITLE: WIRING SCHEMATIC: RAVEN SCS203/440 / TEEJET 744A
CHECKED BY:	DATE:	

UNLESS OTHERWISE SPECIFIED:
 • DIMENSIONS ARE IN INCHES
 • TOLERANCES:
 FRACTIONAL: +/- 1/8"
 DECIMAL: +/- .125"
 ANGULAR: +/- 5°

SHEET SIZE: A		DWG. SCALE: NTS	
DRAWING NO.:		SHEET	OF
		1	1
		REV.	A

A	DAS	CORRECTED VIEW LABEL FOR RAVEN CONTROL DIAGRAM FROM SCS230 TO SCS203.	TBD
REV.	DRAWN BY DATE	DESCRIPTION:	APPR. BY DATE

DIMS SCALE: 16 TEXT HEIGHT: 1"