


LONE STAR COLLEGE
MONTGOMERY CAMPUS – BUILDING “A”
CONROE, TEXAS

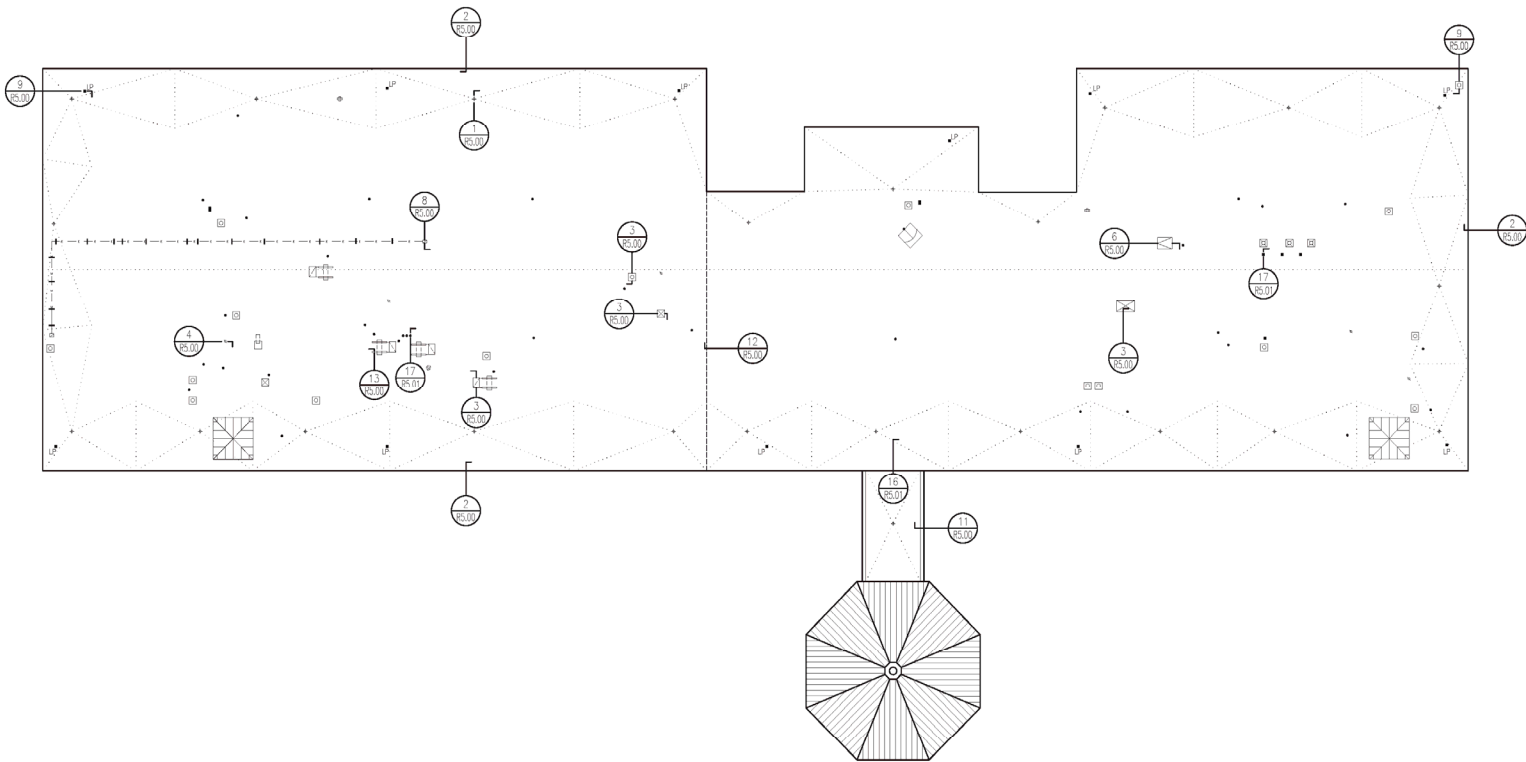

LEGEND	
	OVERFLOW DRAIN
	ROOF DRAIN
	WALL DRAIN
	SUMP DRAIN
	POWER VENT
	CURVED VENT STACK
	ABANDONED PENETRATION
	PIPING ON HANGERS
	PIPING ON SUPPORTS
	PIPING ON CURBS
	CONDENSATION DRAIN LINE
	E - ELECTRICAL CONDUIT
	G - GAS LINE
	MECHANICAL SCREEN
	CHALK / HOT WATER
	AIR TERMINAL
	THROUGH-ROOF CONNECTION
	DUCT PENETRATION
	EQUIPMENT CURBS
	VENT / ROTATE
	GRAVITY VENT
	EQUIPMENT ON SUPPORTS
	EQUIPMENT ON CURBS
	SATELLITE DISH
	ROOF-MOUNTED LADDER
	CAGED LADDER
	WALL-MOUNTED LADDER
	WALKWAY
	DOOR ACCESS
	LIGHT
	SHINGLE ROOF
	ANTENNA
	AREA IDENTIFICATION
	CORE LOCATION
	HATCHED CORE LOCATION
	PHOTO LOCATION
	SUSPENDED WET AREA
	PLUMBING VENT
	HEAT EXHAUST
	CURVED HEAT EXHAUST
	GRAVITY VENT
	TURBINE VENT
	MOISTURE RELIEF VENT
	PITCH PAN
	ROUND PENETRATION
	GOOSENECK PENETRATION
	PIPE BOX
	DWT
	EXPANSION JOINT
	ROOF-TO-WALL EXPANSION JOINT
	METAL EDGE
	DOWNSPOUT AND GUTTER
	THROUGH-WALL SCUPPER
	THROUGH-EDGE SCUPPER
	SCUPPER WITH COLLECTOR HEAD
	WALL THICKNESS INDICATOR
	WALL HEIGHT INDICATOR
	SPLASHBLOCK
	CURVED DUCT PENETRATION
	DUCT ON SUPPORTS
	DUCT ON STEEL
	ROOF HATCH
	SMOKE HATCH
	SKYLIGHT
	STRUCTURAL SKYLIGHT
	CHIMNEY
	ROUND GOOSENECK
	SQUARE GOOSENECK
	ROOF-WALL OUT WIRE ANCHOR
	TILE ROOF
	METAL ROOF
	COLUMN

NEW ROOF PLAN:
SCALE: 1/32"=1'-0" (11"x17"); 1/16"=1'-0" (22"x34")