


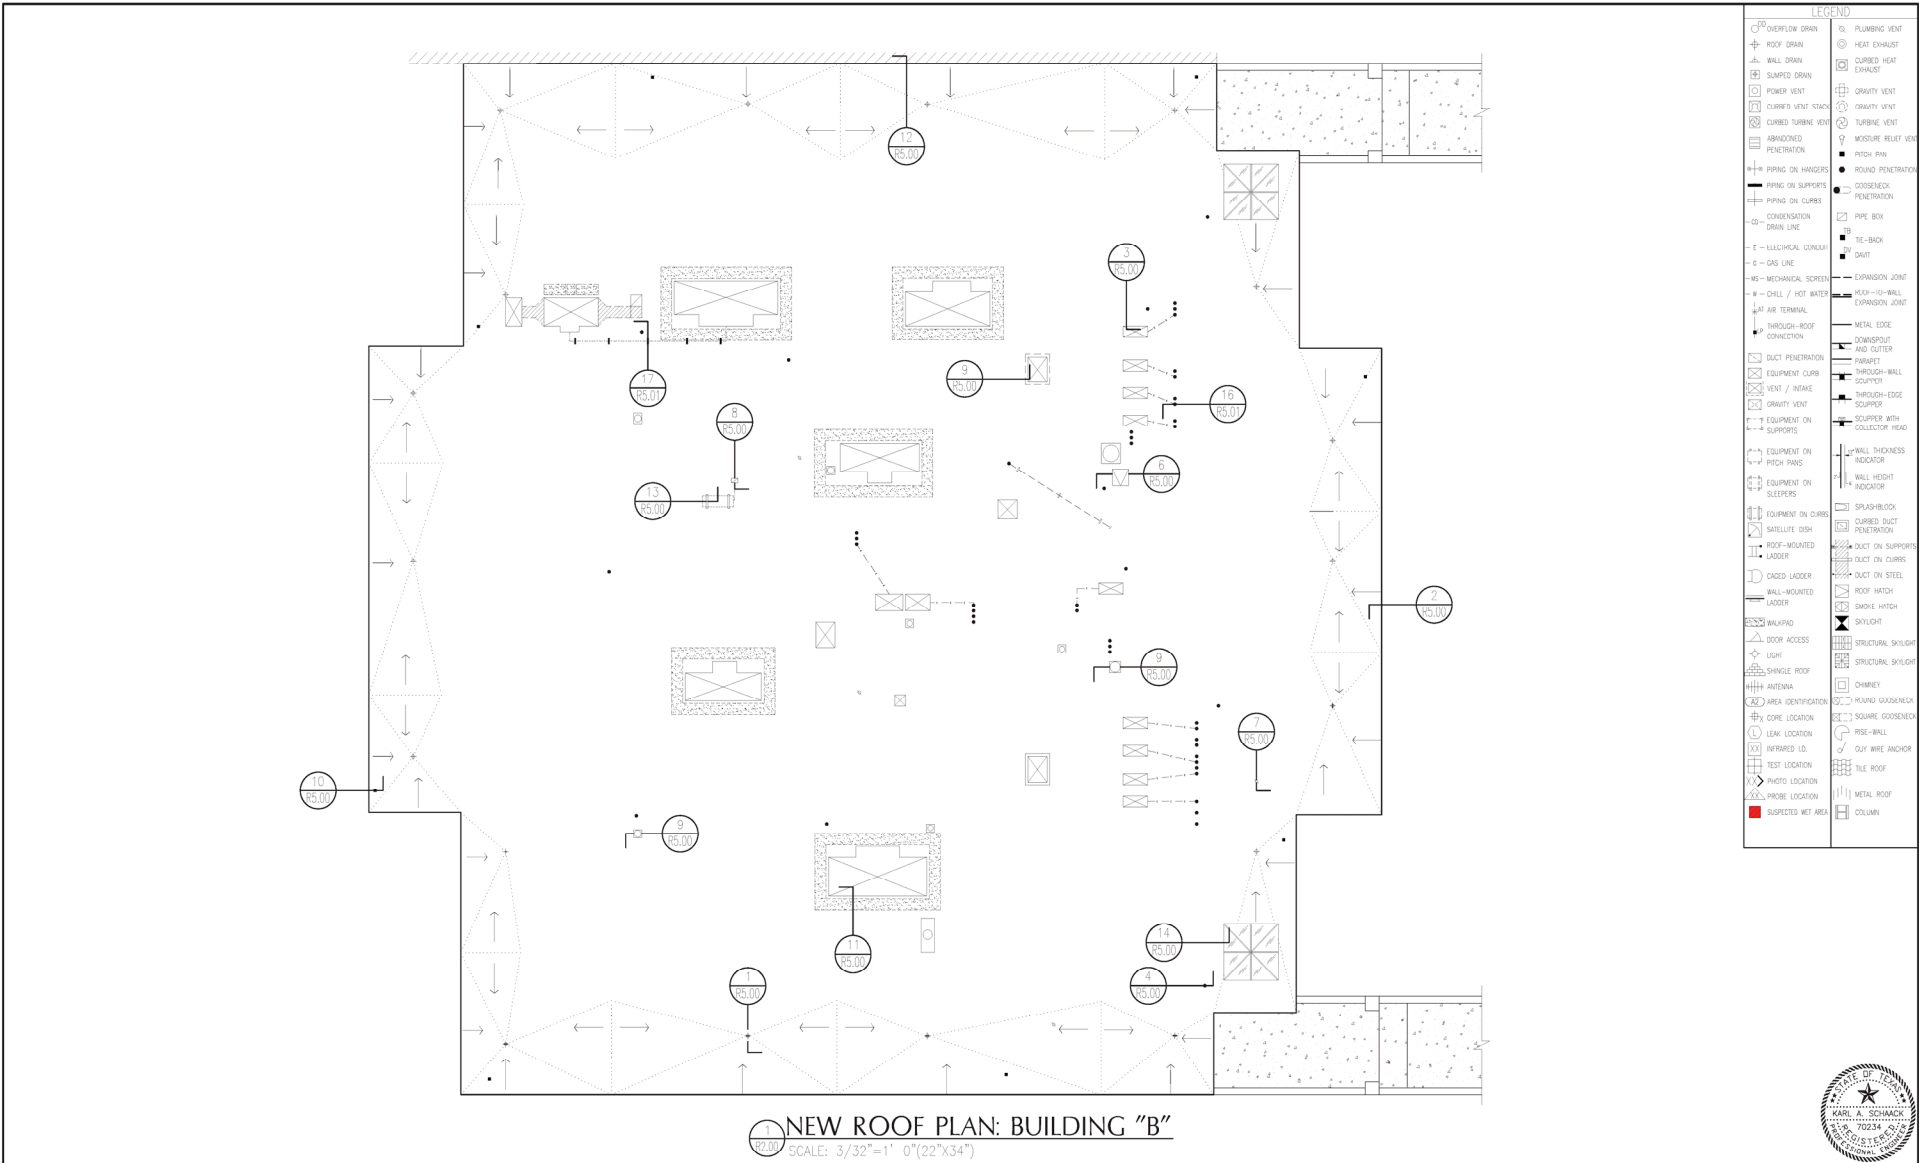

LONE STAR COLLEGE
MONTGOMERY CAMPUS – BUILDING “B”
CONROE, TEXAS



PRICE
CONSULTING
INC.

PRICE CONSULTING, INC.
211 HIGHLAND CROSS, SUITE 220
HOUSTON, TEXAS 77073
PHONE: (281)209-1724 FAX: (281)209-2724

PROJECT:
LONE STAR COLLEGE: MONTGOMERY CAMPUS-BUILDING “B”
3200 COLLEGE PARK DRIVE
CONROE, TEXAS 77384

OWNER/CLIENT:
LONE STAR COLLEGE SYSTEM
20515 STATE HIGHWAY 249
HOUSTON, TEXAS 77070

REVISIONS		
NO.	DATE	BY

NEW ROOF PLAN
PCI PROJECT NO.: 11952.21
PCI FILE NAME: R2.00-R2.01
SCALE: AS NOTED



DWN.BY: DATE:
ESG 02/15/22
SHEET:
R2.01

