




STARK FOUNDATION
STARK MUSEUM OF ART
ORANGE, TEXAS

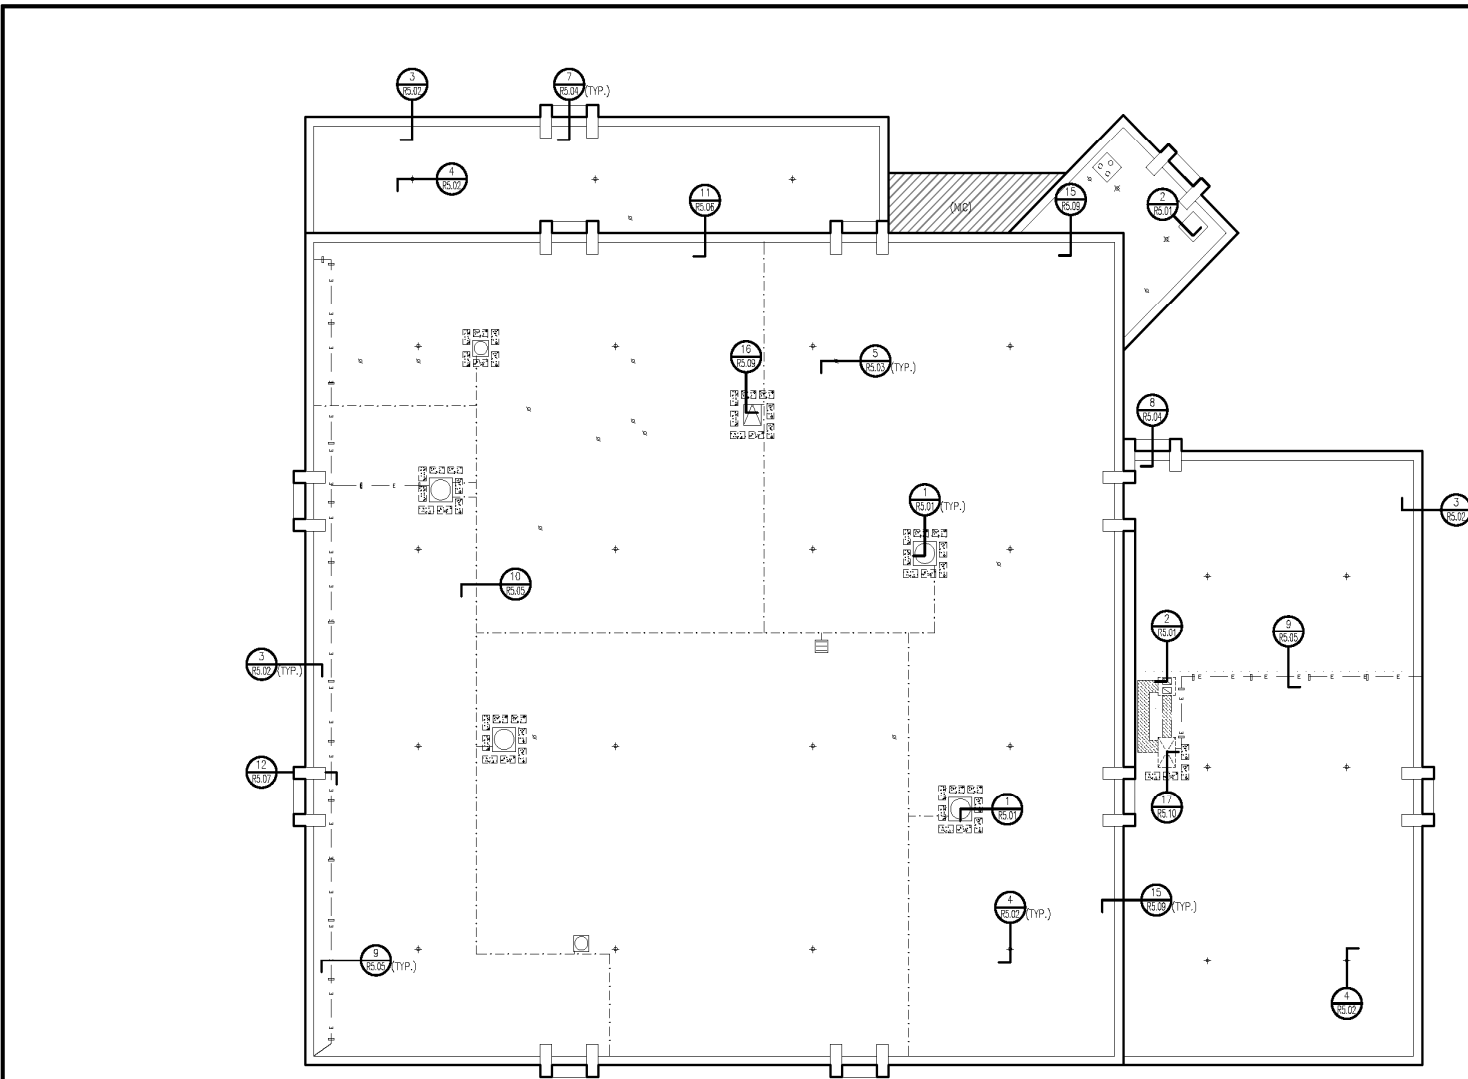

LEGEND	
	OVERFLOW DRAIN
	ROOF DRAIN
	WALL DRAIN
	SEWER DRAIN
	POWER VENT
	CURVED VENT STACK
	ATTACHED PENETRATION
	PIPING ON HANGERS
	PIPING ON SUPPORTS
	PIPING ON CURB
	CONDENSATION DRAIN LINE
	ELECTRICAL CONDUIT
	GAS LINE
	MECHANICAL SCREEN
	CHILL / HOT WATER AIR TERMINAL
	THROUGH-ROOF CONNECTION
	EQUIPMENT ON CURB
	VENT / INLET
	GRAVITY VENT
	EQUIPMENT ON SUPPORTS
	EQUIPMENT ON PITCH PAVERS
	EQUIPMENT ON SLEEPERS
	EQUIPMENT ON CURB
	SATELLITE DISH
	ROOF-MOUNTED LADDER
	SHED LADDER
	WALL-MOUNTED LADDER
	WALKWAY
	ROOF ACCESS
	LIGHT
	SHINGLE ROOF
	CORE AREA IDENTIFICATION
	CORE LOCATION
	LEAK LOCATION
	INSPECTED I.D.
	TEST LOCATION
	PHOTO LOCATION
	PROBE LOCATION
	SUSPECTED WET AREA
	PLUMBING VENT
	HEAT EXHAUST
	CURVED HEAT EXHAUST
	GRAVITY VENT
	GRAVITY VENT
	MOISTURE RELIEF VENT
	PITCH PAVE
	ROUND PENETRATION
	GOOSE-NECK PENETRATION
	PIPE BOX
	TEE-STACK
	DRAIN
	EXPANSION JOINT
	ROOF-TO-WALL LAP/JOINT
	METAL EDGE
	DOWNSPOUT AND GUTTER
	PARAPET
	THROUGH-WALL SCUPPER
	THROUGH-EDGE SCUPPER
	SCUPPER WITH COLLECTOR HEAD
	WALL THICKNESS INDICATOR
	WALL HEIGHT INDICATOR
	SPLASHBLOCK
	CURVED DUCT PENETRATION
	DUCT ON SUPPORTS
	DUCT ON CURB
	DUCT ON STEEL LADDER
	ROOF HATCH
	SMOKE HATCH
	SKYLIGHT
	STRUCTURAL SKYLIGHT
	CHIMNEY
	ROUND GOOSE-NECK
	SQUARE GOOSE-NECK
	RISE-WALL
	GUY WIRE ANCHOR
	TILE ROOF
	METAL ROOF
	COLUMN

NEW ROOF PLAN: STARK MUSEUM OF ART
SCALE: 1"=20'-0" (11'x17'); 1"=10'-0" (22'x34')



PRICE CONSULTING, INC.
7122 WORCESTER DRIVE, SUITE A
SPRING, TEXAS 77379
PHONE: (281)209-1724

PROJECT:
STARK MUSEUM OF ART
712 GREEN AVE
ORANGE, TX

OWNER/CLIENT:
STARK FOUNDATION
601 GREEN AVE
ORANGE, TX 77630

REVISIONS		
NO.	DATE	BY

EXISTING ROOF PLAN
PCI PROJECT NO.: 12159.23
PCI FILE NAME: R2.00
SCALE: AS NOTED



DWN BY: DATE:
ESG/RH 09/13/23
SHEET:
R2.01

